



--

REVISION TABLE		REVISION BY	DESCRIPTION
NUMBER	DATE		

--


Project Overview

DRAWINGS PROVIDED BY:
BC

DATE:
10/4/2025

SCALE:

SHEET:
P-1

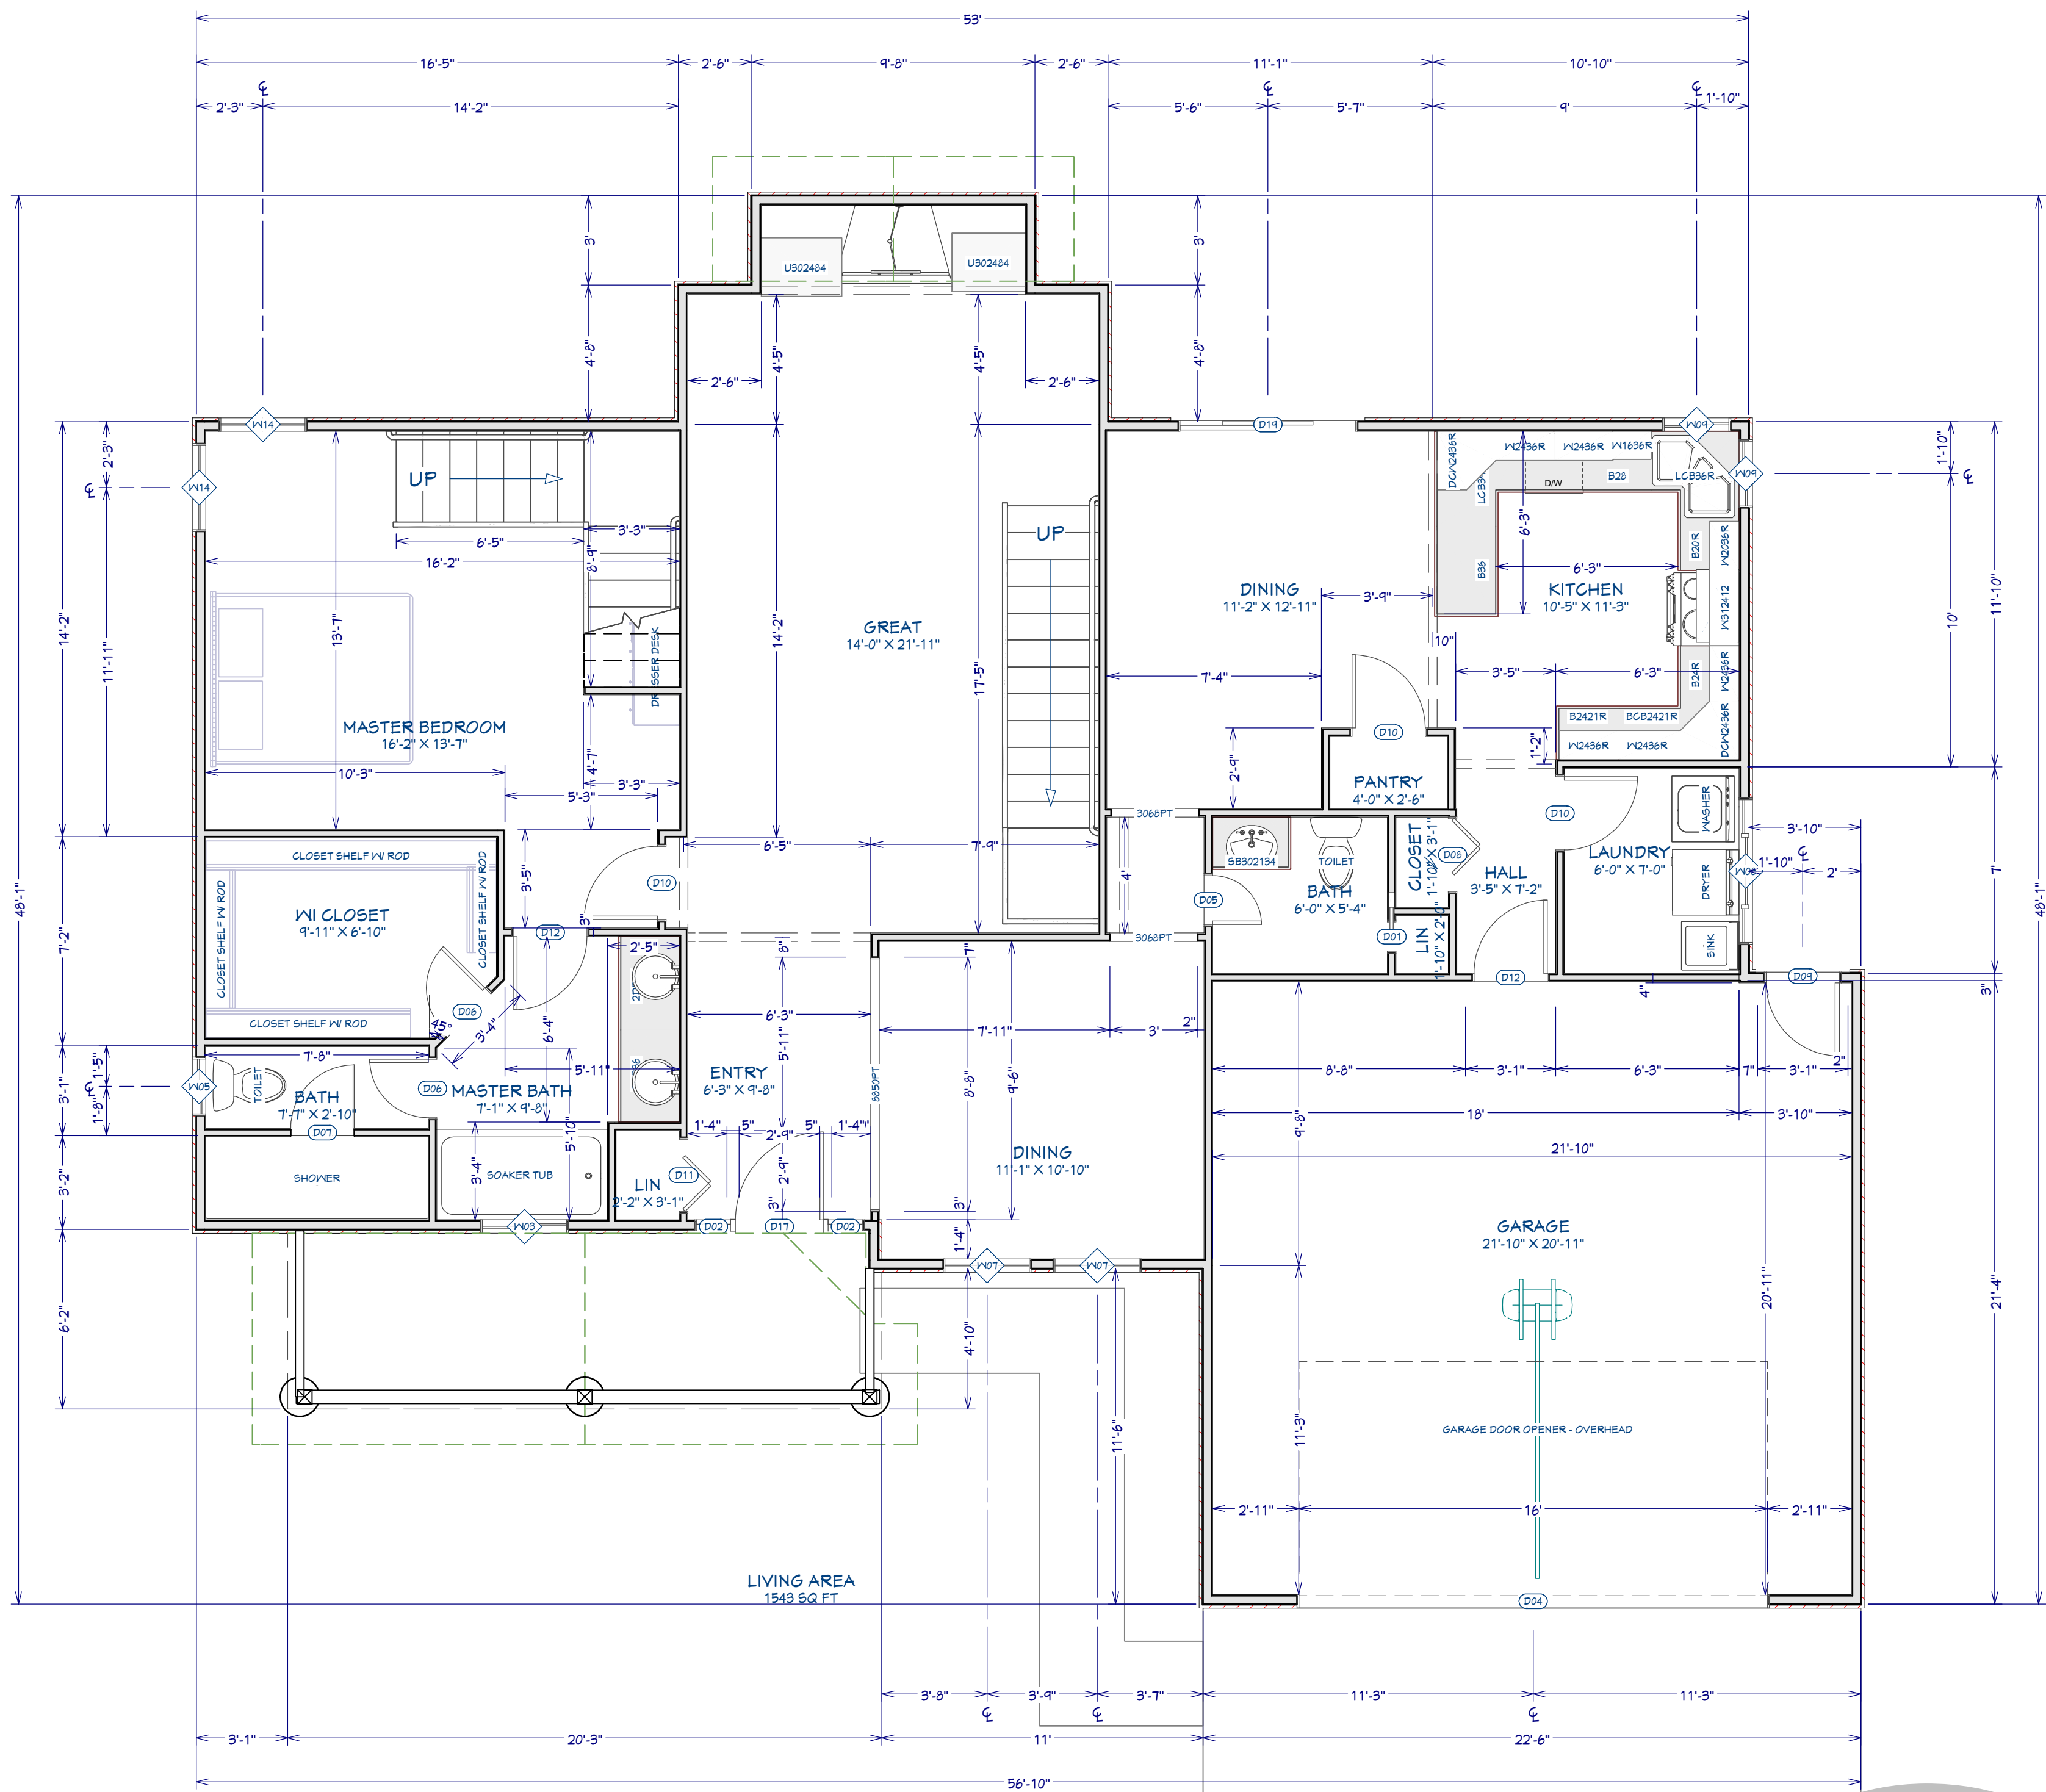

Floor Plan View Dimensioned
1/4"=1'-0"

DOOR SCHEDULE						
NUMBER	LABEL	QTY	FLOOR	SIZE	R/O	HEADER
D01	1088	1	1	1088 R	45 1/4"x82 1/2"	2x6x26 1/4" (2)
D02	1288	2	1	1288	16"x35"	2x6x14" (2)
D03	1488	1	2	1488 R EX 18 1/2"x83"	4x5 1/2x21 1/2" (2)	2x6x14" (2)
D04	16080	1	1	16080	194"x94"	2x12x200" (2)
D05	1888	1	1	1888 R IN	22"x82 1/2"	2x6x25" (2)
D06	2088	2	1	2088 R IN	26"x82 1/2"	2x6x24" (2)
D07	2288	1	1	2288 R	26"x80"	
D08	2888	1	1	2888 L	32"x82 1/2"	2x6x35" (2)
D09	2888	1	1	2888 L EX	32"x83"	4x5 1/2x35" (2)
D10	2888	3	1	2888 LIN	32"x82 1/2"	2x6x35" (2)
D11	2888	1	1	2888 R	31 9/16"x82 1/2"	2x6x34 9/16" (2)
D12	2888	2	1	2888 R IN	32"x82 1/2"	2x6x35" (2)
D13	2888	1	2	2888	32"x82 1/2"	2x6x35" (2)
D14	2888	2	2	2888 LIN	32"x82 1/2"	2x6x35" (2)
D15	2488	1	2	2488 LIN	30"x82 1/2"	2x6x35" (2)
D16	2888	3	2	2888 R IN	32"x82 1/2"	2x6x35" (2)
D17	3088	1	1	3088 R IN	35"x82 1/2"	2x6x41" (2)
D18	5088	2	2	5088 L/R	62"x82 1/2"	2x6x65" (2)
D19	6088	1	1	6088 R EX 14"x83"		2x10x11" (2)

WINDOW SCHEDULE						
NUMBER	LABEL	QTY	FLOOR	SIZE	R/O	EGRESS
W01	2020	1	2	2020	25"x25"	YES
W02	2020	1	3	2020	25"x25"	YES
W03	3040RS	1	1	3040RS	37"x44"	YES
W04	2020FX	4	2	2020FX	25"x25"	YES
W05	2020RS	1	1	2020RS	25"x31"	YES
W07	3040DH	2	1	3040DH	37"x44"	YES
W08	5020TS	1	1	5020TS	61"x25"	YES
W09	2450RS	2	1	2450RS	44"x31"	YES
W10	4020FX	3	2	4020FX	44"x25"	YES
W11	4020FX	1	2	4020FX	44"x25"	YES
W12	4040DH	1	2	4040DH	44"x44"	YES
W14	3050DH	2	1	3050DH	37"x61"	YES
W15	3050DH	2	2	3050DH	37"x61"	YES



REVISION TABLE		REVISION BY		DESCRIPTION	
NUMBER	DATE				


1st. Floor Plan View
Dimensioned

DRAWINGS PROVIDED BY:
BC

DATE:
10/4/2025

SCALE:

SHEET:

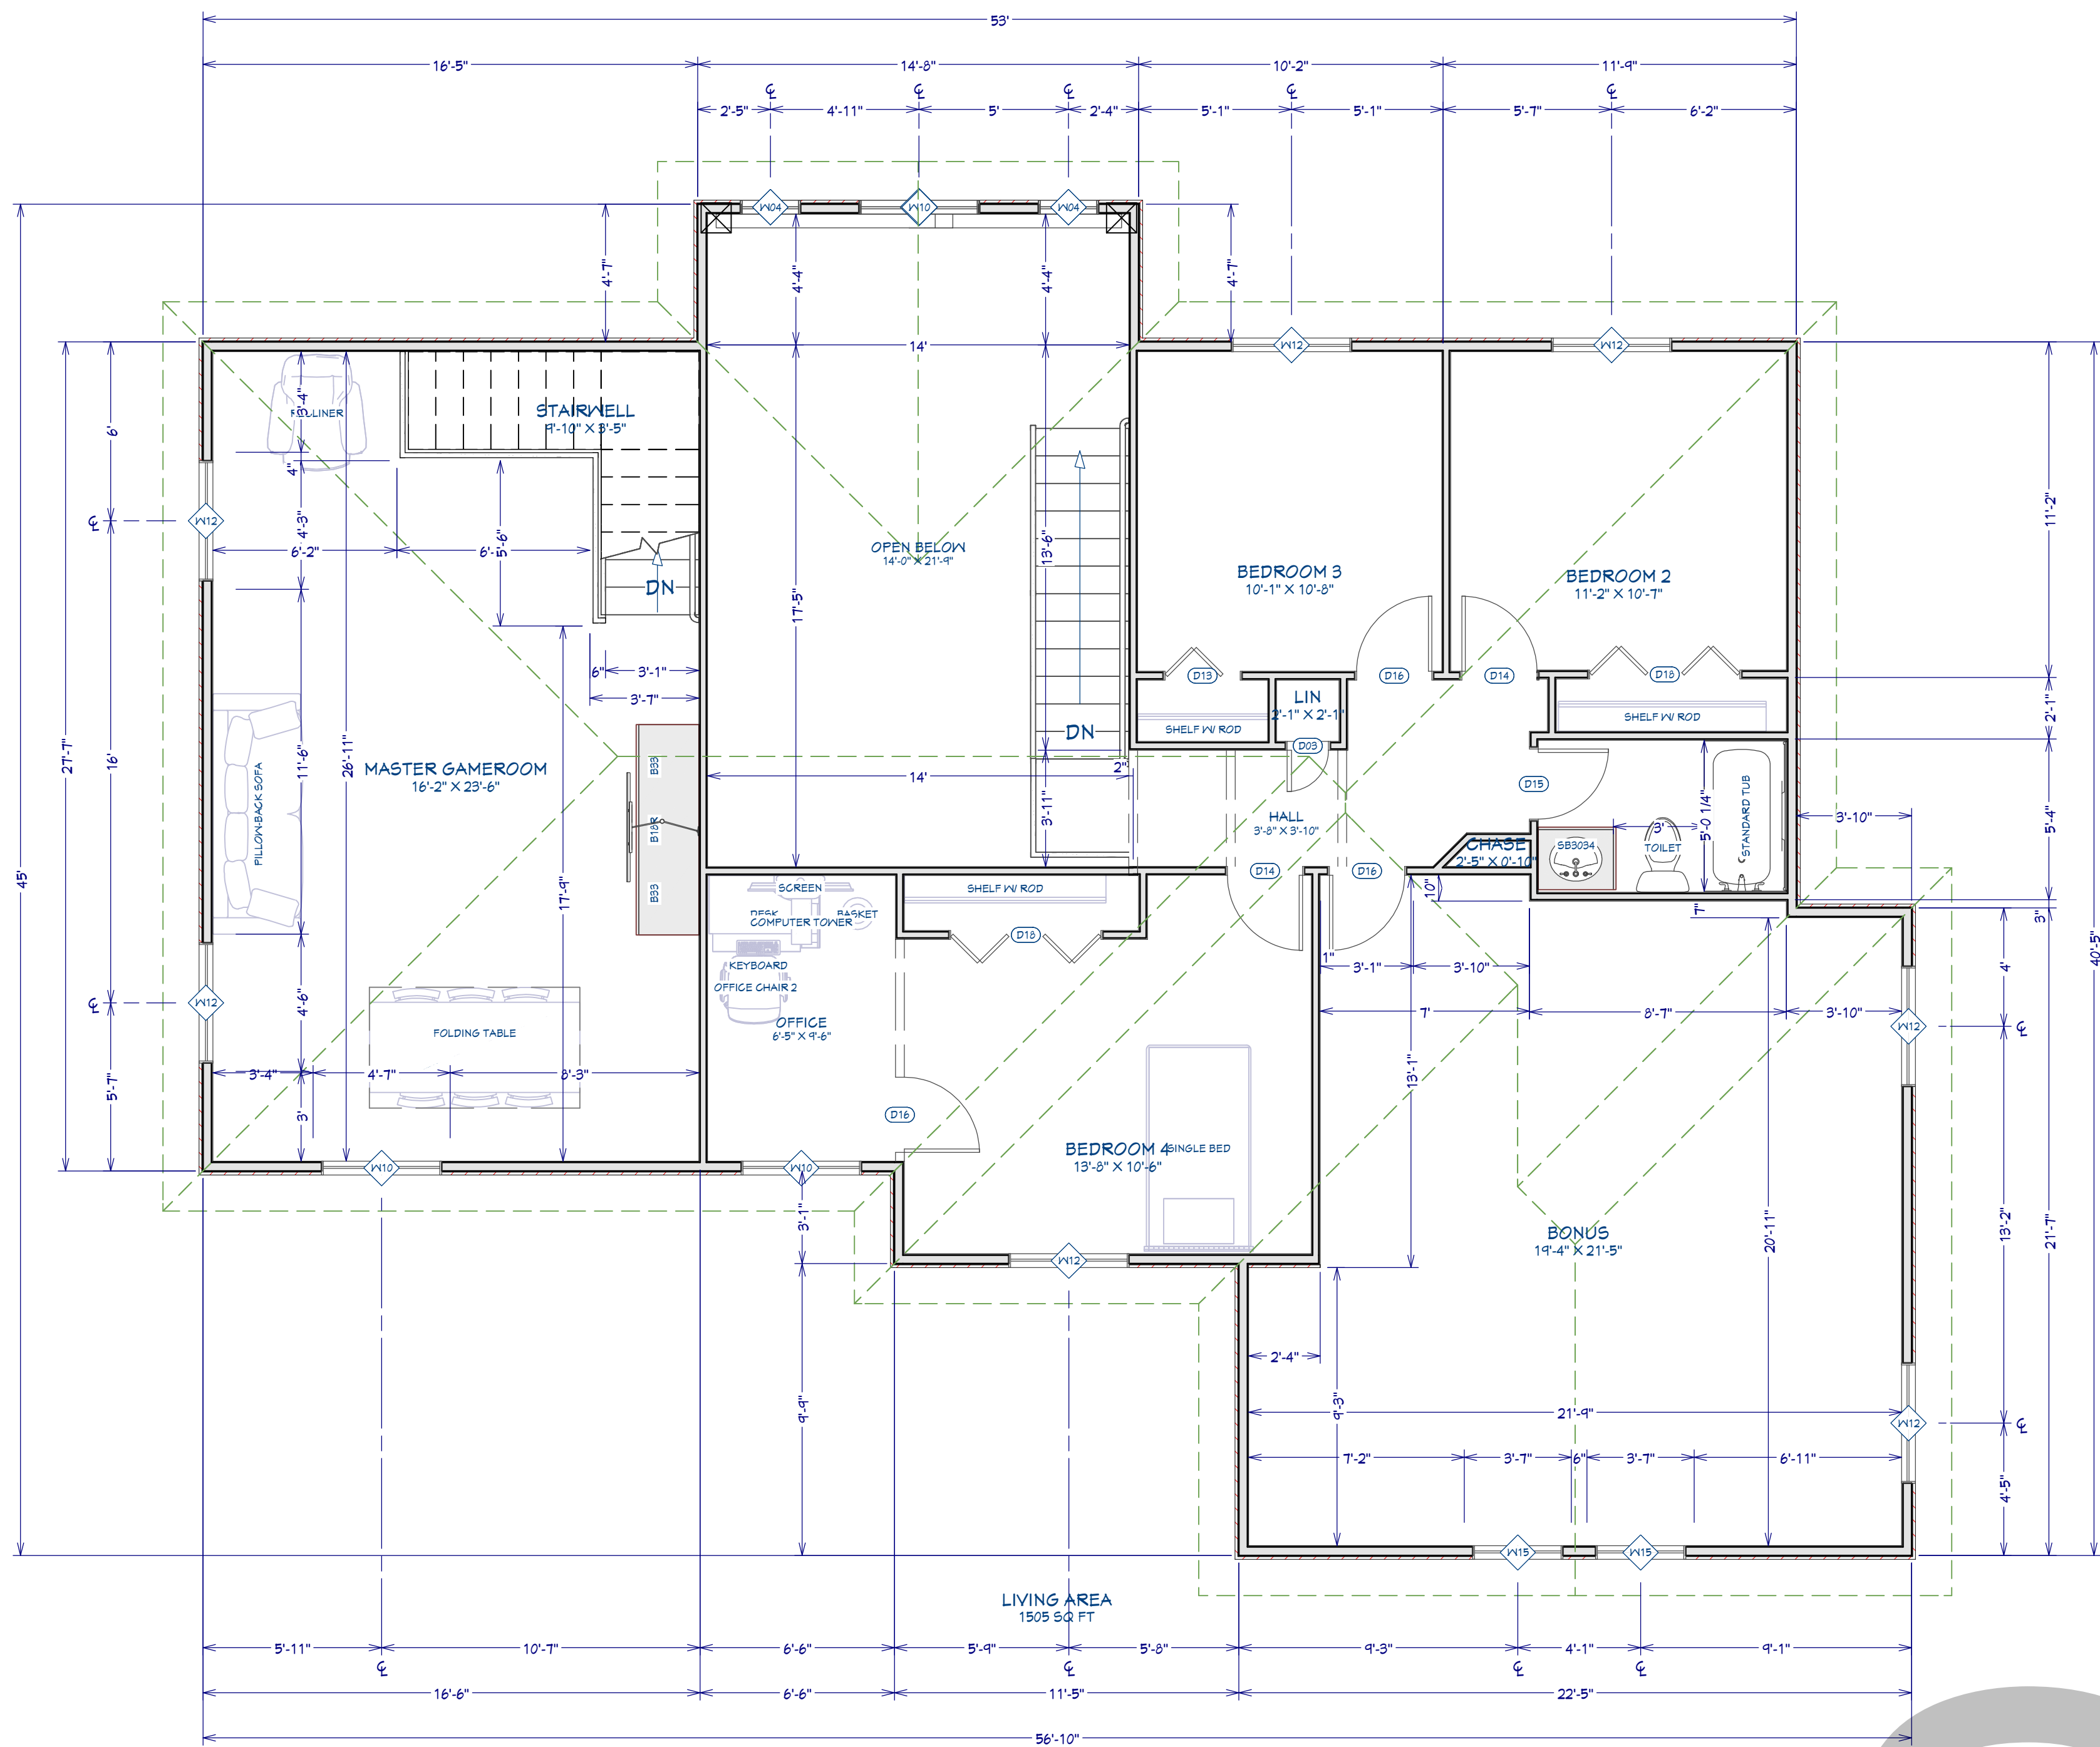

DOOR SCHEDULE						
NUMBER	LABEL	QTY	FLOOR	SIZE	R/O	HEADER
D01	1065	1	1	1065 R	25 1/4"X62 1/2"	2X6X25 1/4" (2)
D02	1265	2	1	1265	15"X35"	2X6X15" (2)
D03	1465	1	2	1465 R EX	18 1/2"X35"	4X5 1/2X31 1/2" (2)
D04	16250	1	1	16250	144"X94"	2X12X200" (2)
D05	1865	1	1	1865 R IN	22"X33 1/2"	2X6X33 1/2" (2)
D06	2065	2	1	2065 R IN	26"X32 1/2"	2X6X32 1/2" (2)
D07	2265	1	1	2265 R	26"X30"	2X6X30" (2)
D08	2665	1	1	2665 L	32"X32 1/2"	2X6X35" (2)
D09	2665	1	1	2665 L EX	32"X35"	4X5 1/2X35" (2)
D10	2665	3	1	2665 L IN	32"X32 1/2"	2X6X35" (2)
D11	2665	1	1	2665 R	31 5/16"X32 1/2"	2X6X34 9/16" (2)
D12	2665	2	1	2665 R IN	32"X32 1/2"	2X6X35" (2)
D13	2665	1	2	2665 L	32"X32 1/2"	2X6X35" (2)
D14	2665	2	2	2665 L IN	32"X32 1/2"	2X6X35" (2)
D15	2465	1	2	2465 L IN	30"X32 1/2"	2X6X33" (2)
D16	2665	3	2	2665 R IN	32"X32 1/2"	2X6X35" (2)
D17	5065	1	1	5065 R IN	33"X32 1/2"	2X6X41" (2)
D18	5065	2	2	5065 L/R	62"X32 1/2"	2X6X35" (2)
D19	6065	1	1	6065 R EX	14"X35"	2X10X17" (2)

WINDOW SCHEDULE						
NUMBER	LABEL	QTY	FLOOR	SIZE	R/O	EGRESS
W01	2020	1	2	2020	25"X25"	2X6X25" (2)
W02	2020	1	5	2020	25"X25"	2X6X25" (2)
W03	3040RS	1	1	3040RS	31"X44"	YES 2X6X40" (2)
W04	2020PK	4	2	2020PK	25"X25"	2X6X25" (2)
W05	2030RS	1	1	2030RS	25"X31"	YES 2X6X25" (2)
W07	3040DH	2	1	3040DH	31"X44"	2X6X40" (2)
W09	5020TS	1	1	5020TS	61"X25"	YES 2X6X41" (2)
W09	2430RS	2	1	2430RS	24"X31"	YES 2X6X32" (2)
W10	4020PK	3	2	4020PK	44"X25"	2X6X32" (2)
W11	4020PK	1	2	4020PK	44"X25"	2X6X41" (2)
W12	4040DH	1	2	4040DH	44"X44"	YES 2X6X52" (2)
W14	3050DH	2	1	3050DH	31"X61"	YES 2X6X40" (2)
W15	3050DH	2	2	3050DH	31"X61"	YES 2X6X40" (2)



2 nd Floor Plan View Dimensioned
1/4"=1'-0"

REVISION TABLE		REVISION BY		DESCRIPTION	
NUMBER	DATE				


2 nd Floor Plan View
Dimensioned

DRAWINGS PROVIDED BY:
BC


DATE:
10/4/2025

SCALE:

SHEET:
P-3

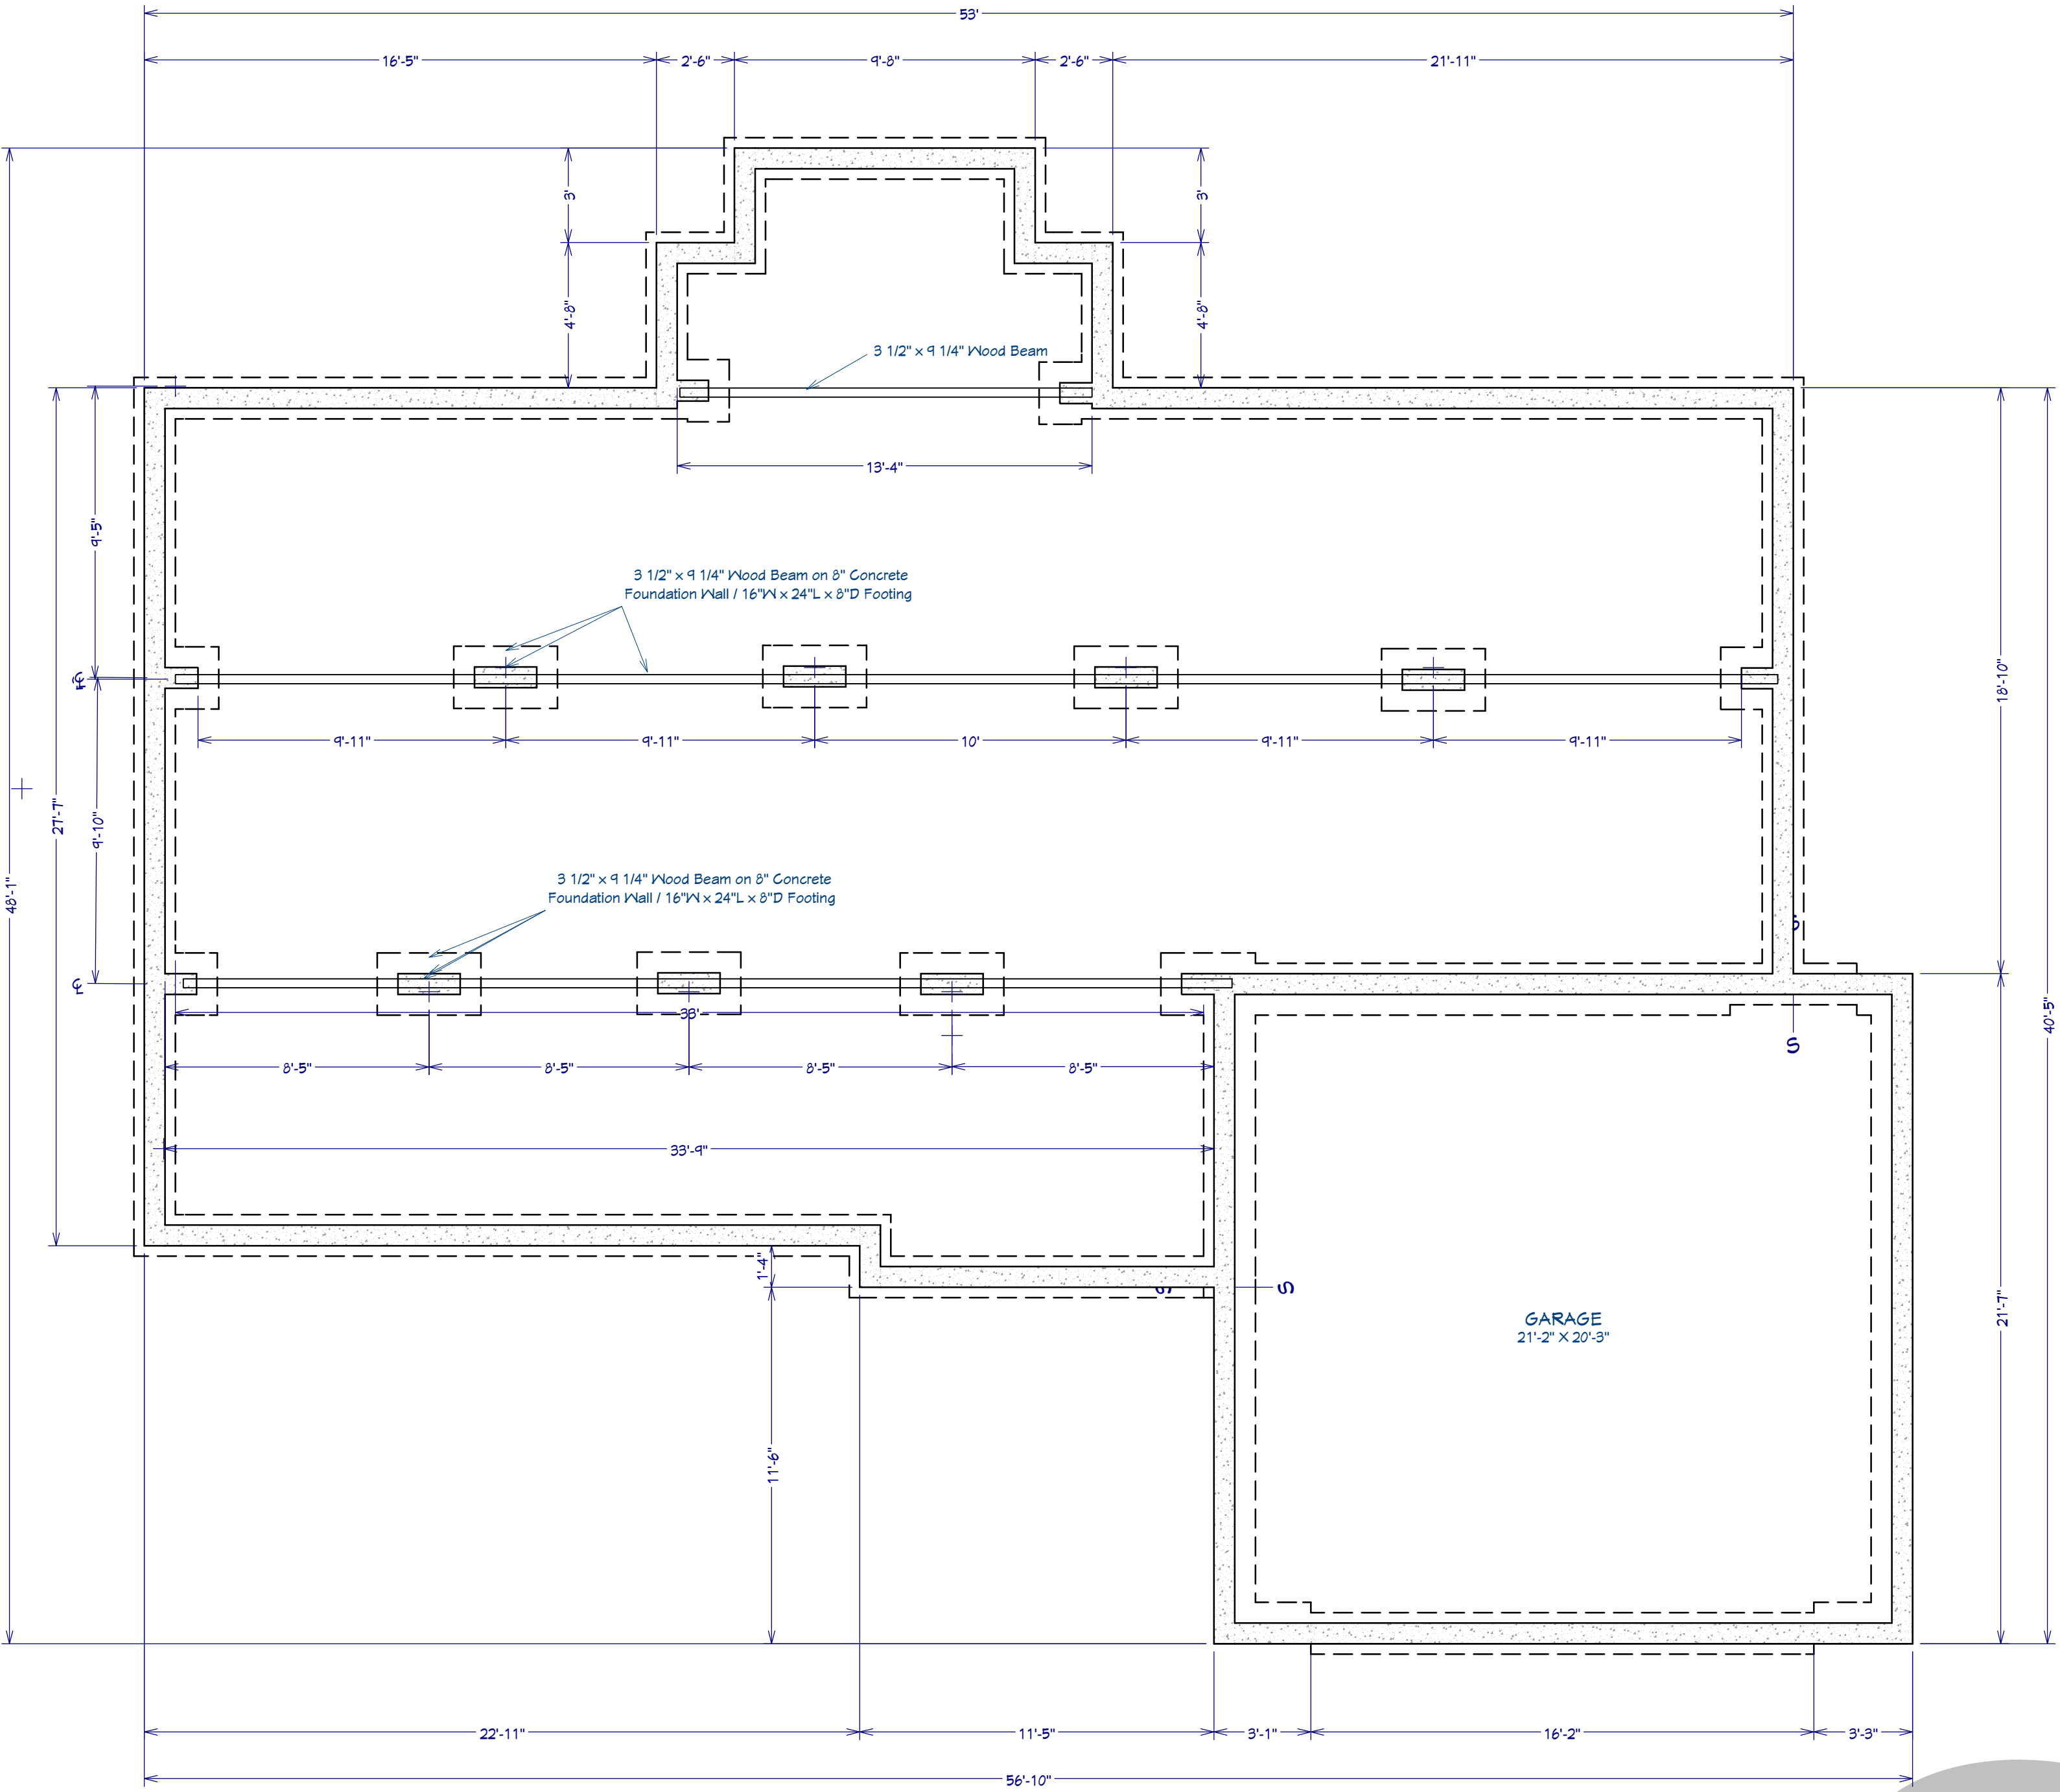


Foundation Plan View Dimensioned
1/4"=1'-0"

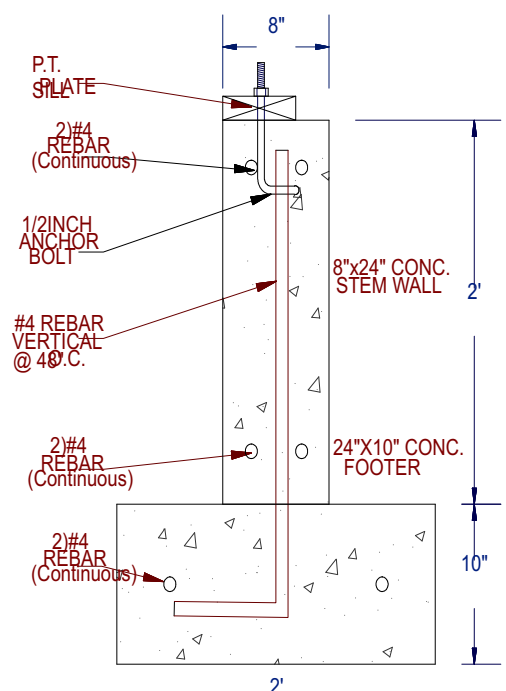


Typical Application around
Perimeter Stem Walls

NOTE:
ALL REBAR PER LOCAL CODE
AND/OR ENGINEER'S DESIGN

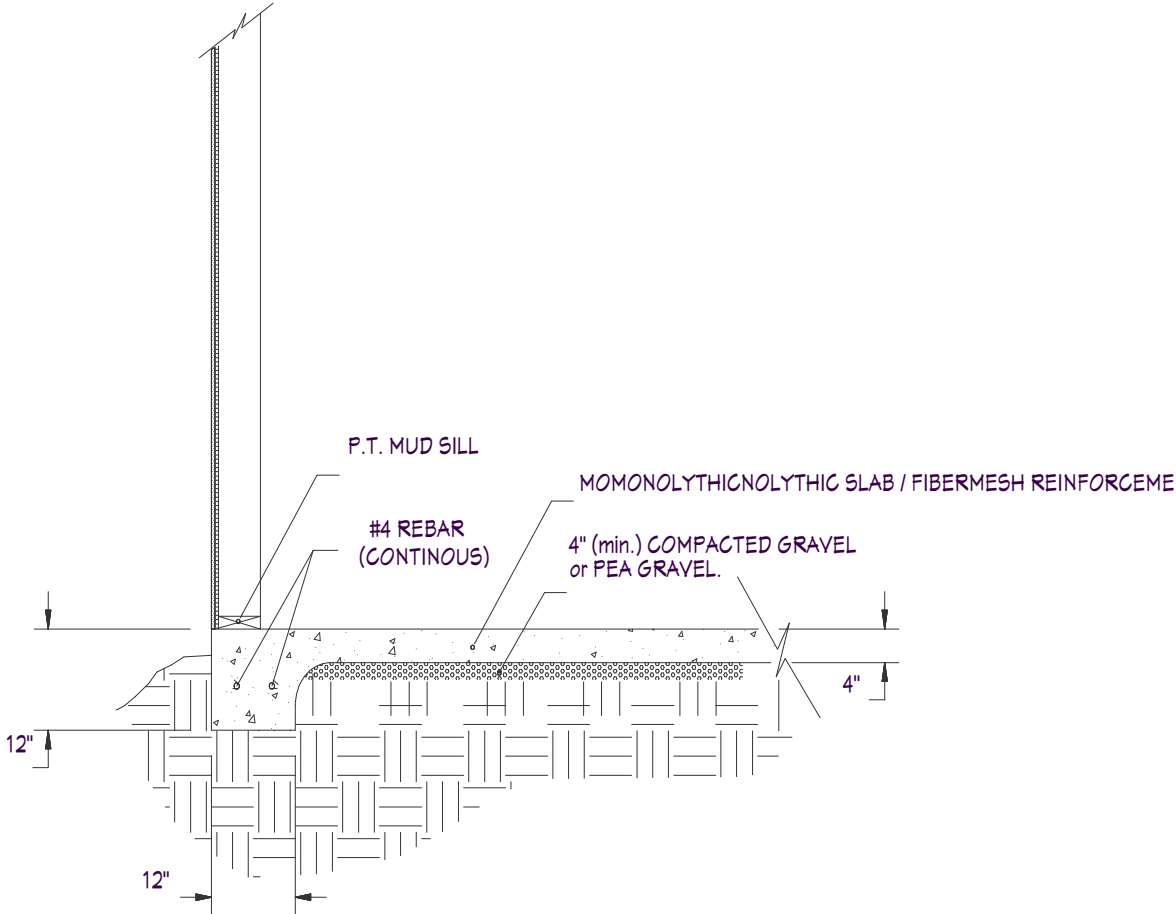

Garage Floor
Section

NOTE:
ALL REBAR PER LOCAL CODE
AND/OR ENGINEER'S DESIGN

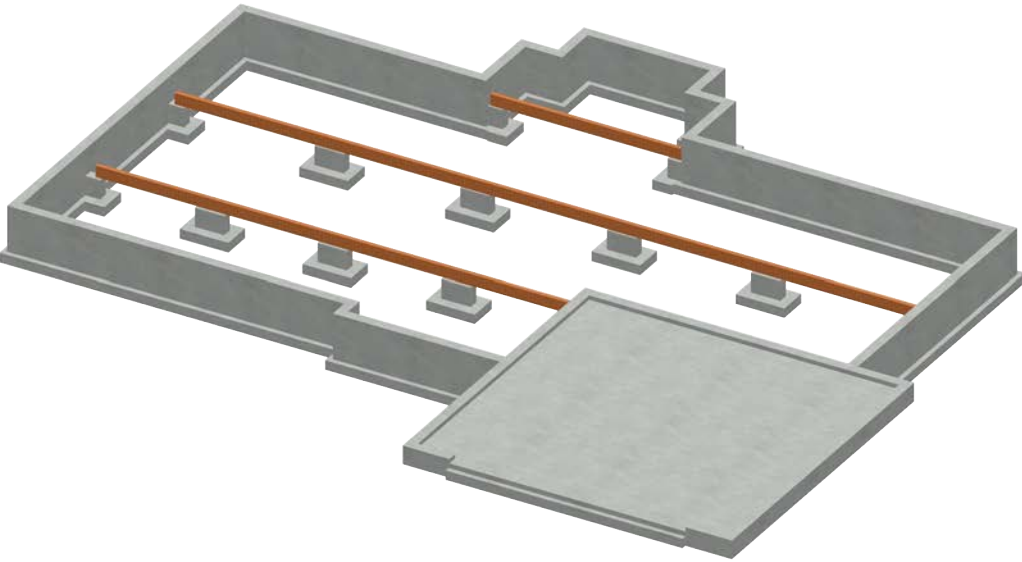

REVISION TABLE		REVISION BY	DESCRIPTION
NUMBER	DATE		


Foundation Plan View
Dimensioned

DRAWINGS PROVIDED BY:
BC

DATE:
10/4/2025


SCALE:

SHEET:
P--4

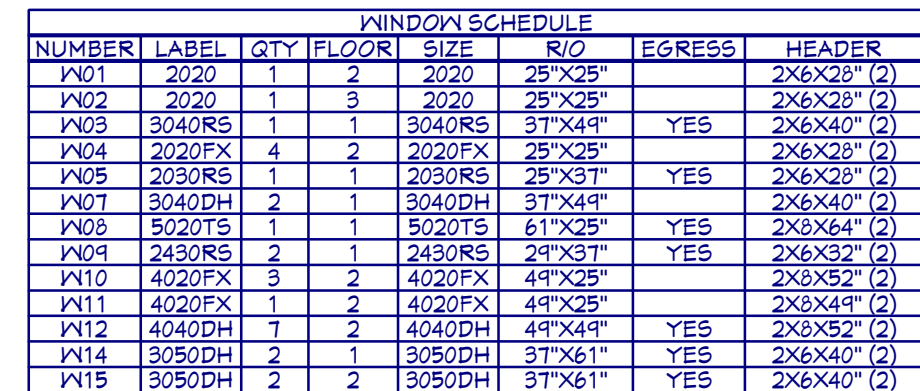

Exterior Elevation Back
1/4"=1'-0"

0.5

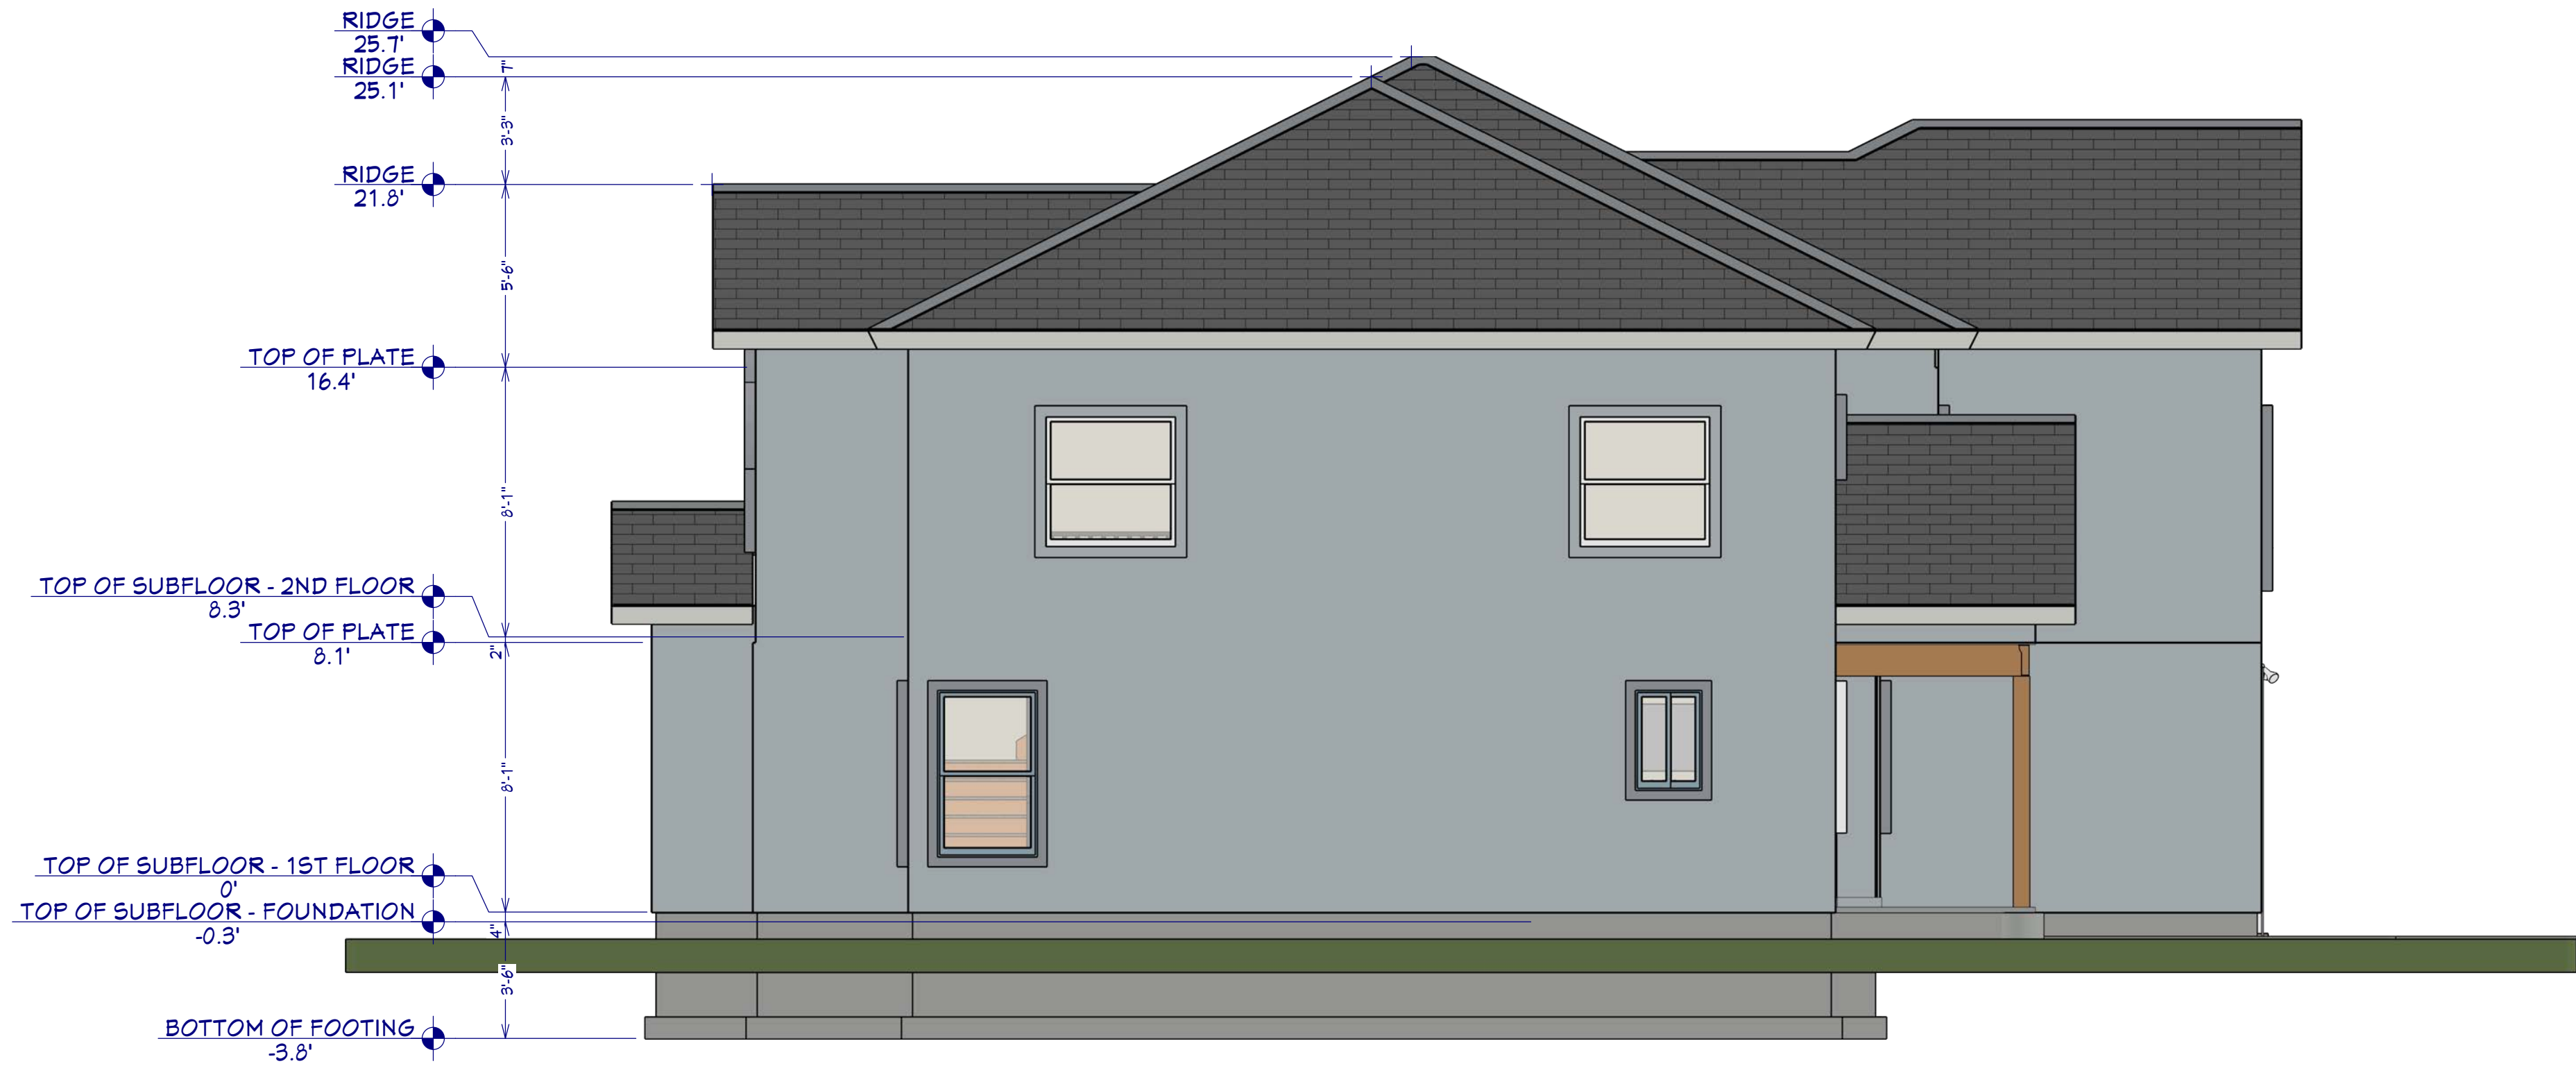

Exterior Elevation Left
1/4"=1'-0"

DOOR SCHEDULE						
NUMBER	LABEL	QTY	FLOOR	SIZE	R/O	HEADER
D01	1068	1	1	1068 R	25' 1/4"X52' 1/2"	2X6X25' 1/4" (2)
D02	1265	2	1	1265	16'X53"	2X6X16" (2)
D03	1465	1	2	1465 R EX	18' 1/2"X53"	4X5' 1/2"X21' 1/2" (2)
D04	16080	1	1	16080	144"X94"	2X12X200" (2)
D05	1365	1	1	1365 R IN	122"X52' 1/2"	2X6X25" (2)
D06	2065	2	1	2065 R IN	26"X52' 1/2"	2X6X24" (2)
D07	2265	1	1	2265 R	26"X50"	
D08	2665	1	1	2665 L	32"X52' 1/2"	2X6X35" (2)
D09	2665	1	1	2665 L EX	32"X55"	4X5' 1/2"X35" (2)
D10	2665	3	1	2665 L IN	32"X52' 1/2"	2X6X35" (2)
D11	2665	1	1	2665 R	31' 4 1/8"X52' 1/2"	2X6X34' 4 1/8" (2)
D12	2665	2	1	2665 R IN	32"X52' 1/2"	2X6X35" (2)
D13	2665	1	2	2665 L	32"X52' 1/2"	2X6X35" (2)
D14	2665	2	2	2665 L IN	32"X52' 1/2"	2X6X35" (2)
D15	2465	1	2	2465 L IN	50"X52' 1/2"	2X6X35" (2)
D16	2665	3	2	2665 R IN	32"X52' 1/2"	2X6X35" (2)
D17	3065	1	1	3065 R IN	35"X52' 1/2"	2X6X41" (2)
D18	5065	2	2	5065 L/R	62"X52' 1/2"	2X6X59" (2)
D19	6065	1	1	6065 R EX	14'X55"	2X10X11" (2)

WINDOW SCHEDULE						
NUMBER	LABEL	QTY	FLOOR	SIZE	R/O	EGRESS
W01	2020	1	2	2020	25'X25"	
W02	2020	1	3	2020	25'X25"	
W03	3040RS	1	1	3040RS	37"X44"	YES
W04	2020FX	4	2	2020FX	25'X25"	
W05	2030RS	1	1	2030RS	25'X31"	YES
W07	3040DH	2	1	3040DH	37"X44"	
W08	5020TS	1	1	5020TS	61"X25"	YES
W09	2430RS	2	1	2430RS	24"X31"	YES
W10	4020FX	3	2	4020FX	44"X25"	
W11	4020FX	1	2	4020FX	44"X25"	
W12	4040DH	1	2	4040DH	48"X44"	YES
W14	3050DH	2	1	3050DH	37"X61"	YES
W15	3050DH	2	2	3050DH	37"X61"	YES



Exterior Elevation Right
1/4"=1'-0"

REVISION TABLE		REVISION BY		DESCRIPTION	
NUMBER	DATE				


Exterior Elevations

DRAWINGS PROVIDED BY:
BC

DATE:
10/4/2025

SCALE:

SHEET:
P-6

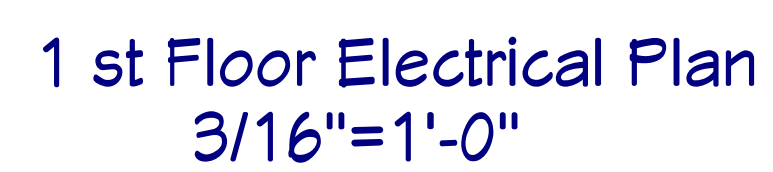

IN ELECTRICAL SECTION				
SYMBOL	QTY	UNIT	DESCRIPTION	NO.
	30	1	DUPLEX	
	2	1	BPM	
	1	1	DOUBLE LIGHT CEILING FAN	
	2	1	220V-240V MODERN FAN	
	2	1	240V-240V MODERN FAN	
	2	1	1/4 IN BLUE PAINTION LIGHTED MEDICINE CABINET	
	2	1	LYNN RECESSED TUBE LIGHT (PANO)	
	1	2	MEDIUM DOUBLE SURFACE HOUNTED TUBE LIGHT (PANO)	
	13	1	RECESSED DOWN LIGHT	
	14	1	SINGLE POLE SWITCH	
	1	1	SPOTLIGHT 2 MOTOR SENSOR	
	41	2	DUPLEX	
	1	2	DOUBLE LIGHT CEILING FAN	
	1	2	MEDIUM DOUBLE SURFACE HOUNTED TUBE LIGHT (PANO)	
	1	2	RECESSED DOWN LIGHT	
	1	2	SINGLE POLE SWITCH	
	1	1	SPOT LIGHT	

[illegible]

Electrical Plans

BC

DRAWINGS PROVIDED BY:

DATE:
10/4/2025

SCALE:

SHEET:
P-7



Master Game Room View




Master Bedroom View



Kitchen View



Garage View

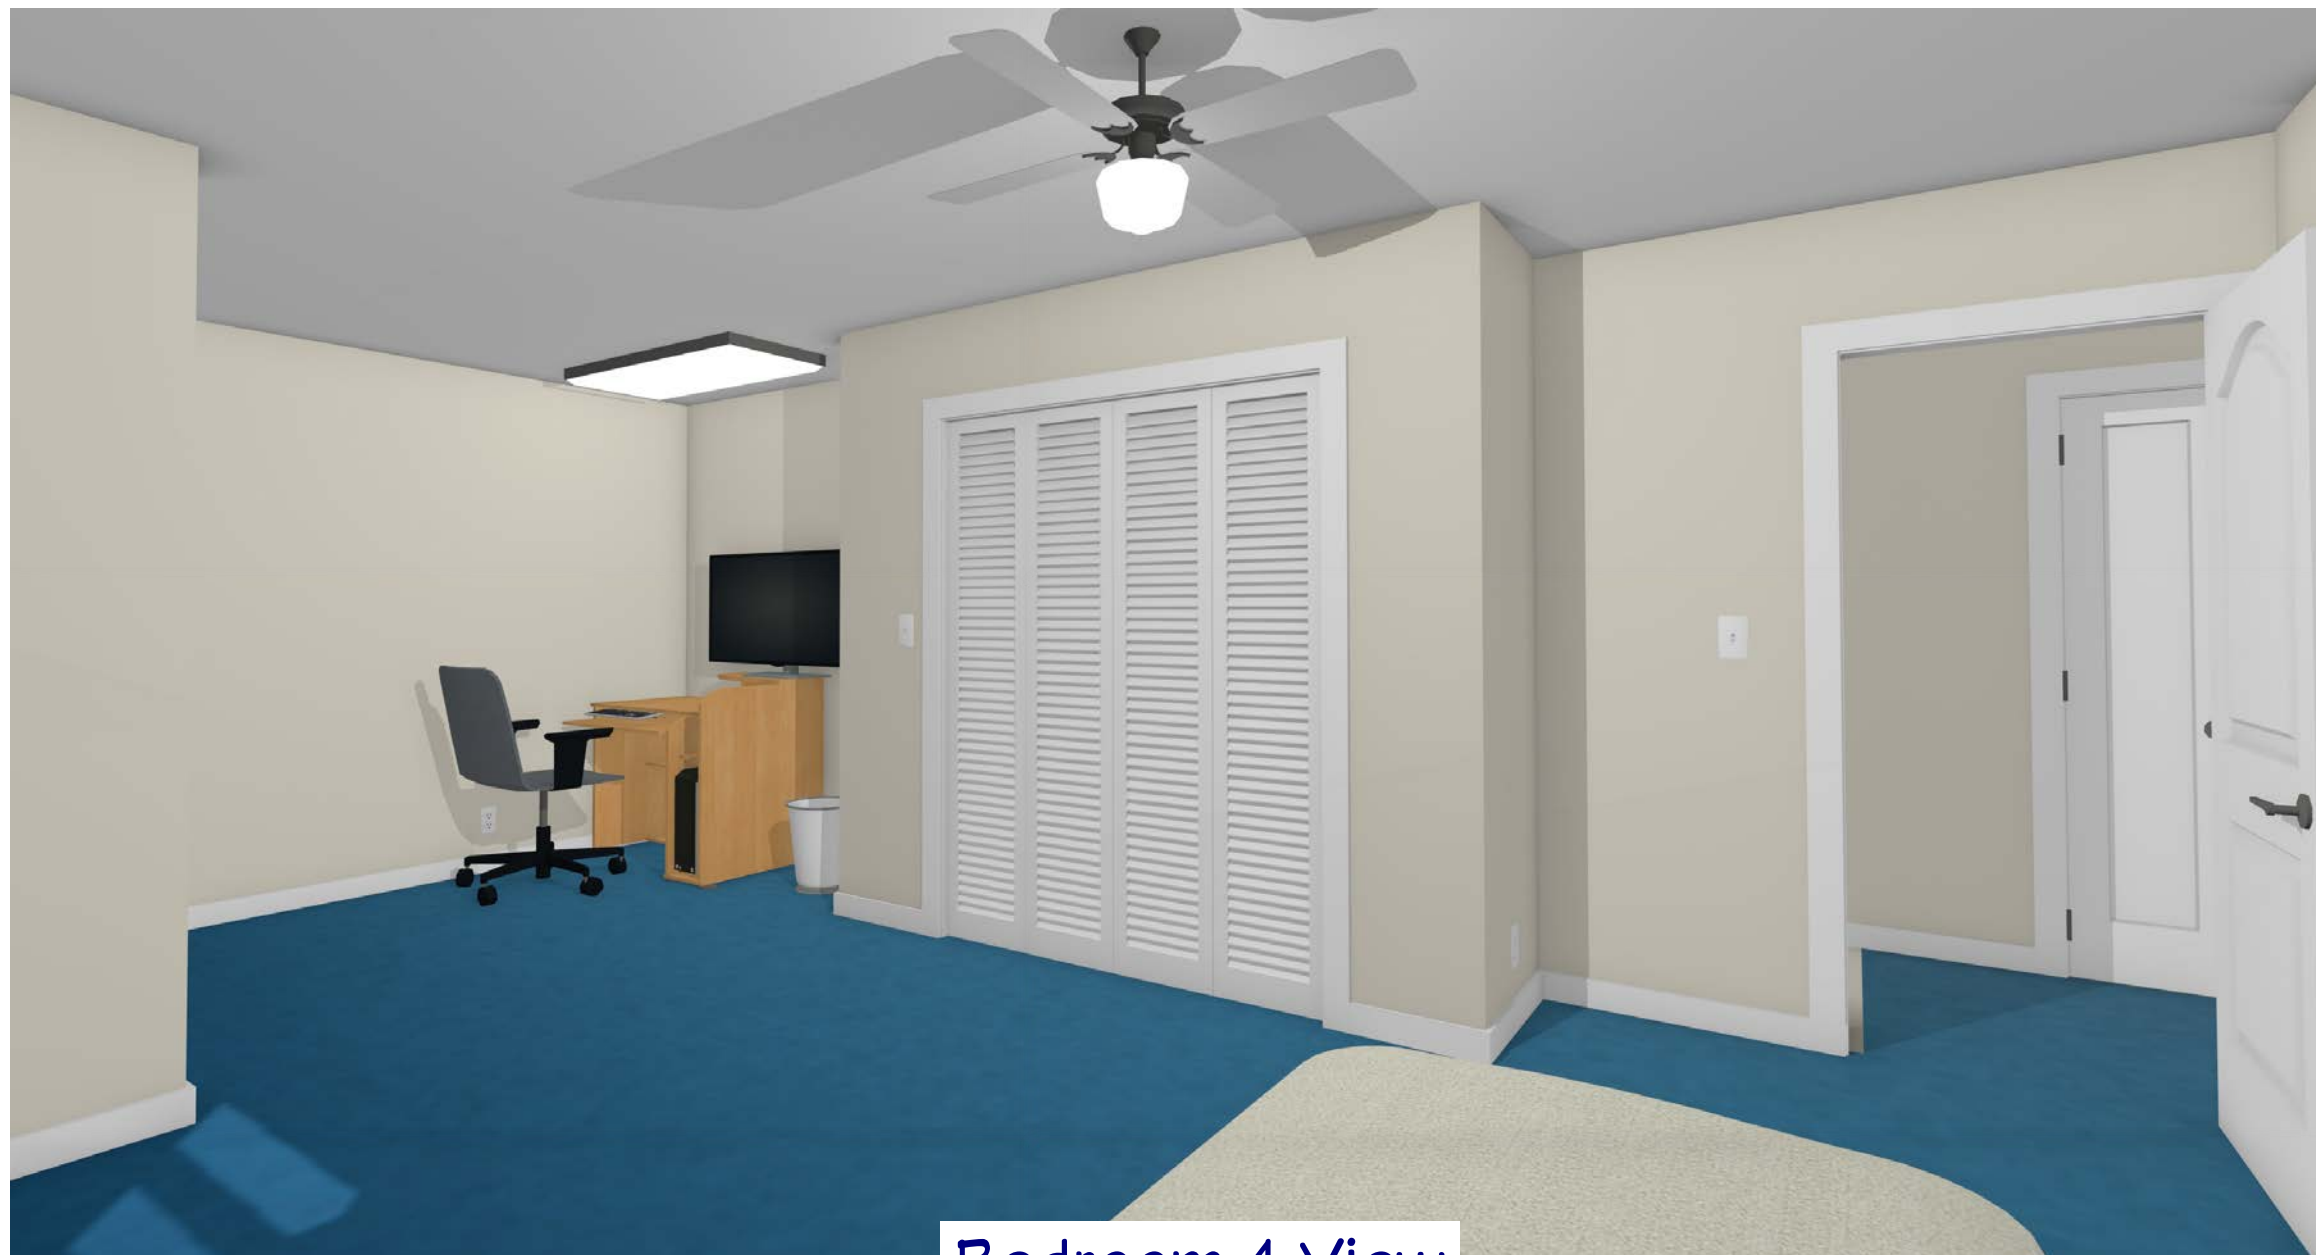

Bedroom 4 View



Hall Looking into Bedroom 2 & 3

REVISION TABLE		DESCRIPTION
NUMBER	DATE	REVISION

Interior Views NTS

DRAWINGS PROVIDED BY:
BC

DATE:
10/4/2025

SCALE:

SHEET:
P-8