



iso golden

REVISION TABLE		REVISION BY	DESCRIPTION
NUMBER	DATE		


Project Overview

DRAWINGS PROVIDED BY:
BC

DATE:
7/15/2026


SCALE:
as shown

SHEET:
P-1

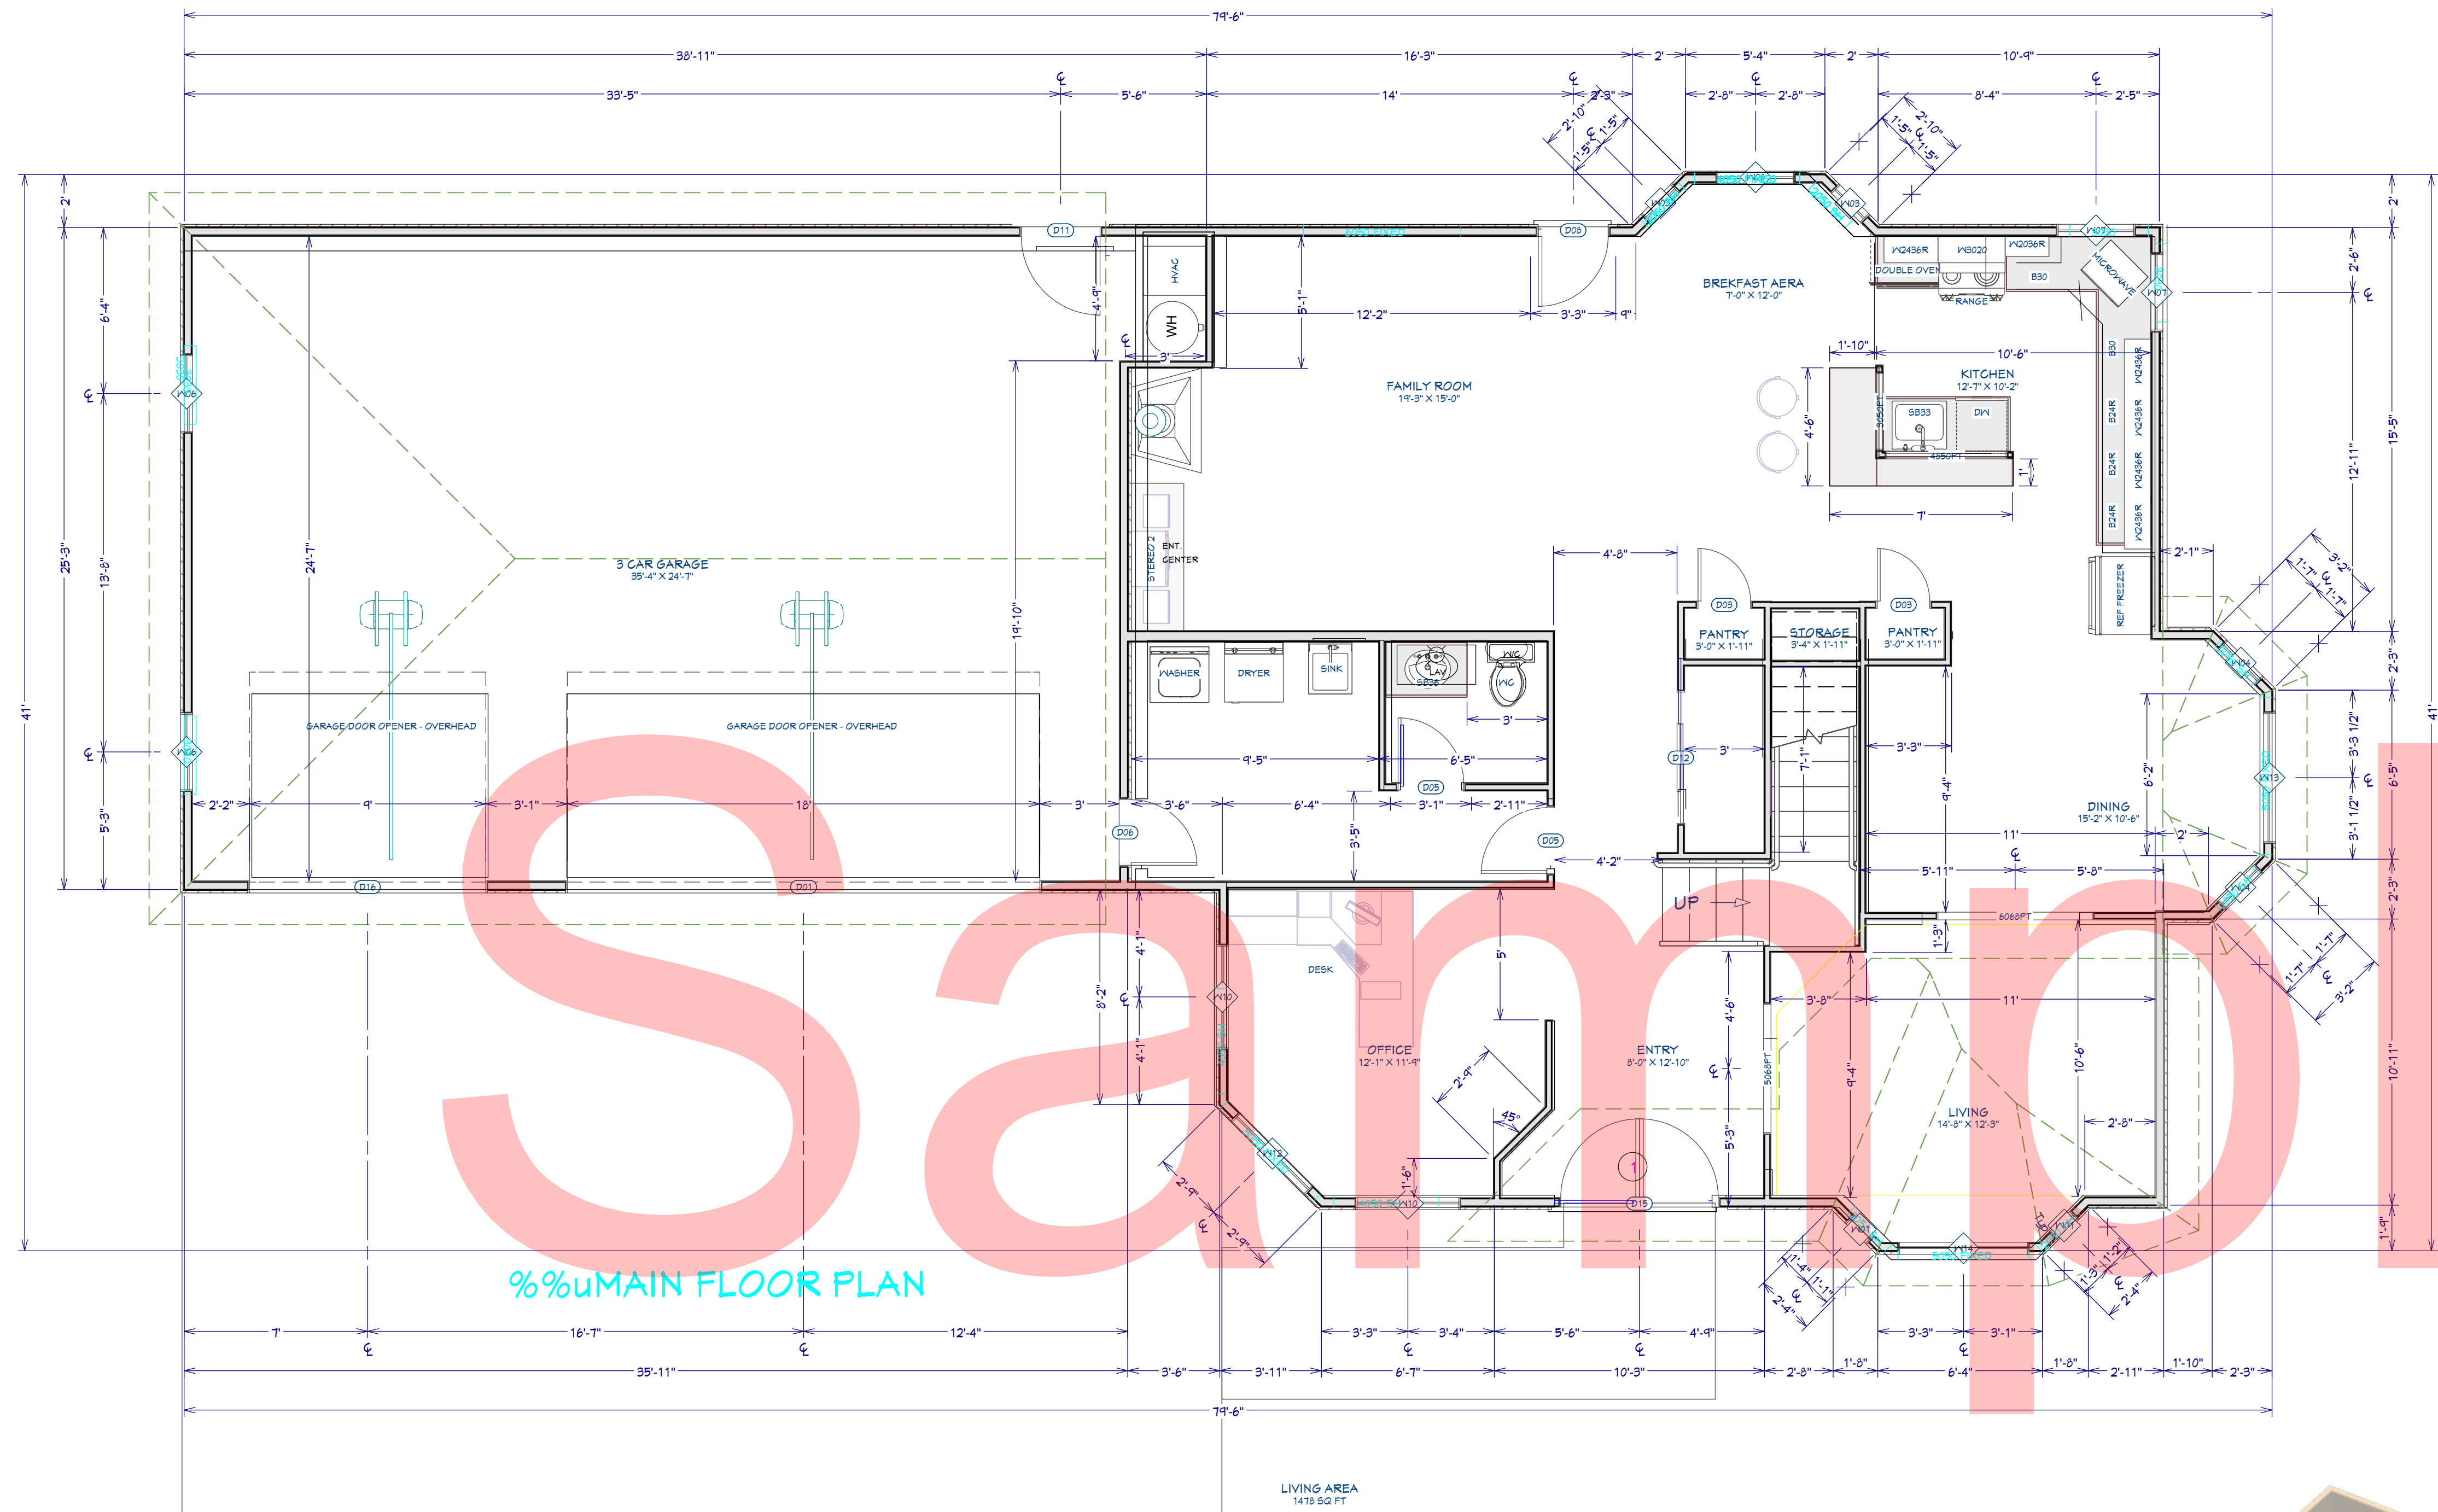

%%MAIN FLOOR PLAN

Main Floor Plan
Scale: 1/4" = 1'-0"

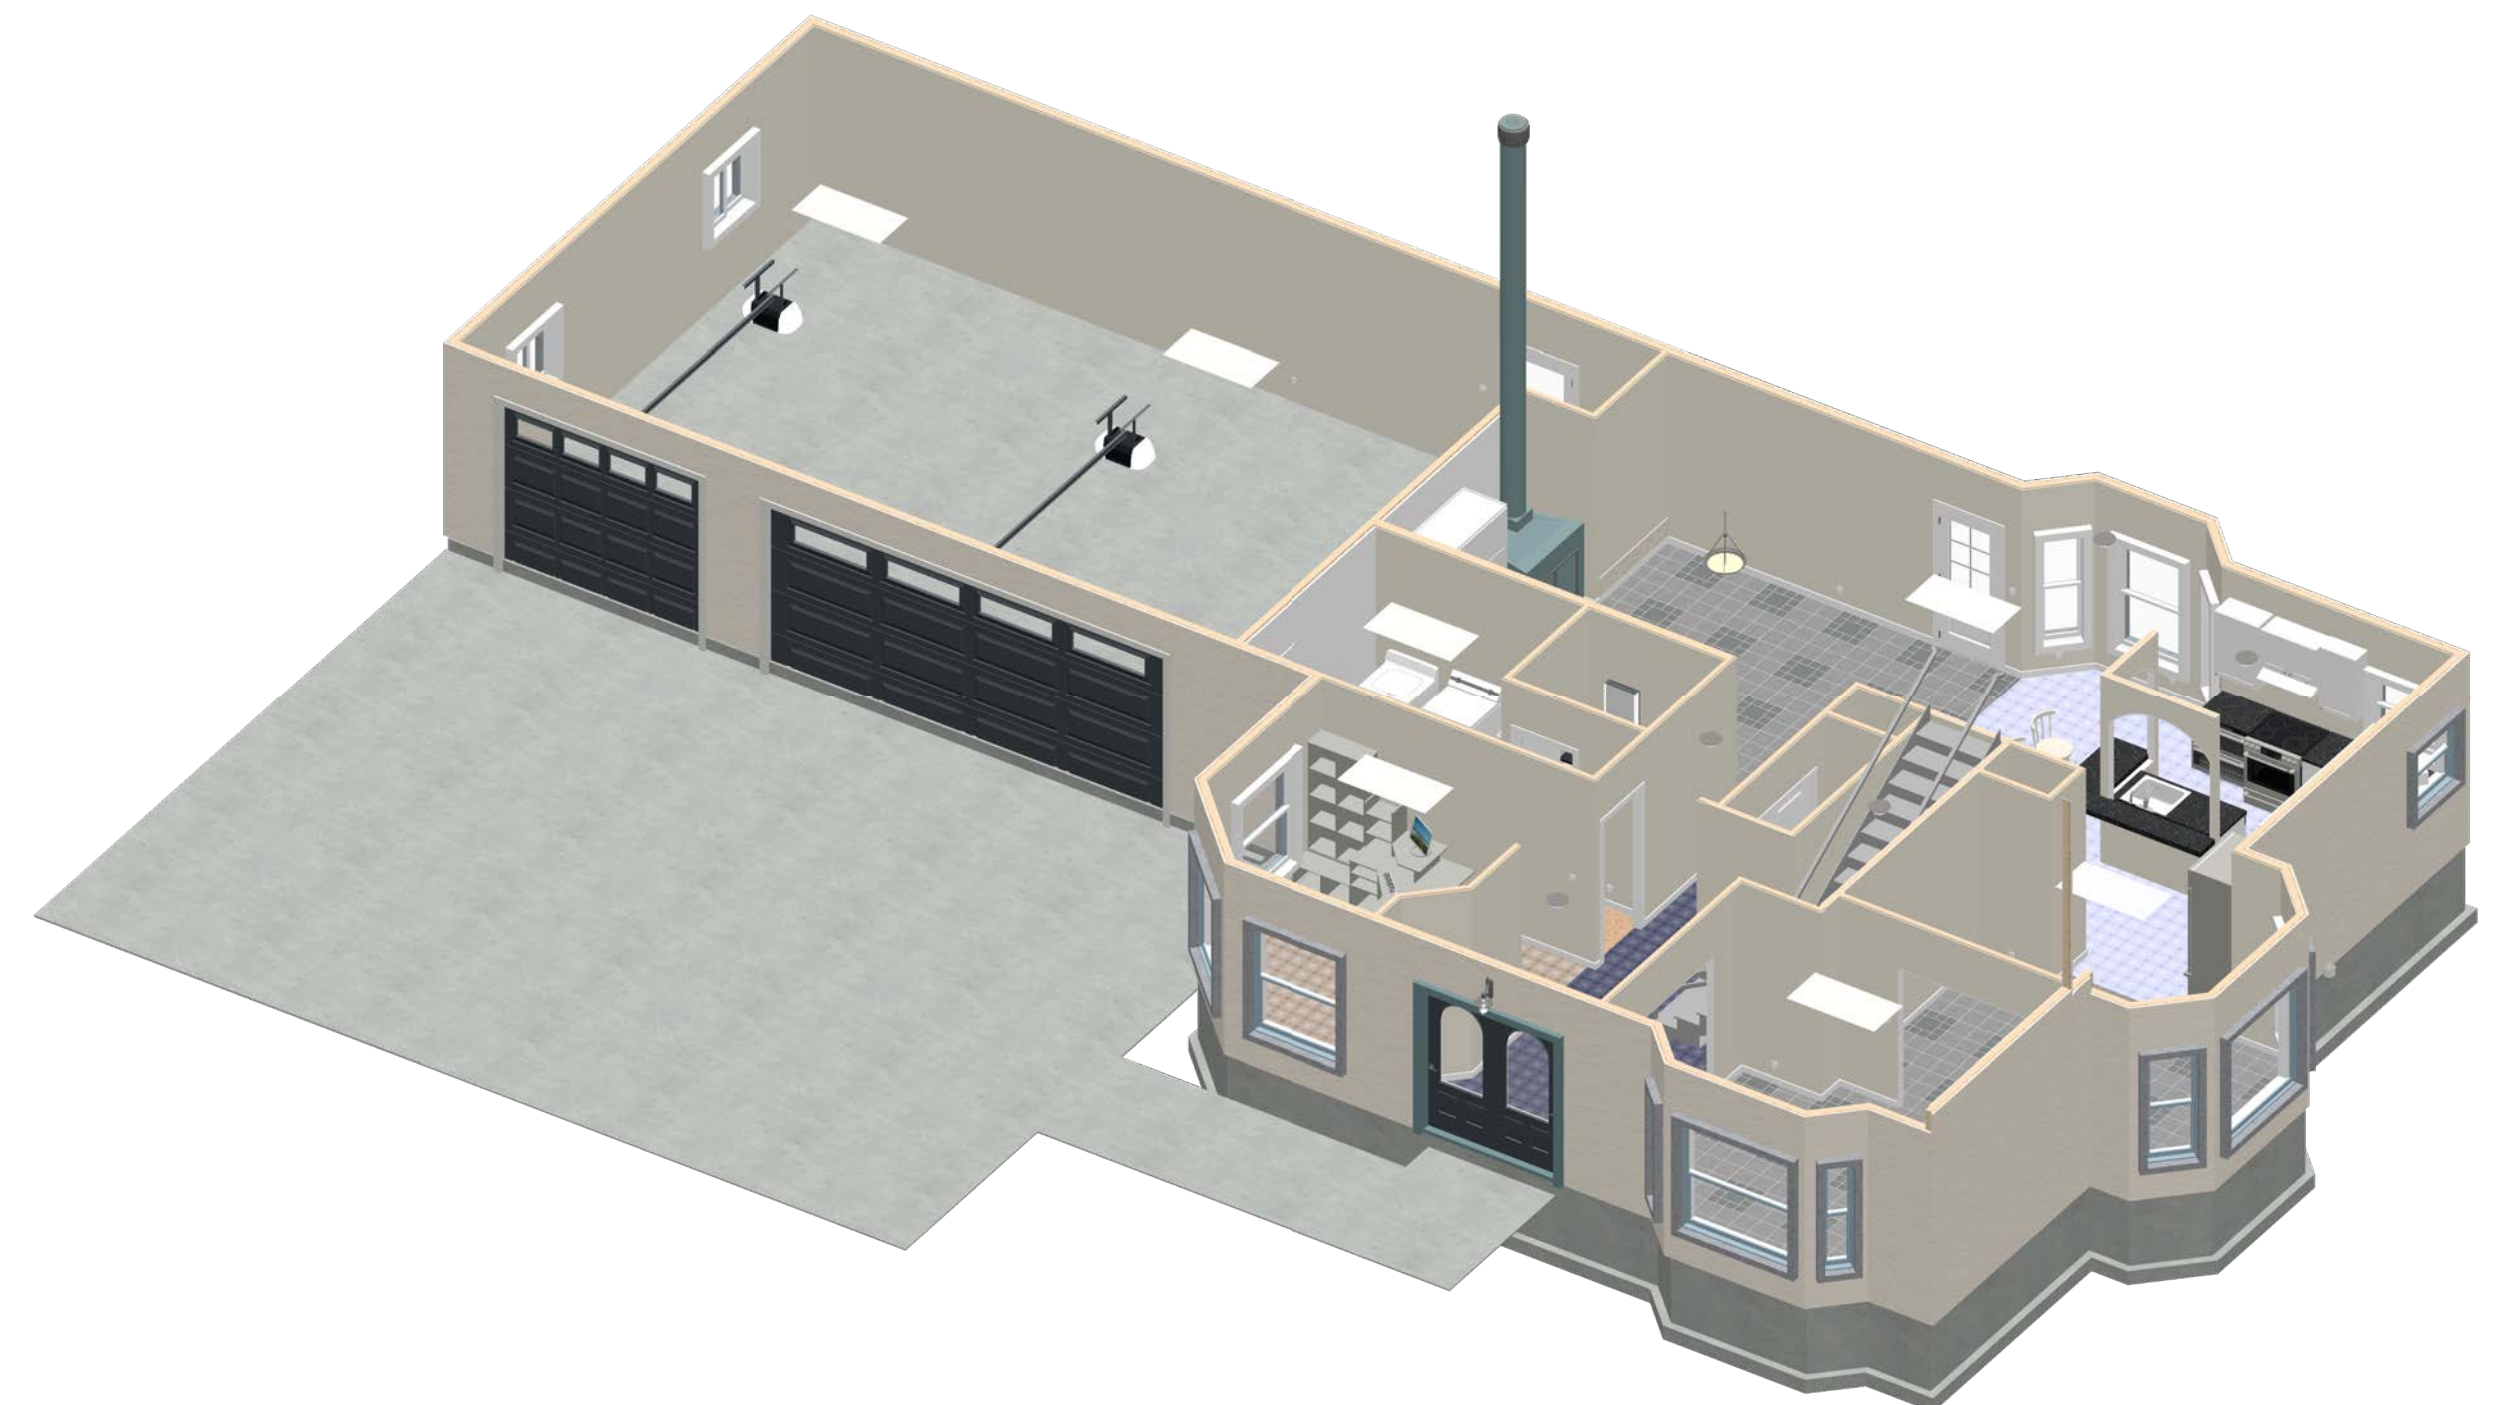

DOOR SCHEDULE									
NUMBER	LABEL	QTY	FLOOR	SIZE	R/O	DESCRIPTION	HEADER	FIRE	
D01	13000	1	1	13000	210"X44"	GARAGE-ERP STYLELINE II T	2"X12"X24" (2)		
D02	1860	1	2	1860	R IN	22"X32 1/2"	HINGED-PANEL	2"X6"X35" (2)	
D03	2060	2	1	2060	L IN	26"X32 1/2"	HINGED-PANEL	2"X6"X34" (2)	
D04	2460	1	2	2460	L IN	32"X32 1/2"	HINGED-PANEL	2"X6"X35" (2)	
D05	2660	2	1	2660	L IN	32"X32 1/2"	HINGED-PANEL	2"X6"X35" (2)	
D06	2660	1	1	2660	R IN	32"X32 1/2"	HINGED-PANEL	2"X6"X35" (2)	
D07	2660	1	2	2660	R IN	32"X32 1/2"	HINGED-PANEL	2"X6"X35" (2)	
D08	2660	1	1	2660	R EX	34"X32"	EXT. HINGED-DOOR E02	4"X8 1/2"X31" (2)	
D09	2660	1	2	2660	L IN	34"X32 1/2"	HINGED-PANEL	2"X6"X31" (2)	
D10	2660	1	2	2660	R IN	34"X32 1/2"	HINGED-PANEL	2"X6"X31" (2)	
D11	5060	1	1	5060	L EX	30"X60"	EXT. HINGED-DOOR E01	4"X8 1/2"X41" (2)	
D12	5060	1	1	5060	R IN	62"X32 1/2"	SLIDER-DOOR F04	2"X6"X65" (2)	
D13	5060	2	2	5060	C-R IN	62"X32 1/2"	DOUBLE HINGED-PANEL	2"X6"X65" (2)	
D14	5060	2	2	5060	L IN	62"X32 1/2"	SLIDER-DOOR F01	2"X6"X65" (2)	
D15	6060	1	1	6060	C-LUR EX	14"X30"	EXT. DOUBLE HINGED-DOOR E11	4"X8 1/4"X11" (2)	
D16	9060	1	1	9060		110"X94"	GARAGE-ERP STYLELINE II T	2"X12"X116" (2)	

WINDOWS SCHEDULE									
NUMBER	LABEL	QTY	FLOOR	SIZE	R/O	EGRESS	DESCRIPTION	HEADER	
W01	1250DH	2	1	1250DH	19"X61"		DOUBLE HUNG	2"X6"X19" (2)	
W02	1350RS	4	2	1350RS	21"X61"		RIGHT SLIDING	2"X6"X24" (2)	
W03	1350SH	2	1	1350SH	21"X61"		SINGLE HUNG	2"X6"X24" (2)	
W04	2050SH	2	1	2050SH	26"X61"	YES	SINGLE HUNG	2"X6"X26" (2)	
W05	3030FX	1	2	3030FX	31"X31"		FIXED GLASS	2"X6"X40" (2)	
W06	3030RS	2	1	3030RS	31"X31"		RIGHT SLIDING	2"X6"X40" (2)	
W07	3030SH	2	1	3030SH	31"X31"		SINGLE HUNG	2"X6"X40" (2)	
W08	3050SH	1	1	3050SH	31"X61"	YES	SINGLE HUNG	2"X6"X40" (2)	
W09	4050SH	1	2	4050SH	44"X61"		SINGLE HUNG	2"X6"X52" (2)	
W10	4050SH	5	2	4050SH	44"X61"	YES	SINGLE HUNG	2"X6"X52" (2)	
W11	4050SH	1	1	4050SH	44"X61"	YES	SINGLE HUNG	2"X6"X52" (2)	
W12	4050FX	1	1	4050FX	44"X61"	YES	FIXED GLASS	2"X6"X52" (2)	
W13	5050FX	1	1	5050FX	61"X61"		FIXED GLASS	2"X6"X64" (2)	
W14	5050SH	1	1	5050SH	61"X61"	YES	SINGLE HUNG	2"X6"X64" (2)	
W15	4040SH	2	2	4040SH	44"X44"	YES	SINGLE HUNG	2"X6"X52" (2)	

REVISION TABLE		DESCRIPTION
NUMBER	DATE	


Main Floor Plan

DRAWINGS PROVIDED BY:
BC

DATE:
7/15/2026

SCALE:
as shown


SHEET:
P-2

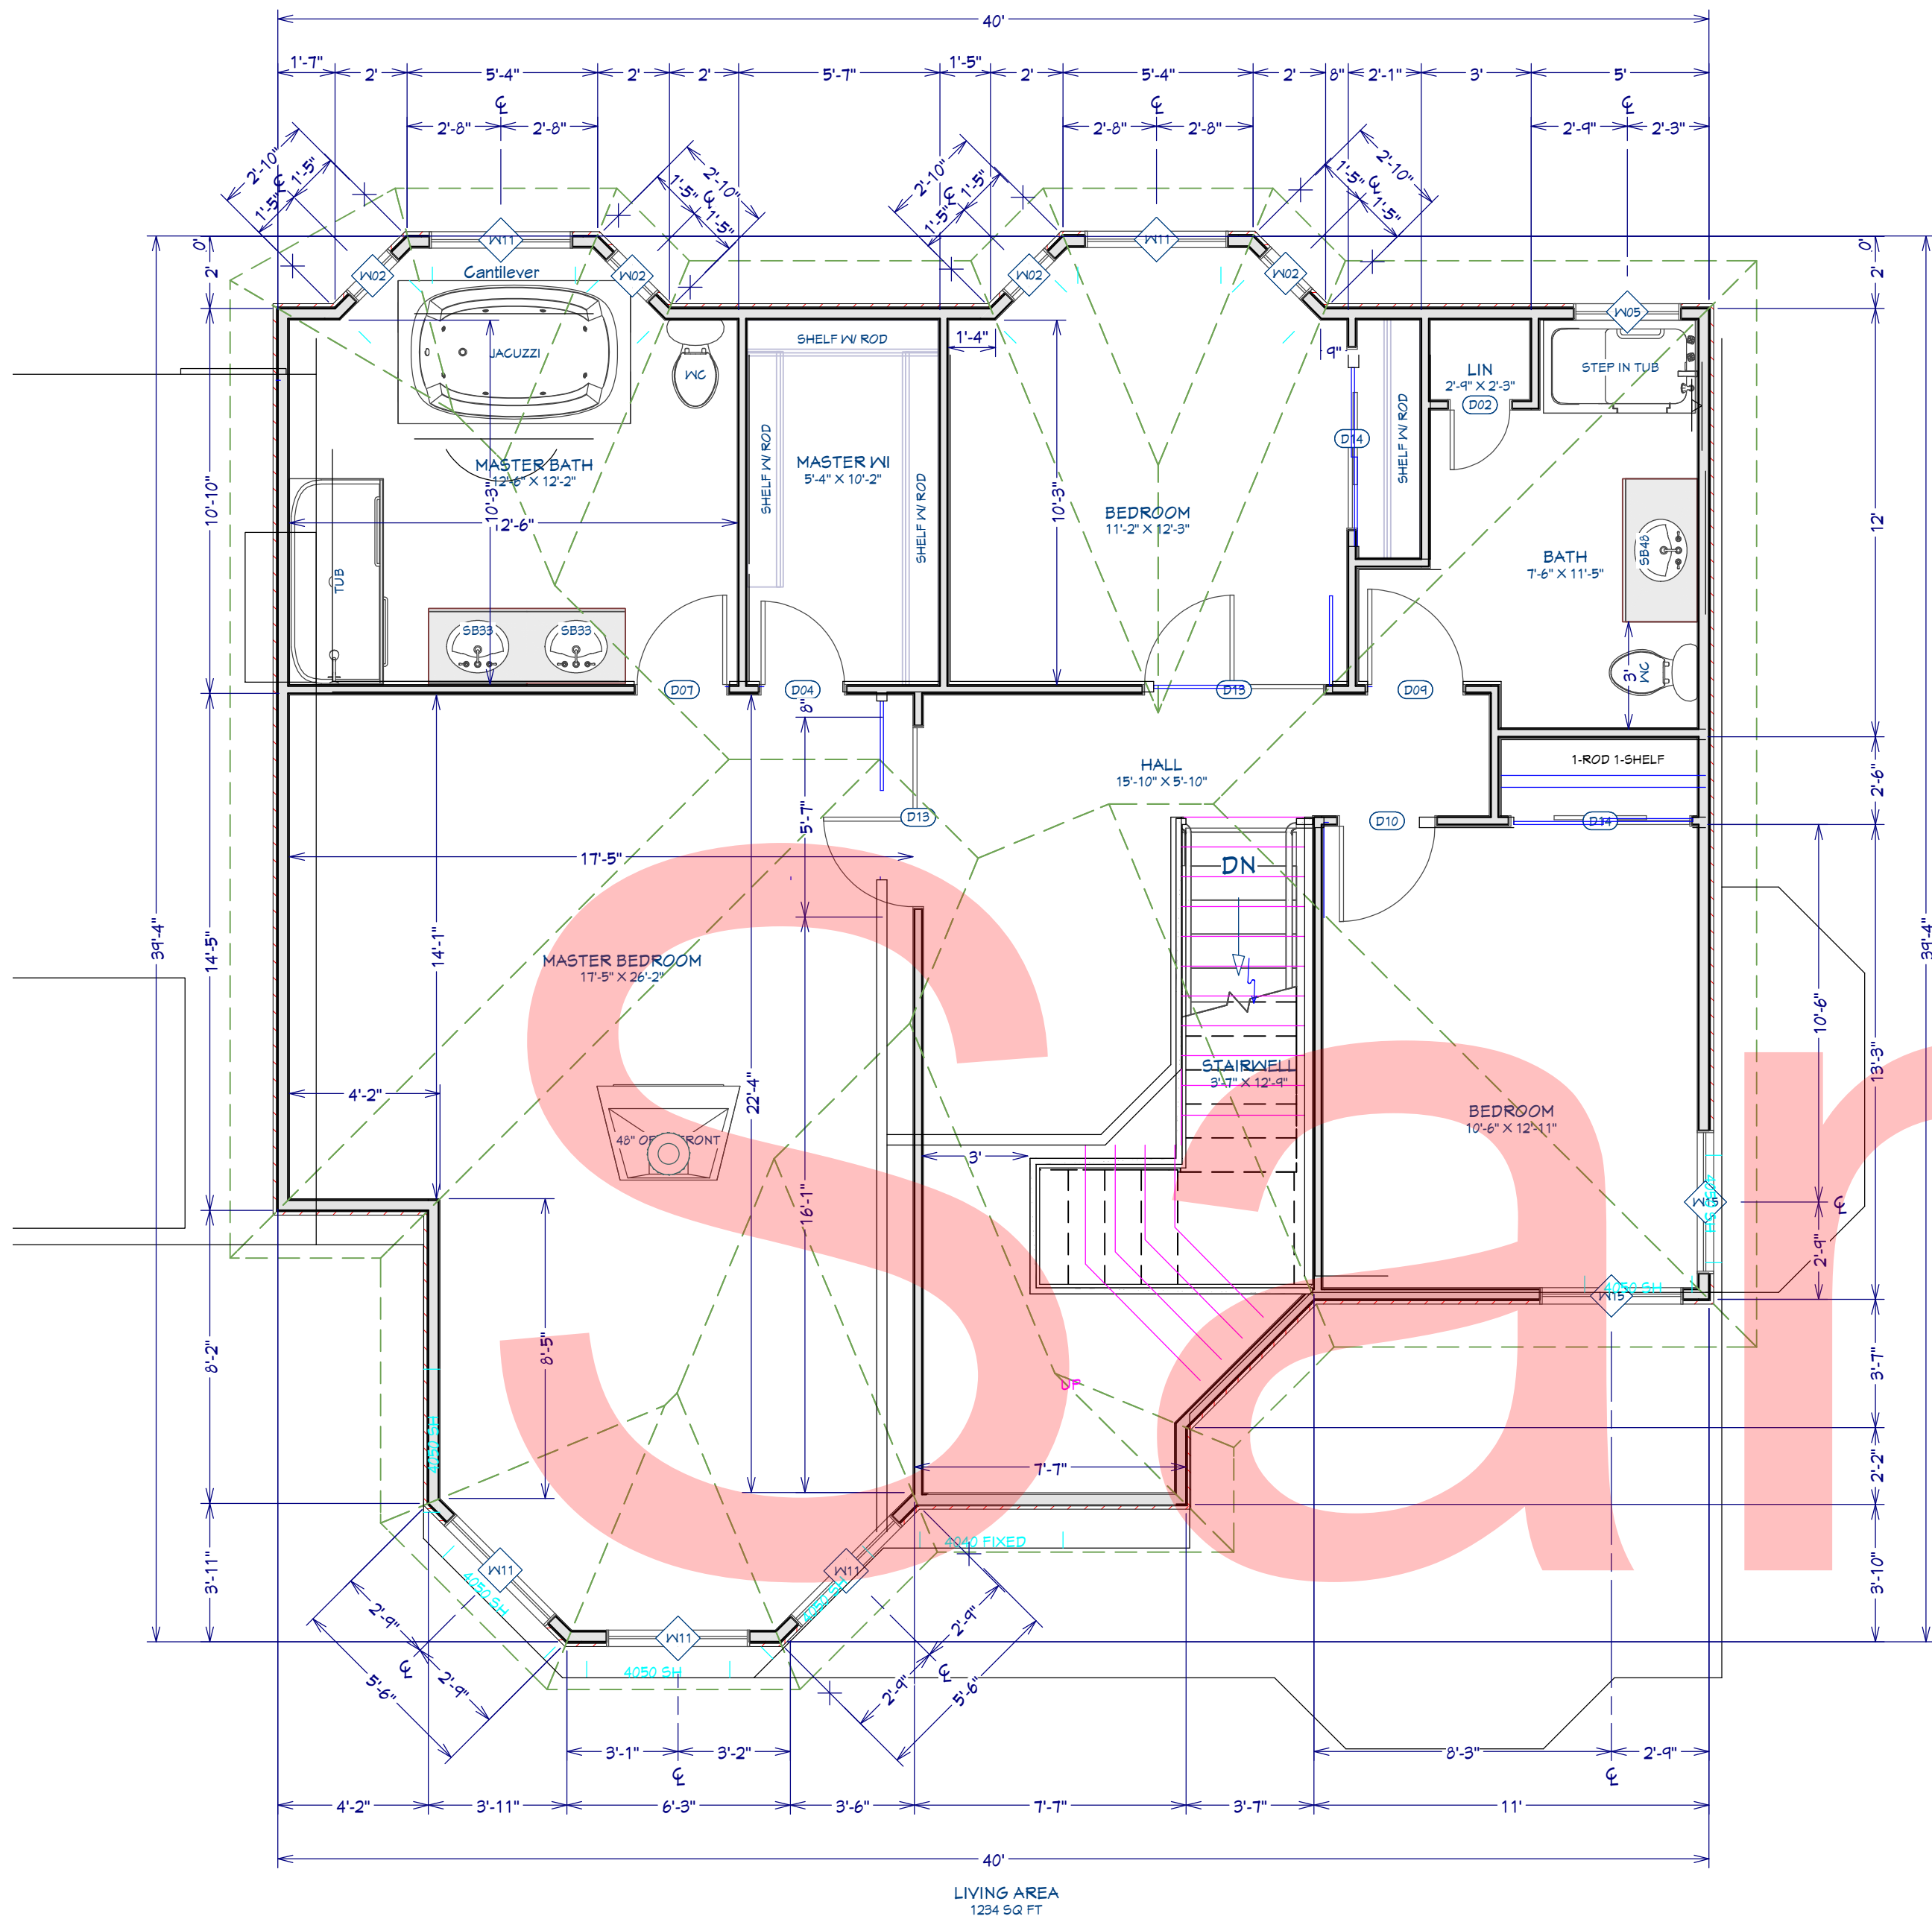

Second Floor Plan
Scale: 1/4" = 1'-0"

DOOR SCHEDULE						
NUMBER	LABEL	QTY	FLOOR	SIZE	R/O	DESCRIPTION
D01	13000	1	1	13000	210"X44"	GARAGE-ERP STYLELINE II T
D02	1860	1	2	1860 R IN	22"X62 1/2"	HINGED-PANEL
D03	2060	2	1	2060 L IN	26"X62 1/2"	HINGED-PANEL
D04	2460	1	2	2460 L IN	32"X62 1/2"	HINGED-PANEL
D05	2660	2	1	2660 L IN	32"X62 1/2"	HINGED-PANEL
D06	2660	1	1	2660 R IN	32"X62 1/2"	HINGED-PANEL
D07	2660	1	2	2660 R IN	32"X62 1/2"	HINGED-PANEL
D08	2660	1	1	2660 R EX	34"X62"	EXT. HINGED-DOOR E02
D09	2660	1	2	2660 L IN	34"X62 1/2"	HINGED-PANEL
D10	2660	1	2	2660 R IN	34"X62 1/2"	HINGED-PANEL
D11	5060	1	1	5060 L EX	60"X62"	EXT. HINGED-DOOR E01
D12	5060	1	1	5060 R IN	62"X62 1/2"	SLIDER-DOOR F04
D13	5060	2	2	5060 C-R IN	62"X62 1/2"	DOUBLE HINGED-PANEL
D14	5060	2	2	5060 L IN	62"X62 1/2"	SLIDER-DOOR F01
D15	6060	1	1	6060 C-LUR EX	14"X63"	EXT. DOUBLE HINGED-DOOR E11
D16	9060	1	1	9060	110"X94"	GARAGE-ERP STYLELINE II T

WINDOW SCHEDULE						
NUMBER	LABEL	QTY	FLOOR	SIZE	R/O	DEGRESS
W01	1250DH	2	1	1250DH	19"X61"	DOUBLE HUNG
W02	1350RS	4	2	1350RS	21"X61"	RIGHT SLIDING
W03	1350SH	2	1	1350SH	21"X61"	SINGLE HUNG
W04	2050SH	2	1	2050SH	28"X61"	YES
W05	3030FX	1	2	3030FX	37"X37"	FIXED GLASS
W06	3030RS	2	1	3030RS	37"X37"	RIGHT SLIDING
W07	3030SH	2	1	3030SH	37"X37"	SINGLE HUNG
W08	3050SH	1	1	3050SH	37"X61"	YES
W09	4050SH	2	1	4050SH	44"X61"	SINGLE HUNG
W10	4050SH	5	2	4050SH	44"X61"	YES
W11	4050SH	5	2	4050SH	44"X61"	YES
W12	4050FX	1	1	4050FX	44"X61"	YES
W13	5050FX	1	1	5050FX	61"X61"	FIXED GLASS
W14	5050SH	1	1	5050SH	61"X61"	YES
W15	4040SH	2	2	4040SH	44"X44"	YES

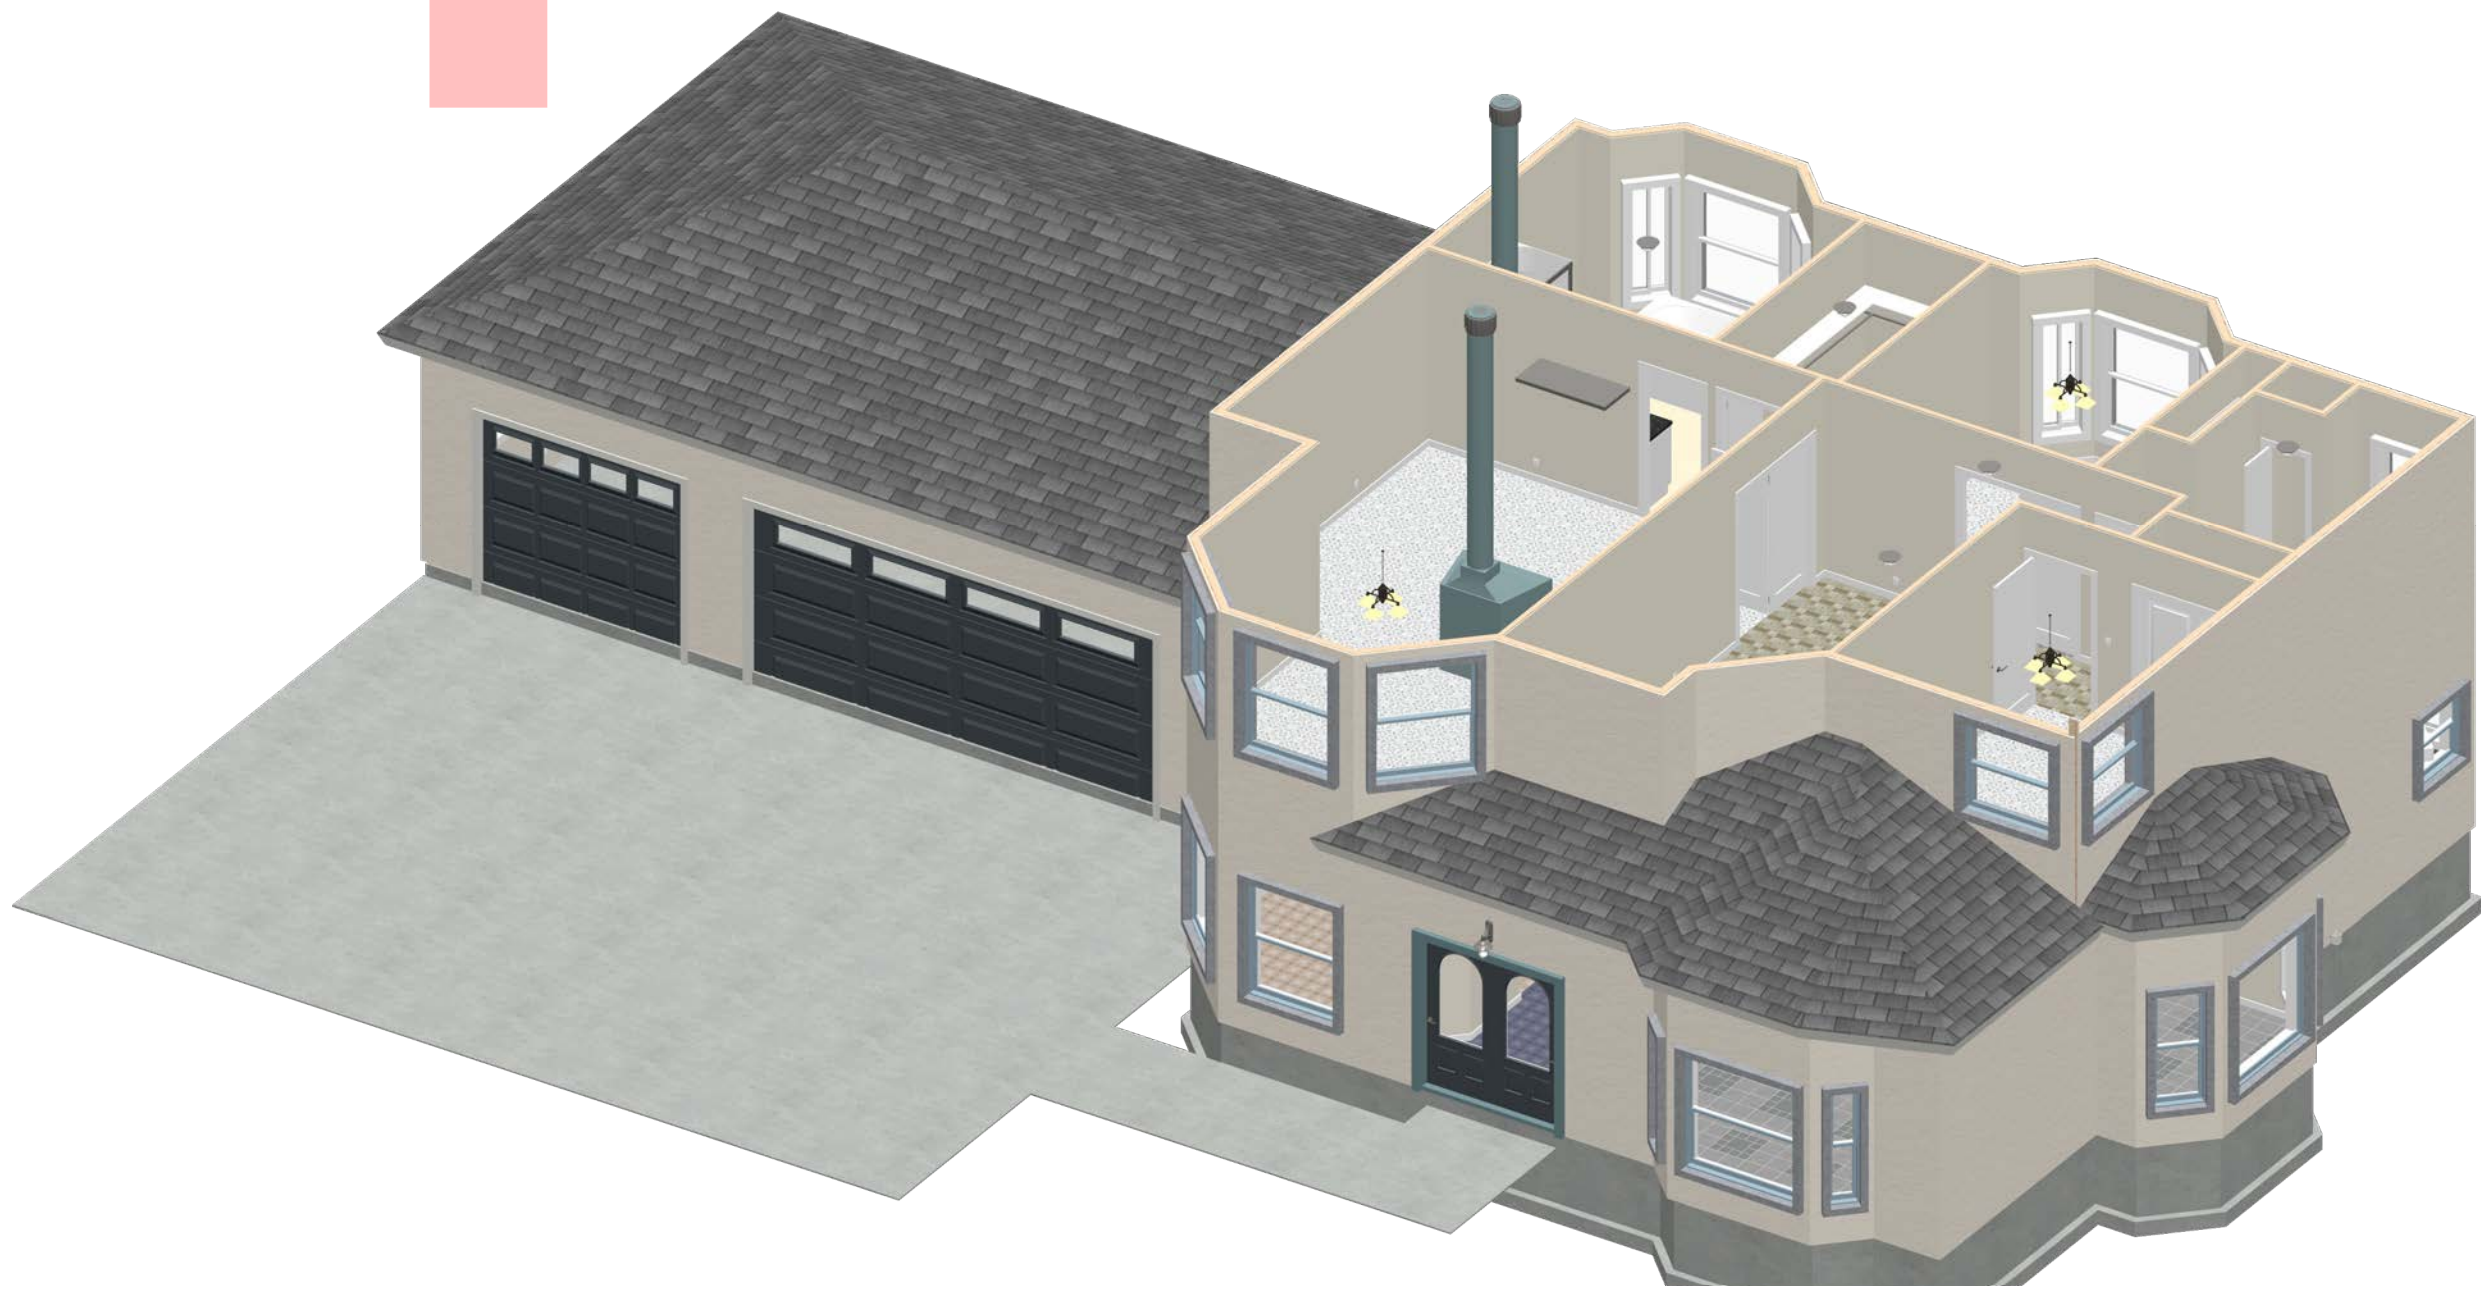

REVISION TABLE		REVISION BY		DESCRIPTION	
NUMBER	DATE	REVISION BY	DESCRIPTION	NUMBER	DATE



Second Floor Plan

DRAWINGS PROVIDED BY:
BC


DATE:
7/15/2026

SCALE:
as shown


SHEET:
P-3

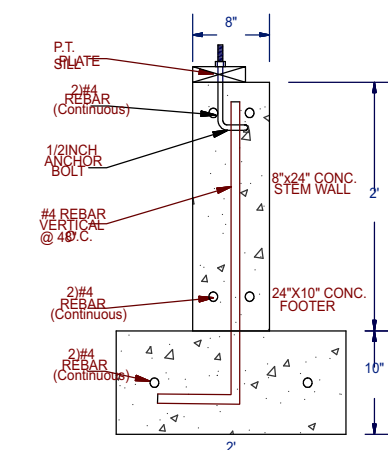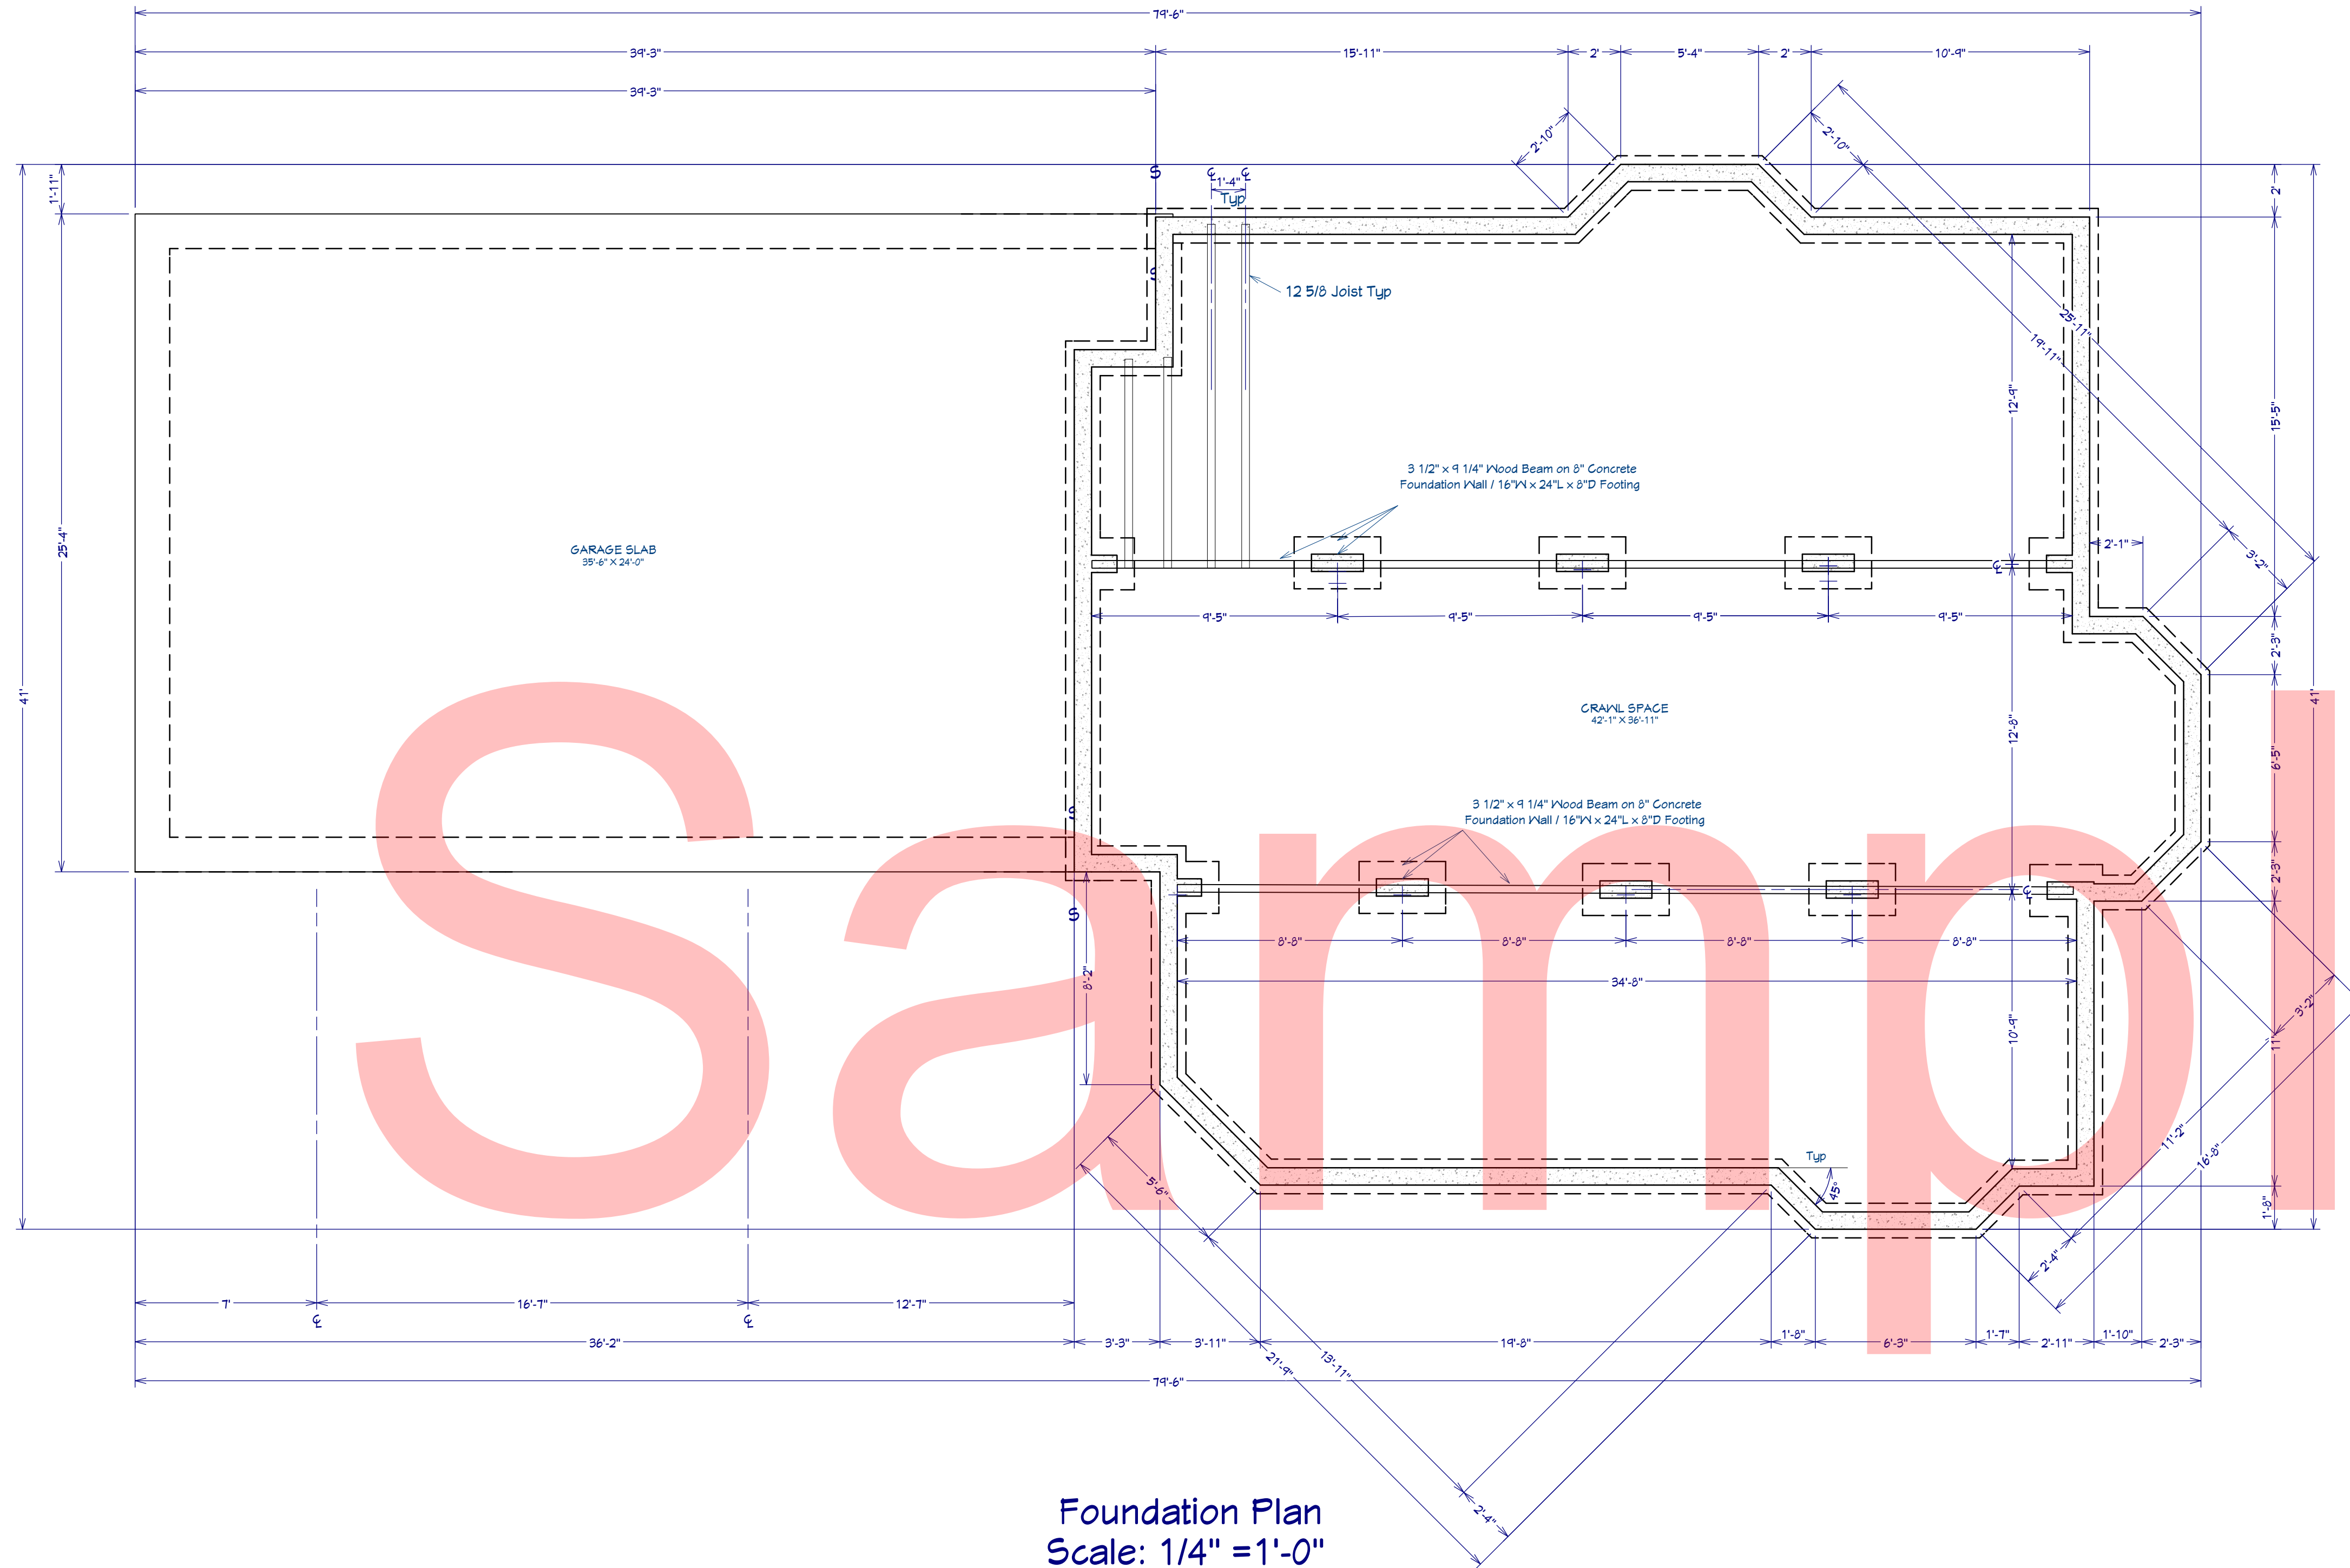

NOTE:
ALL REBAR PER LOCAL CODE
AND/OR ENGINEER'S DESIGN

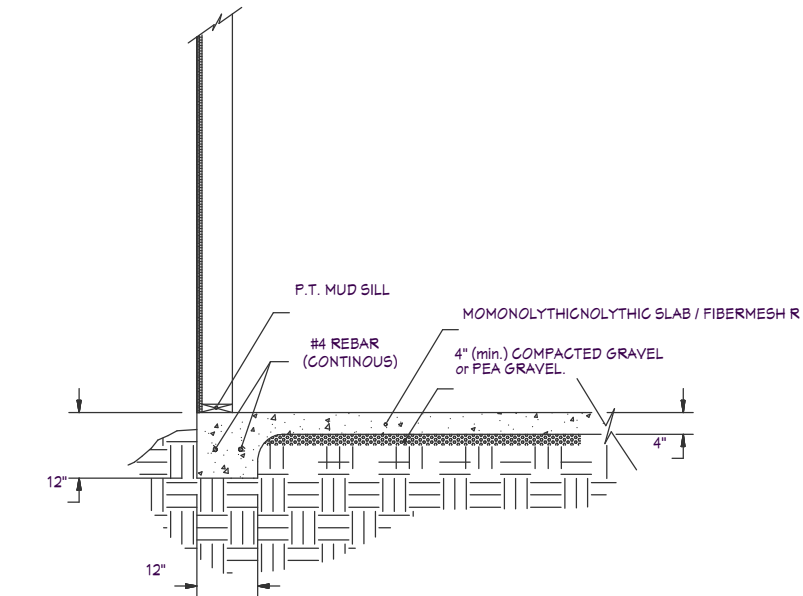

NOTE:
ALL REBAR PER LOCAL CODE
AND/OR ENGINEER'S DESIGN

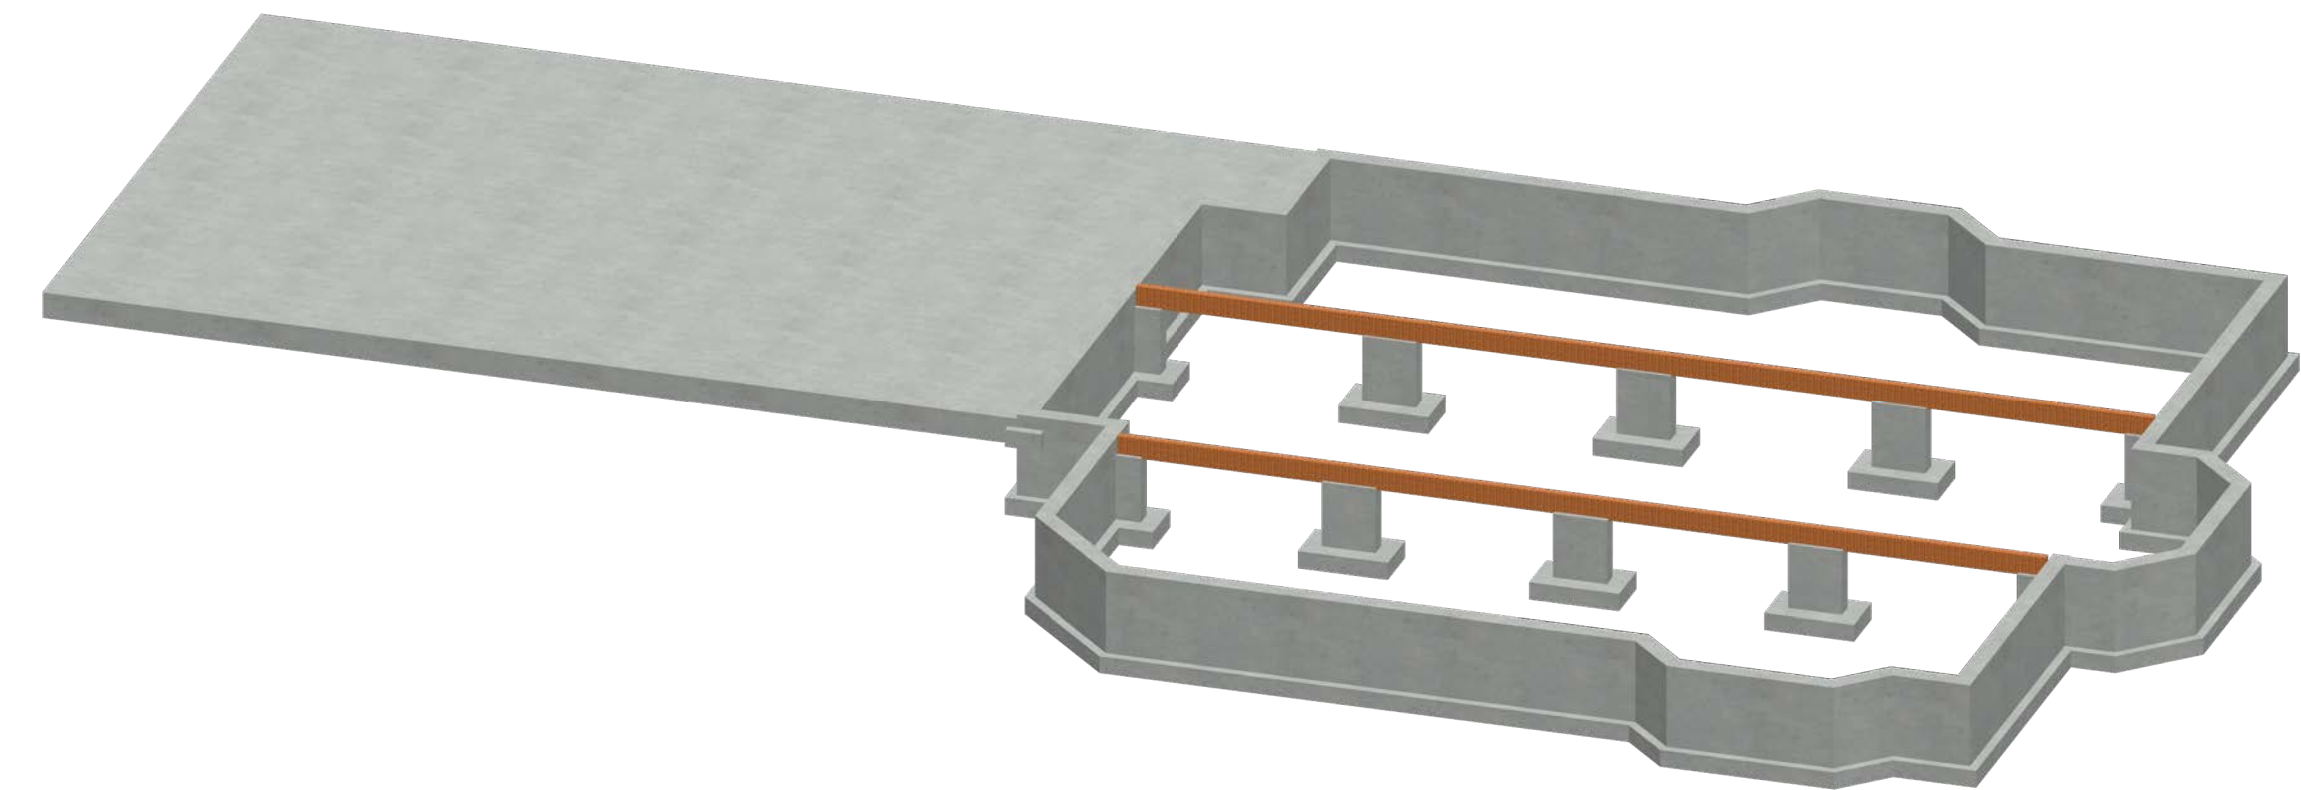

REVISION TABLE		DESCRIPTION
NUMBER	DATE	REVISION BY

Foundation Plan

DRAWINGS PROVIDED BY:

BC

DATE:

7/15/2026

SCALE:

as shown

SHEET:


P-4



Exterior Elevation Front
Scale: 3/16" = 1'-0"

DOOR SCHEDULE						
NUMBER	LABEL	QTY	FLOOR	SIZE	R/O	DESCRIPTION
D01	18080	1	1	18080	210"x94"	GARAGE-ERP STYLELINE II T
D02	18660	1	2	18660 R IN	22"x82 1/2"	HINGED-PANEL
D03	20660	2	1	20660 L IN	26"x92 1/2"	HINGED-PANEL
D04	24660	1	2	24660 L IN	30"x82 1/2"	HINGED-PANEL
D05	26660	2	1	26660 L IN	32"x82 1/2"	HINGED-PANEL
D06	26660	1	1	26660 R IN	32"x82 1/2"	HINGED-PANEL
D07	26660	1	2	26660 R IN	32"x82 1/2"	HINGED-PANEL
D08	26660	1	1	26660 R EX	34"x93"	EXT. HINGED-DOOR E02
D09	26660	1	2	26660 L IN	34"x82 1/2"	HINGED-PANEL
D10	26660	1	2	26660 R IN	34"x82 1/2"	HINGED-PANEL
D11	30660	1	1	30660 L EX	36"x93"	EXT. HINGED-DOOR E01
D12	30660	1	1	30660 R IN	32"x82 1/2"	SLIDER-DOOR F04
D13	50660	2	2	50660 C-R IN	62"x82 1/2"	DOUBLE HINGED-PANEL
D14	50660	2	2	50660 L IN	62"x82 1/2"	SLIDER-DOOR F04
D15	60660	1	1	60660 C-L/R EX	74"x93"	EXT. DOUBLE HINGED-DOOR E11
D16	90800	1	1	90800	110"x94"	GARAGE-ERP STYLELINE II T

WINDOW SCHEDULE						
NUMBER	LABEL	QTY	FLOOR	SIZE	R/O	DESCRIPTION
JN01	1250DH	2	1	1250DH	19"x61"	DOUBLE HUNG
JN02	1950RS	4	2	1950RS	21"x61"	RIGHT SLIDING
JN03	1850SH	2	1	1850SH	21"x61"	SINGLE HUNG
JN04	2050SH	2	1	2050SH	25"x61"	SINGLE HUNG
JN05	3030FX	1	2	3030FX	31"x31"	FIXED GLASS
JN06	3030RS	2	1	3030RS	31"x31"	RIGHT SLIDING
JN07	3030SH	2	1	3030SH	31"x31"	SINGLE HUNG
JN08	3050SH	1	1	3050SH	37"x61"	SINGLE HUNG
JN09	4050SH	2	1	4050SH	49"x61"	SINGLE HUNG
JN10	4050SH	2	1	4050SH	49"x61"	SINGLE HUNG
JN11	4050SH	5	2	4050SH	49"x61"	SINGLE HUNG
JN12	4050FX	1	1	4050FX	49"x61"	FIXED GLASS
JN13	5050FX	1	1	5050FX	61"x61"	FIXED GLASS
JN14	5050SH	1	1	5050SH	61"x61"	SINGLE HUNG
JN15	4040SH	2	2	4040SH	49"x44"	SINGLE HUNG

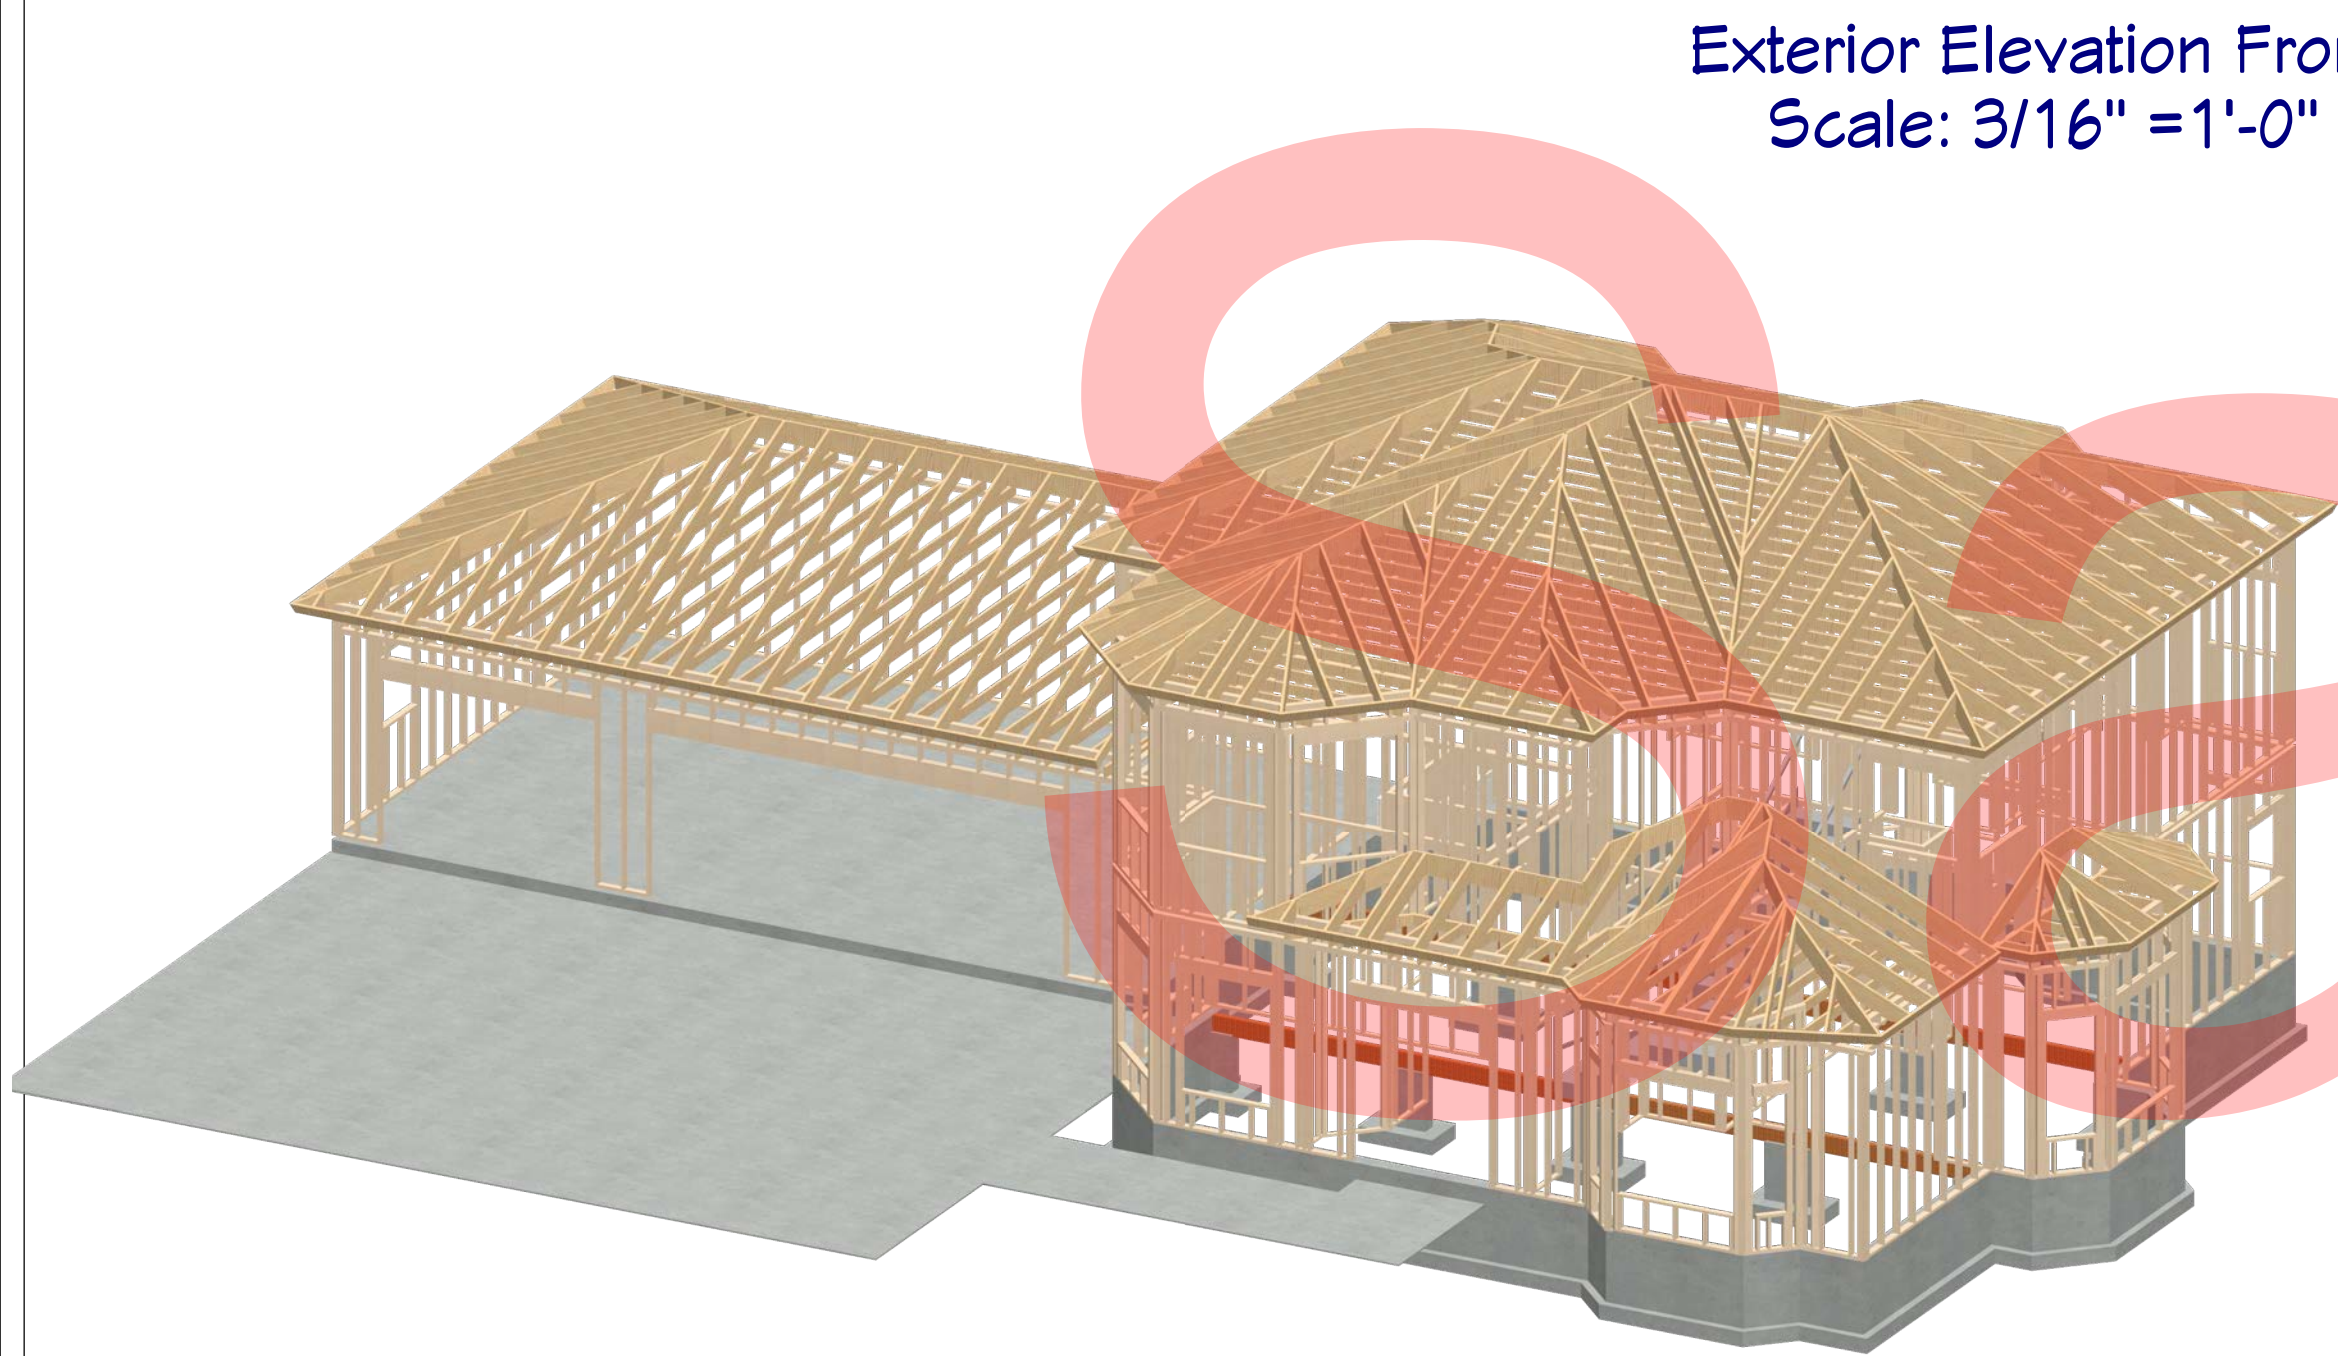

Exterior Elevation Back
Scale: 3/16" = 1'-0"



Exterior Elevation Left
Scale: 3/16" = 1'-0"



Exterior Elevation Right
Scale: 3/16" = 1'-0"

REVISION TABLE		REVISION BY	
NUMBER	DATE	DESCRIPTION	

Exterior Elevations

DRAWINGS PROVIDED BY:
BC

DATE:


7/15/2026

SCALE:

as shown


SHEET:

P-5

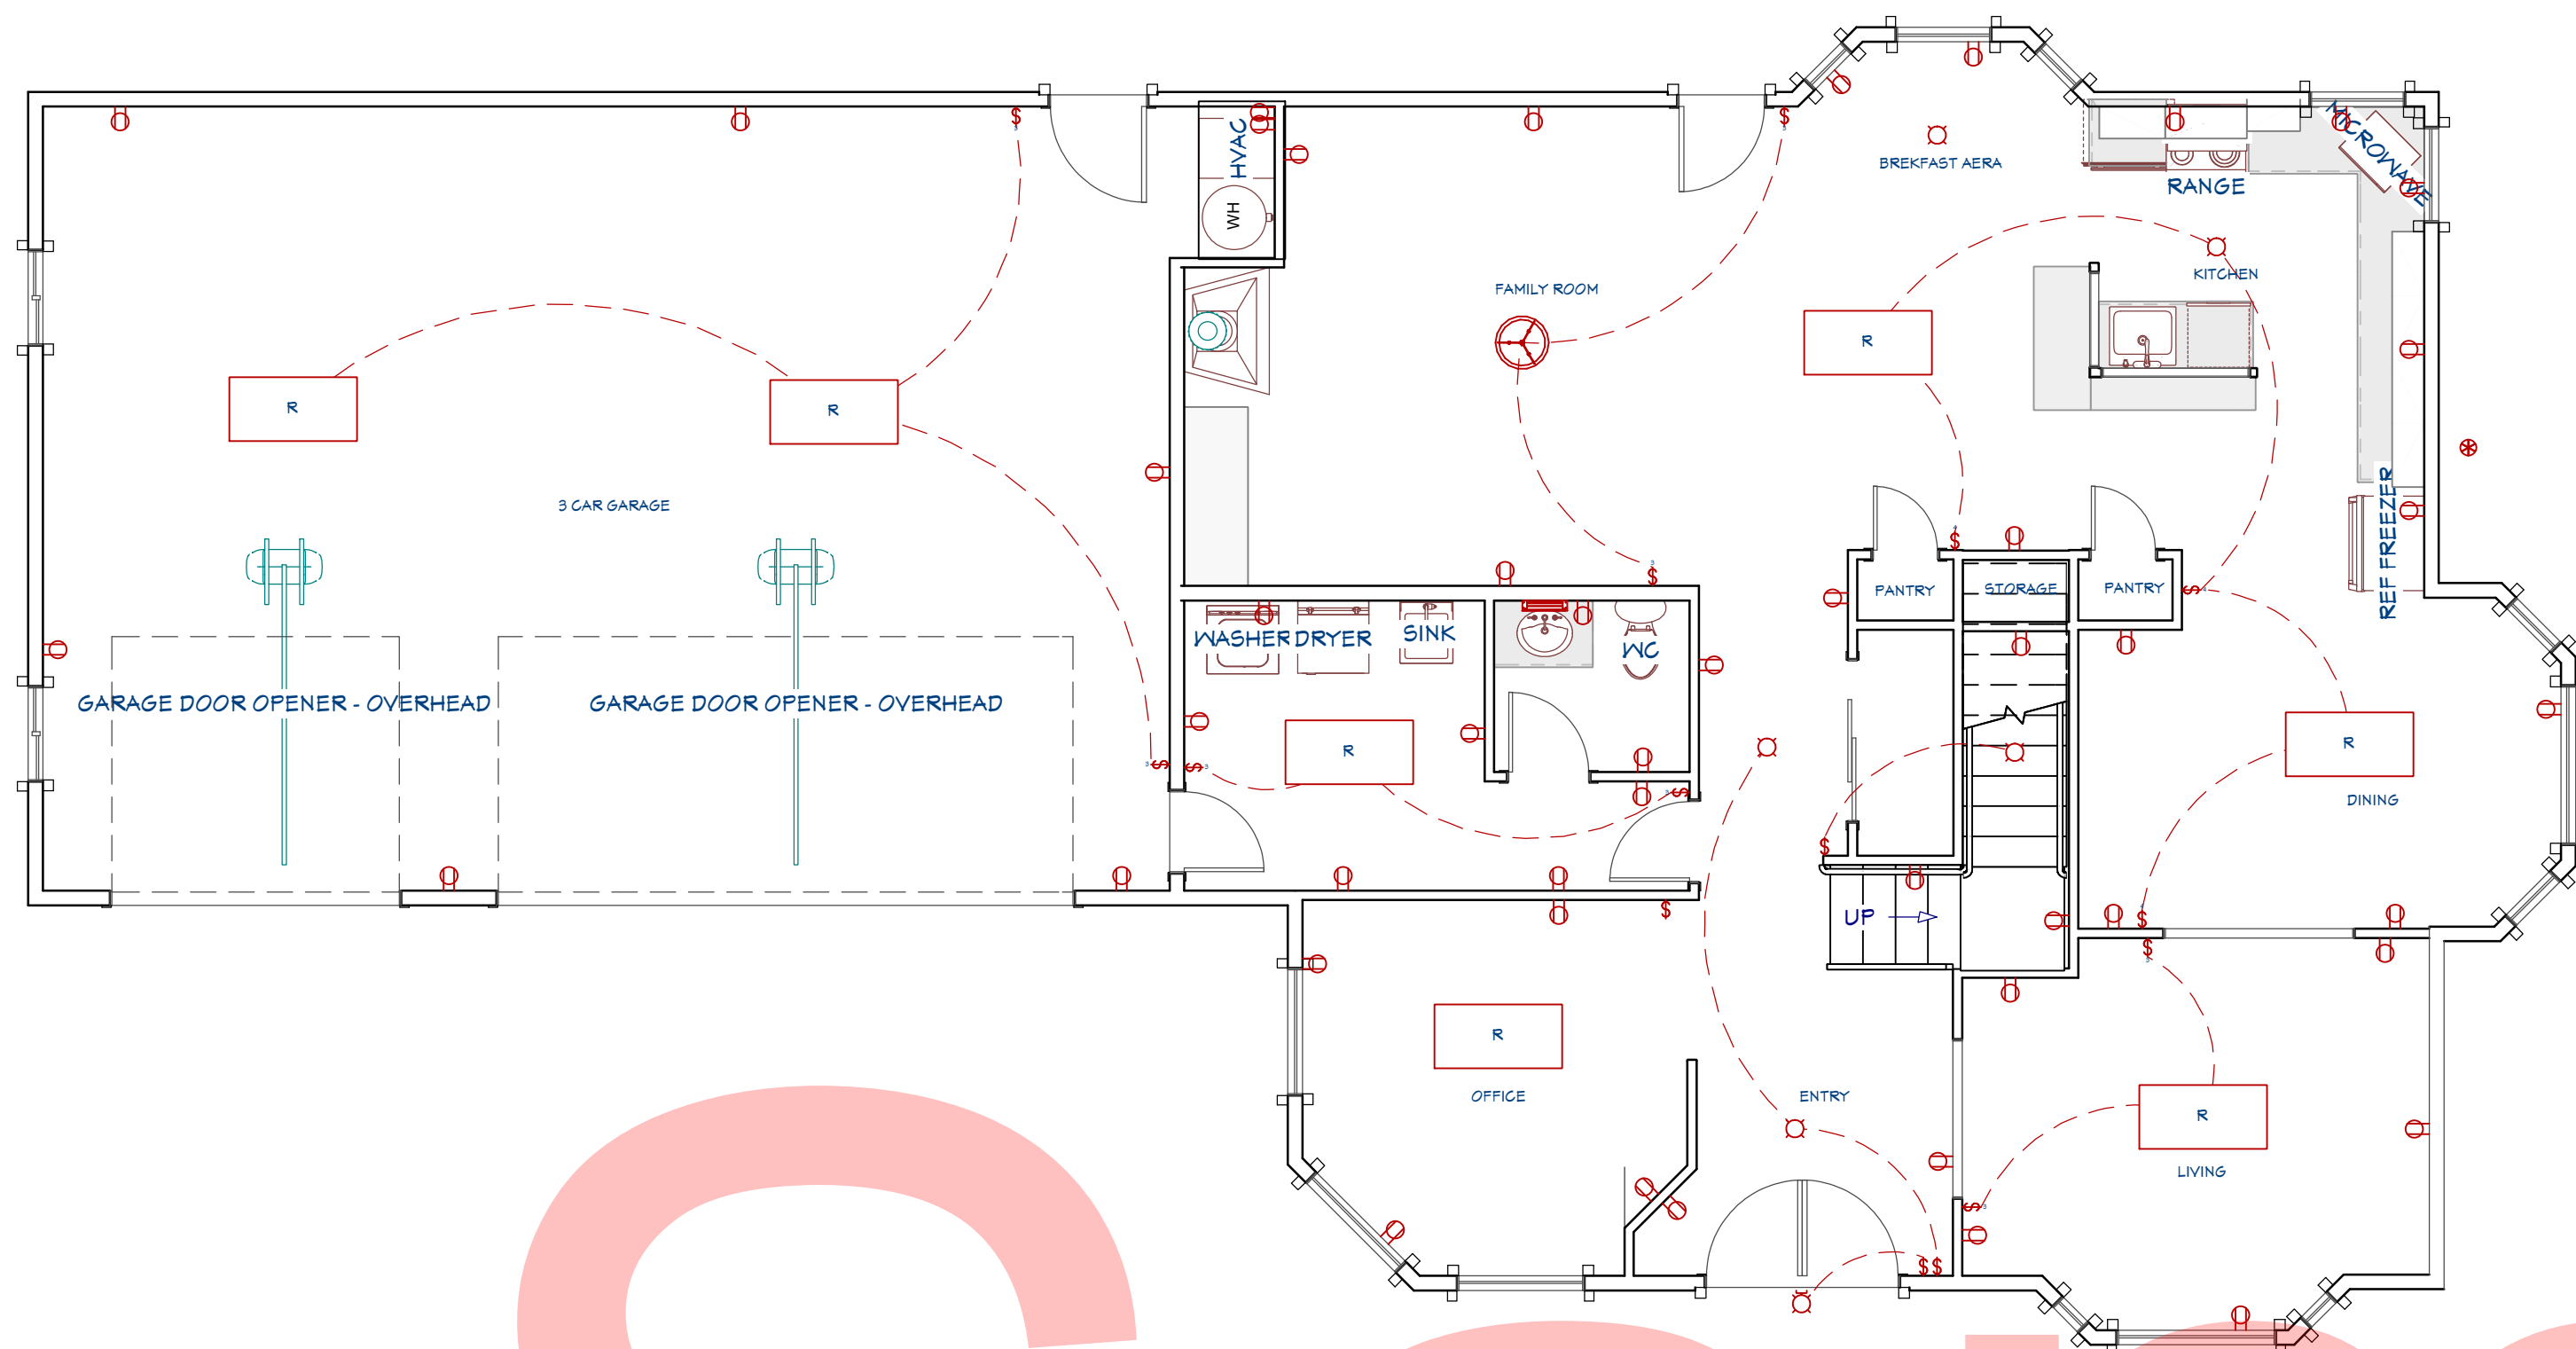

Main Floor Electrical Plan
Scale: 3/16" = 1'-0"

ELECTRICAL SCHEDULE		
SYMBOL	QTY	DESCRIPTION
⚡	5	1 3-WAY SWITCH
⚡	3	1 4-WAY SWITCH
⚡	3	2 ARTS & CRAFTS CHANDELIER
⚡	1	1 BOYAL PENDANT CHANDELIER
⚡	1	1 CAGED LANTERN SCGONGE
⚡	41	1 DUPLEX
⚡	1	2 BFCI
⚡	1	1 K-81144-SLE MAXSTON LIGHTED MEDICINE CABINET
⚡	1	2 MEDIUM DOUBLE SURFACE MOUNTED TUBE LIGHT (48"x24")
⚡	1	1 PATH LIGHT
⚡	7	1 SHORT DOUBLE RECESSED TUBE LIGHT (48"x24")
⚡	4	1 SINGLE POLE SWITCH
⚡	5	1 TRADITIONAL FLUSH DOME
⚡	28	2 DUPLEX
⚡	3	2 K-81144-SLE MAXSTON LIGHTED MEDICINE CABINET
⚡	7	2 SINGLE POLE SWITCH
⚡	5	2 TRADITIONAL FLUSH DOME

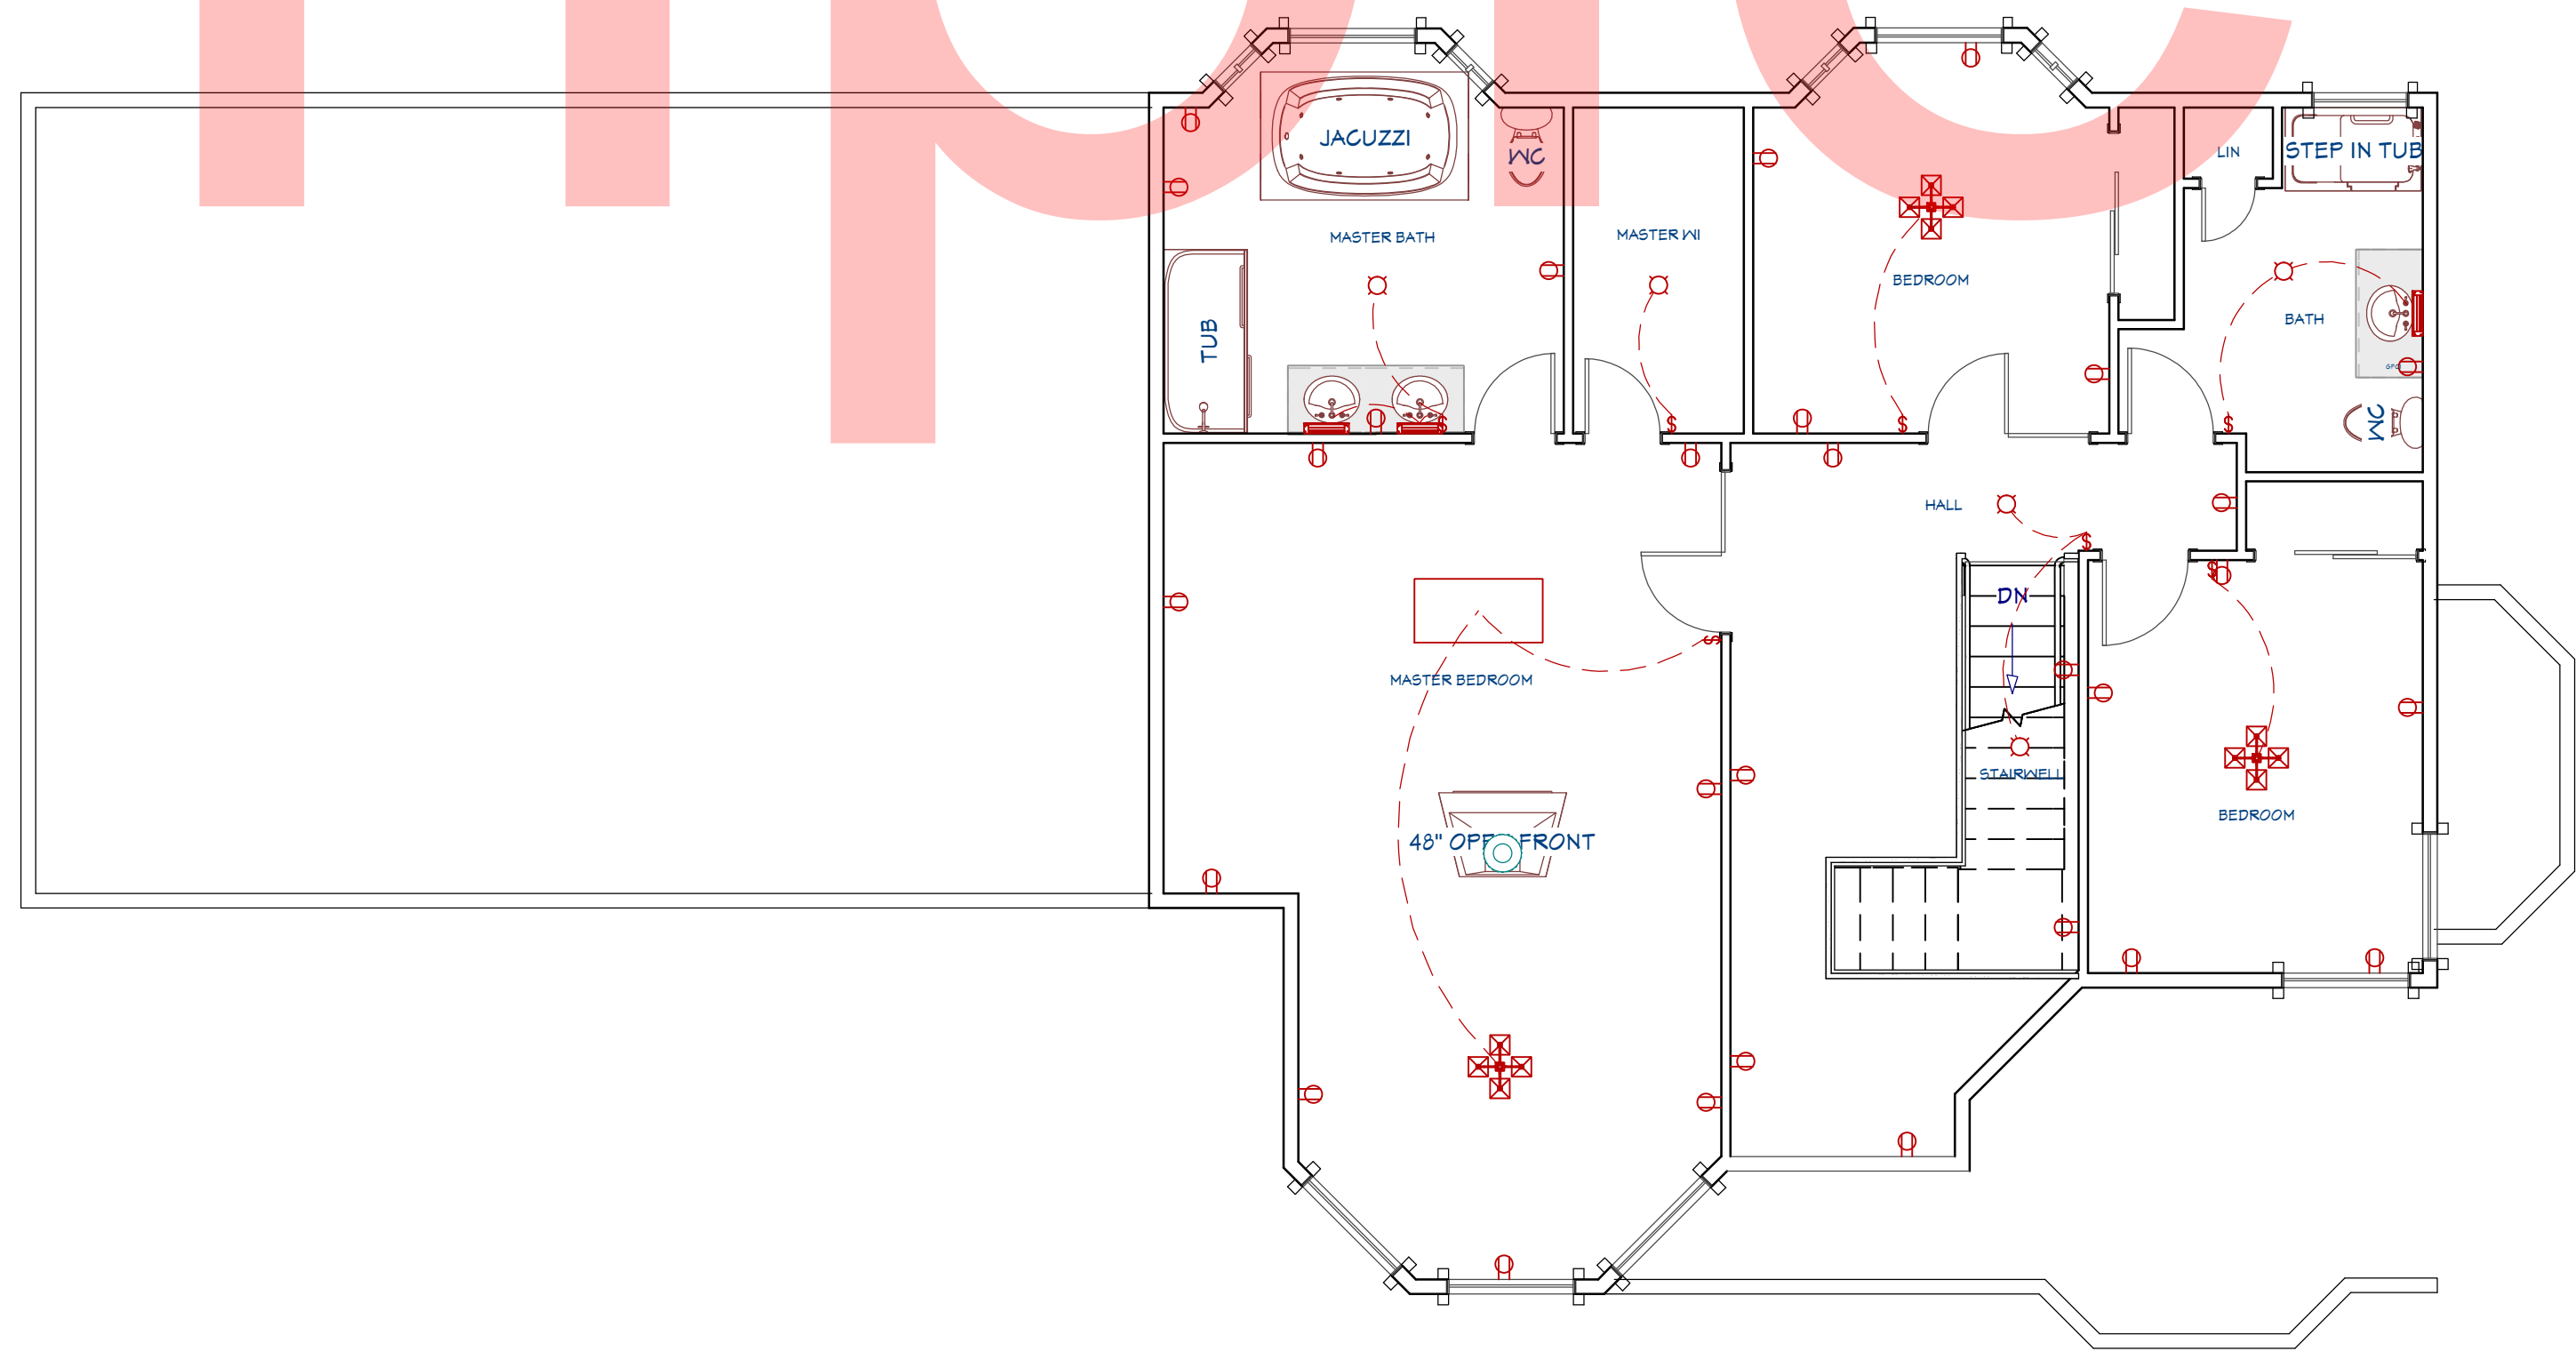

Second Floor Electrical Plan
Scale: 3/16" = 1'-0"

REVISION TABLE		DESCRIPTION
NUMBER	DATE	REVISION BY

r Electrical Plan

DRAWINGS PROVIDED BY:
BC

DATE:

7/15/2026

SCALE:


as shown

SHEET:

P-6



Family Room View

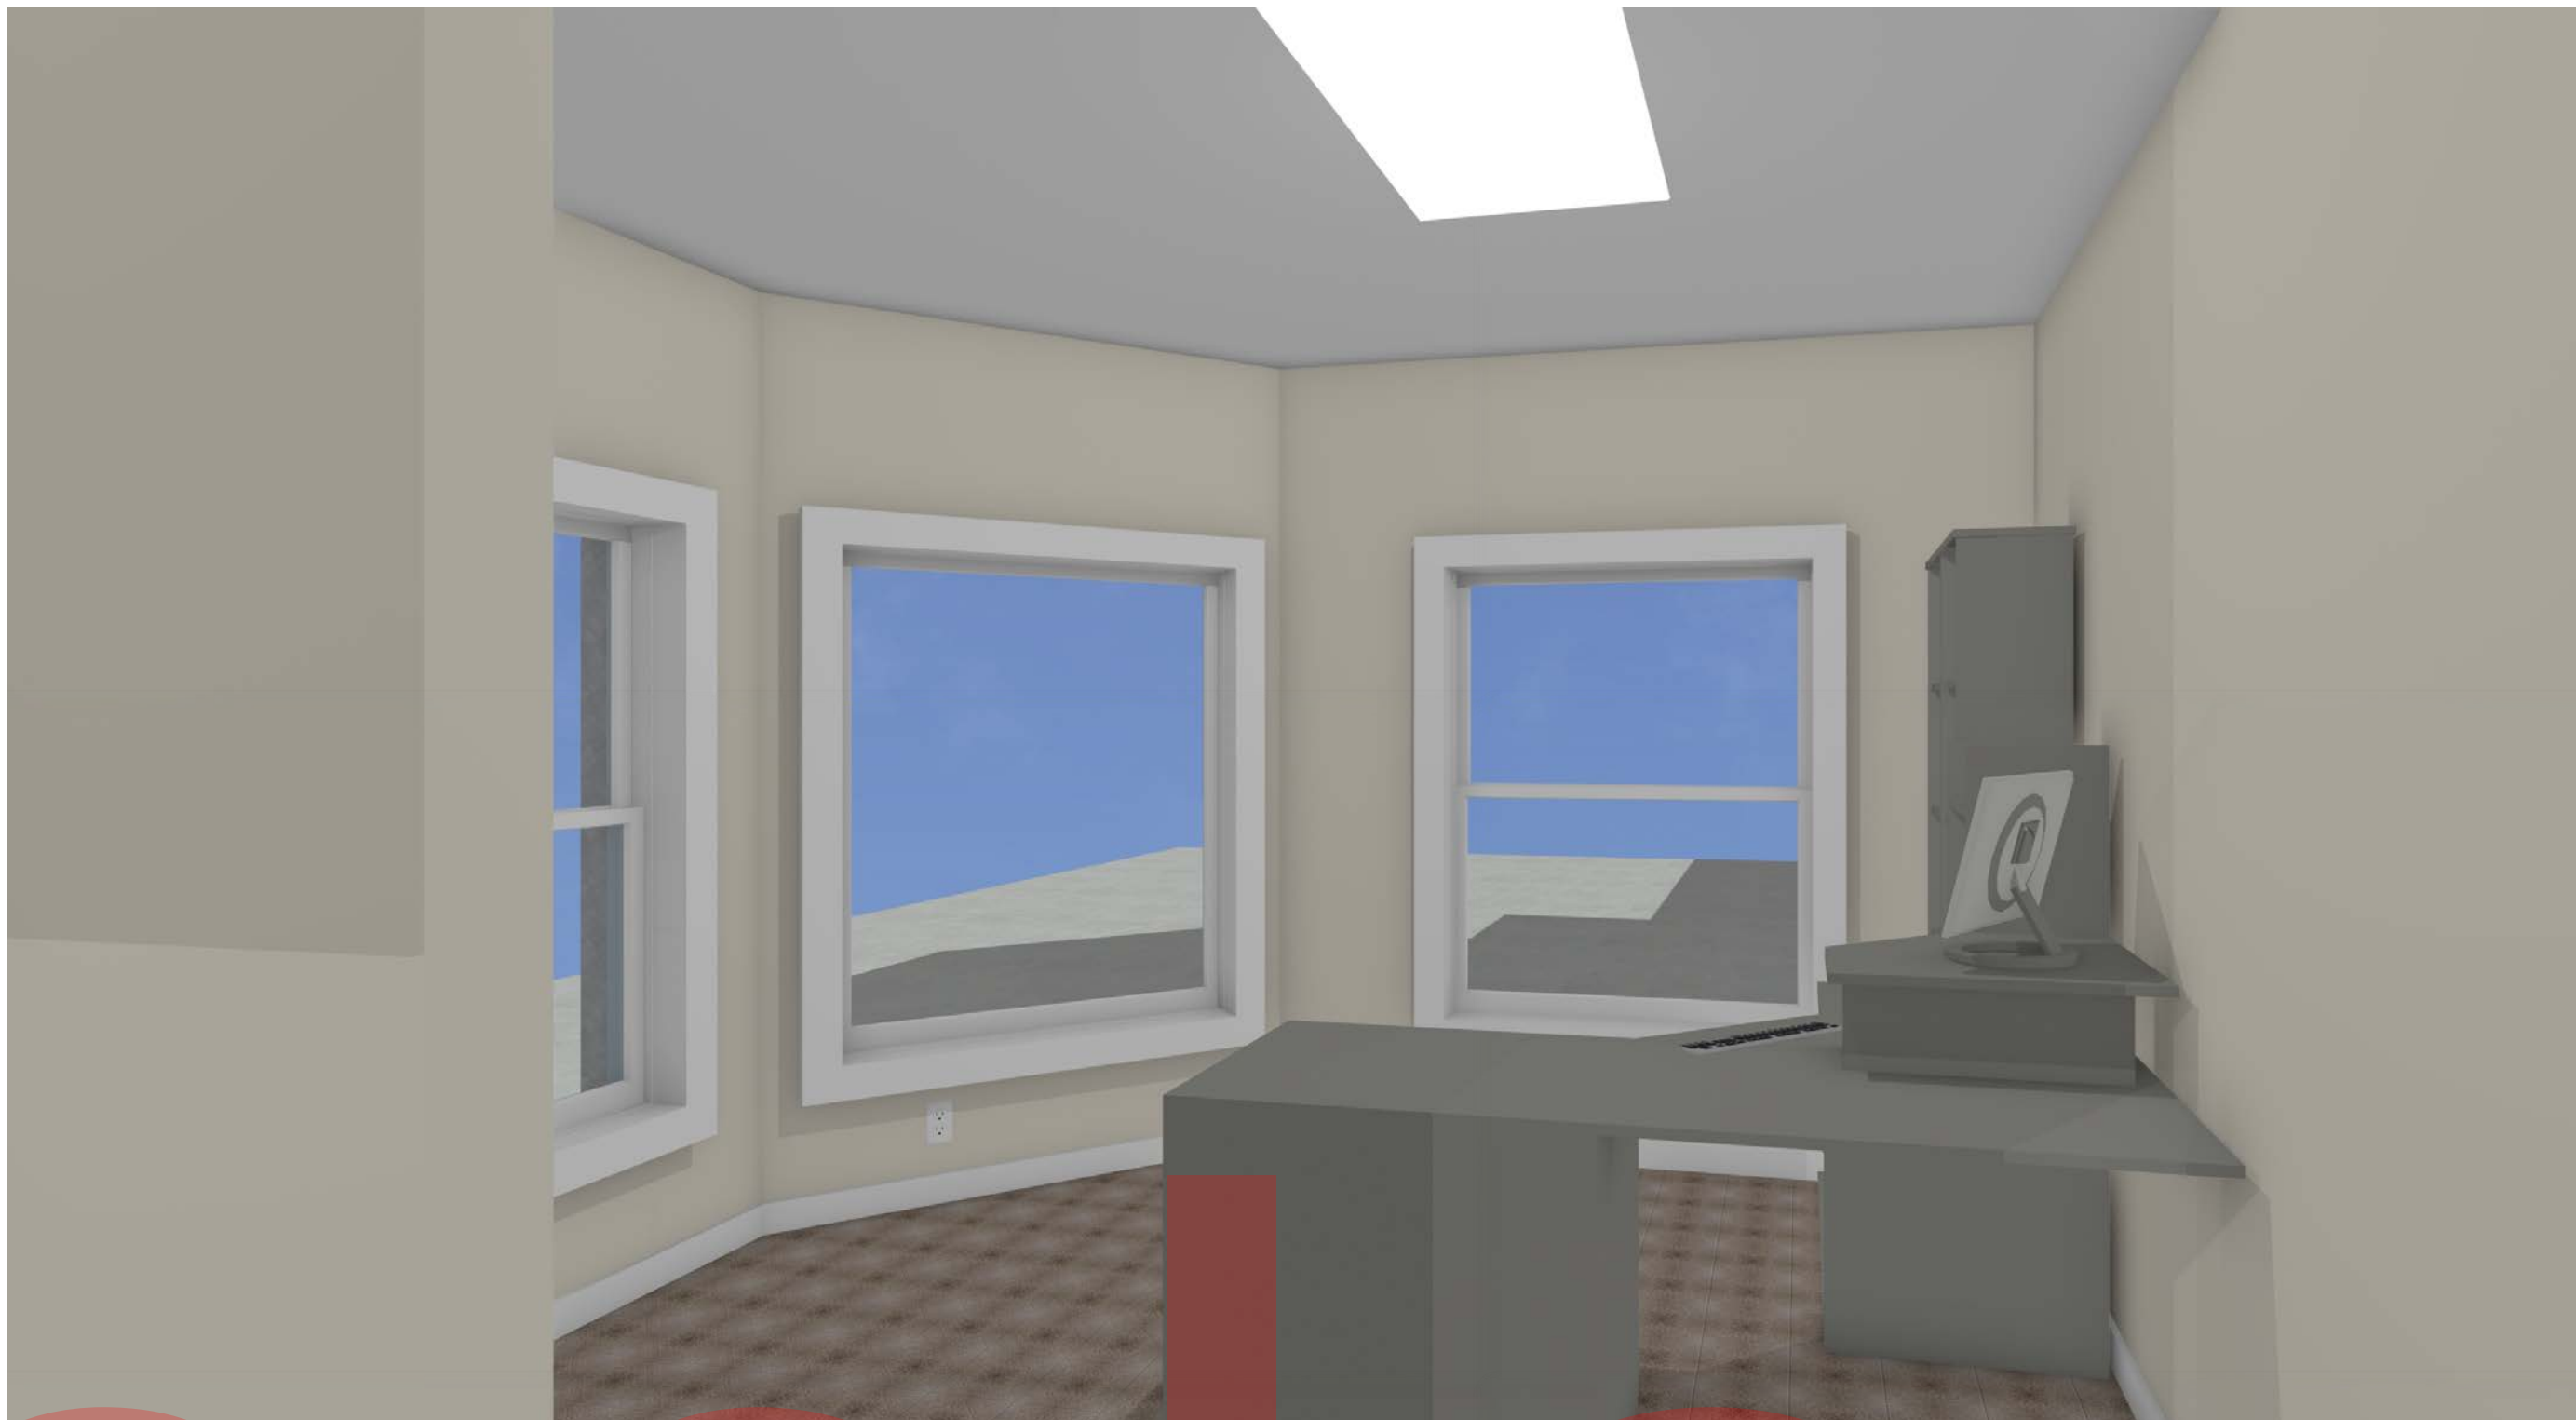

Office View



Kitchen View



Master Bedroom View

REVISION TABLE		REVISION BY	DESCRIPTION
NUMBER	DATE		

Interior Views

DRAWINGS PROVIDED BY:
BC

DATE:


7/15/2026

SCALE:

as shown


SHEET:

P-7

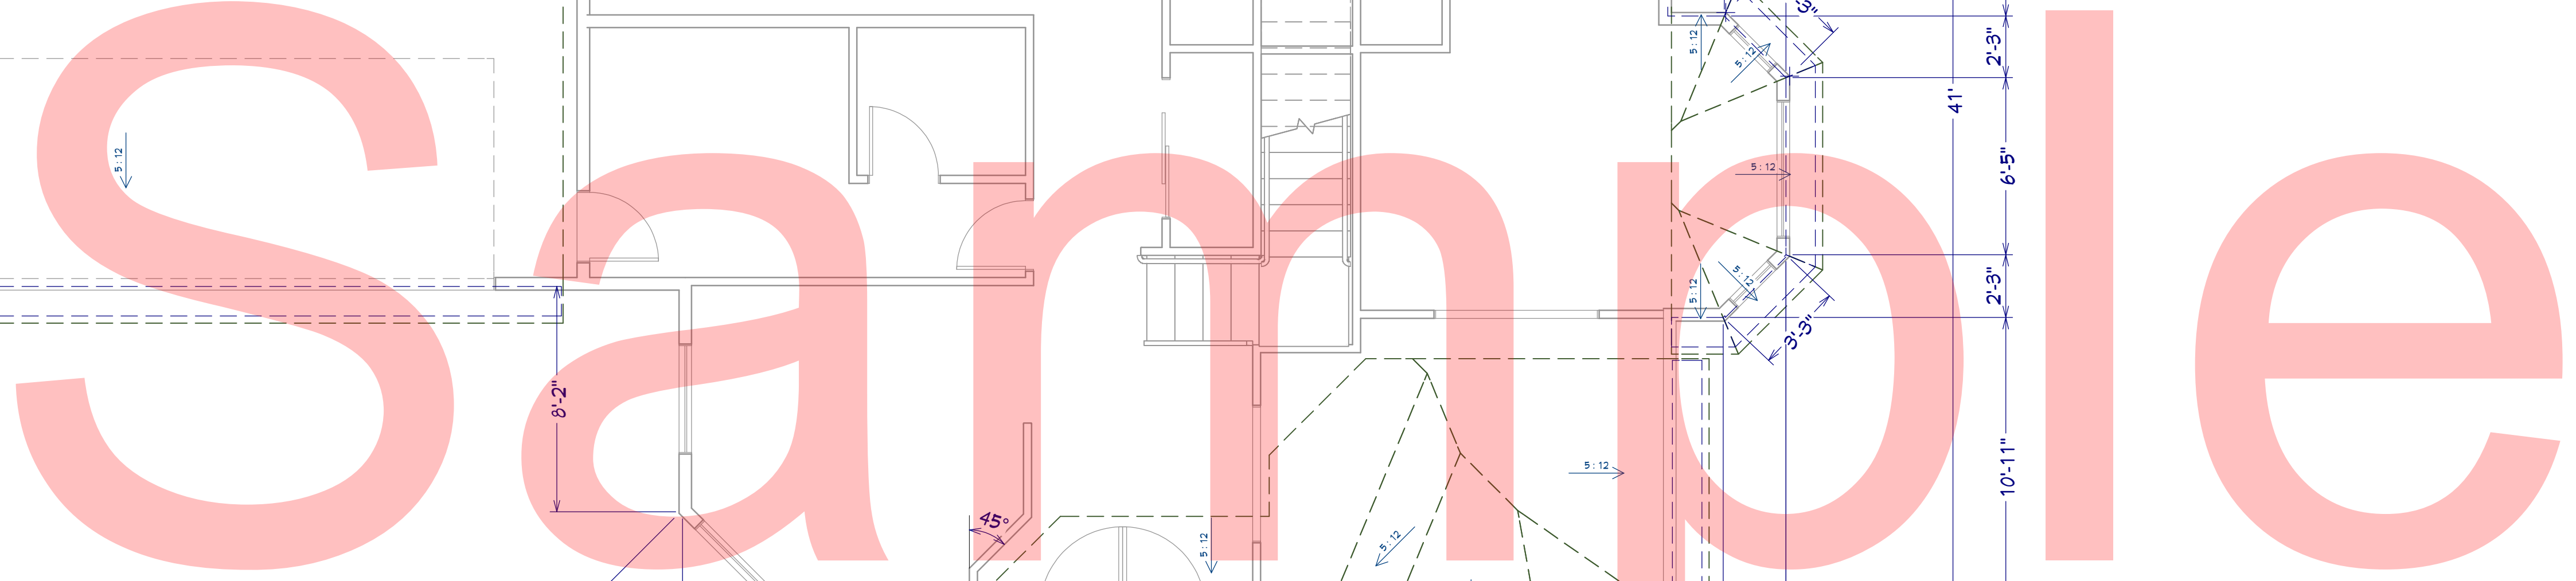


A 3D architectural rendering of a two-story residential house. The house features a complex roofline with multiple gables and a large two-car garage on the left side. The exterior walls are a light beige color, accented with dark grey trim around the windows and doors. The roof is covered in dark grey shingles. The house is set on a light grey concrete foundation. The overall style is modern and clean.

DATE:
7/15/2026
SCALE:
as shown
SHEET:
P-8

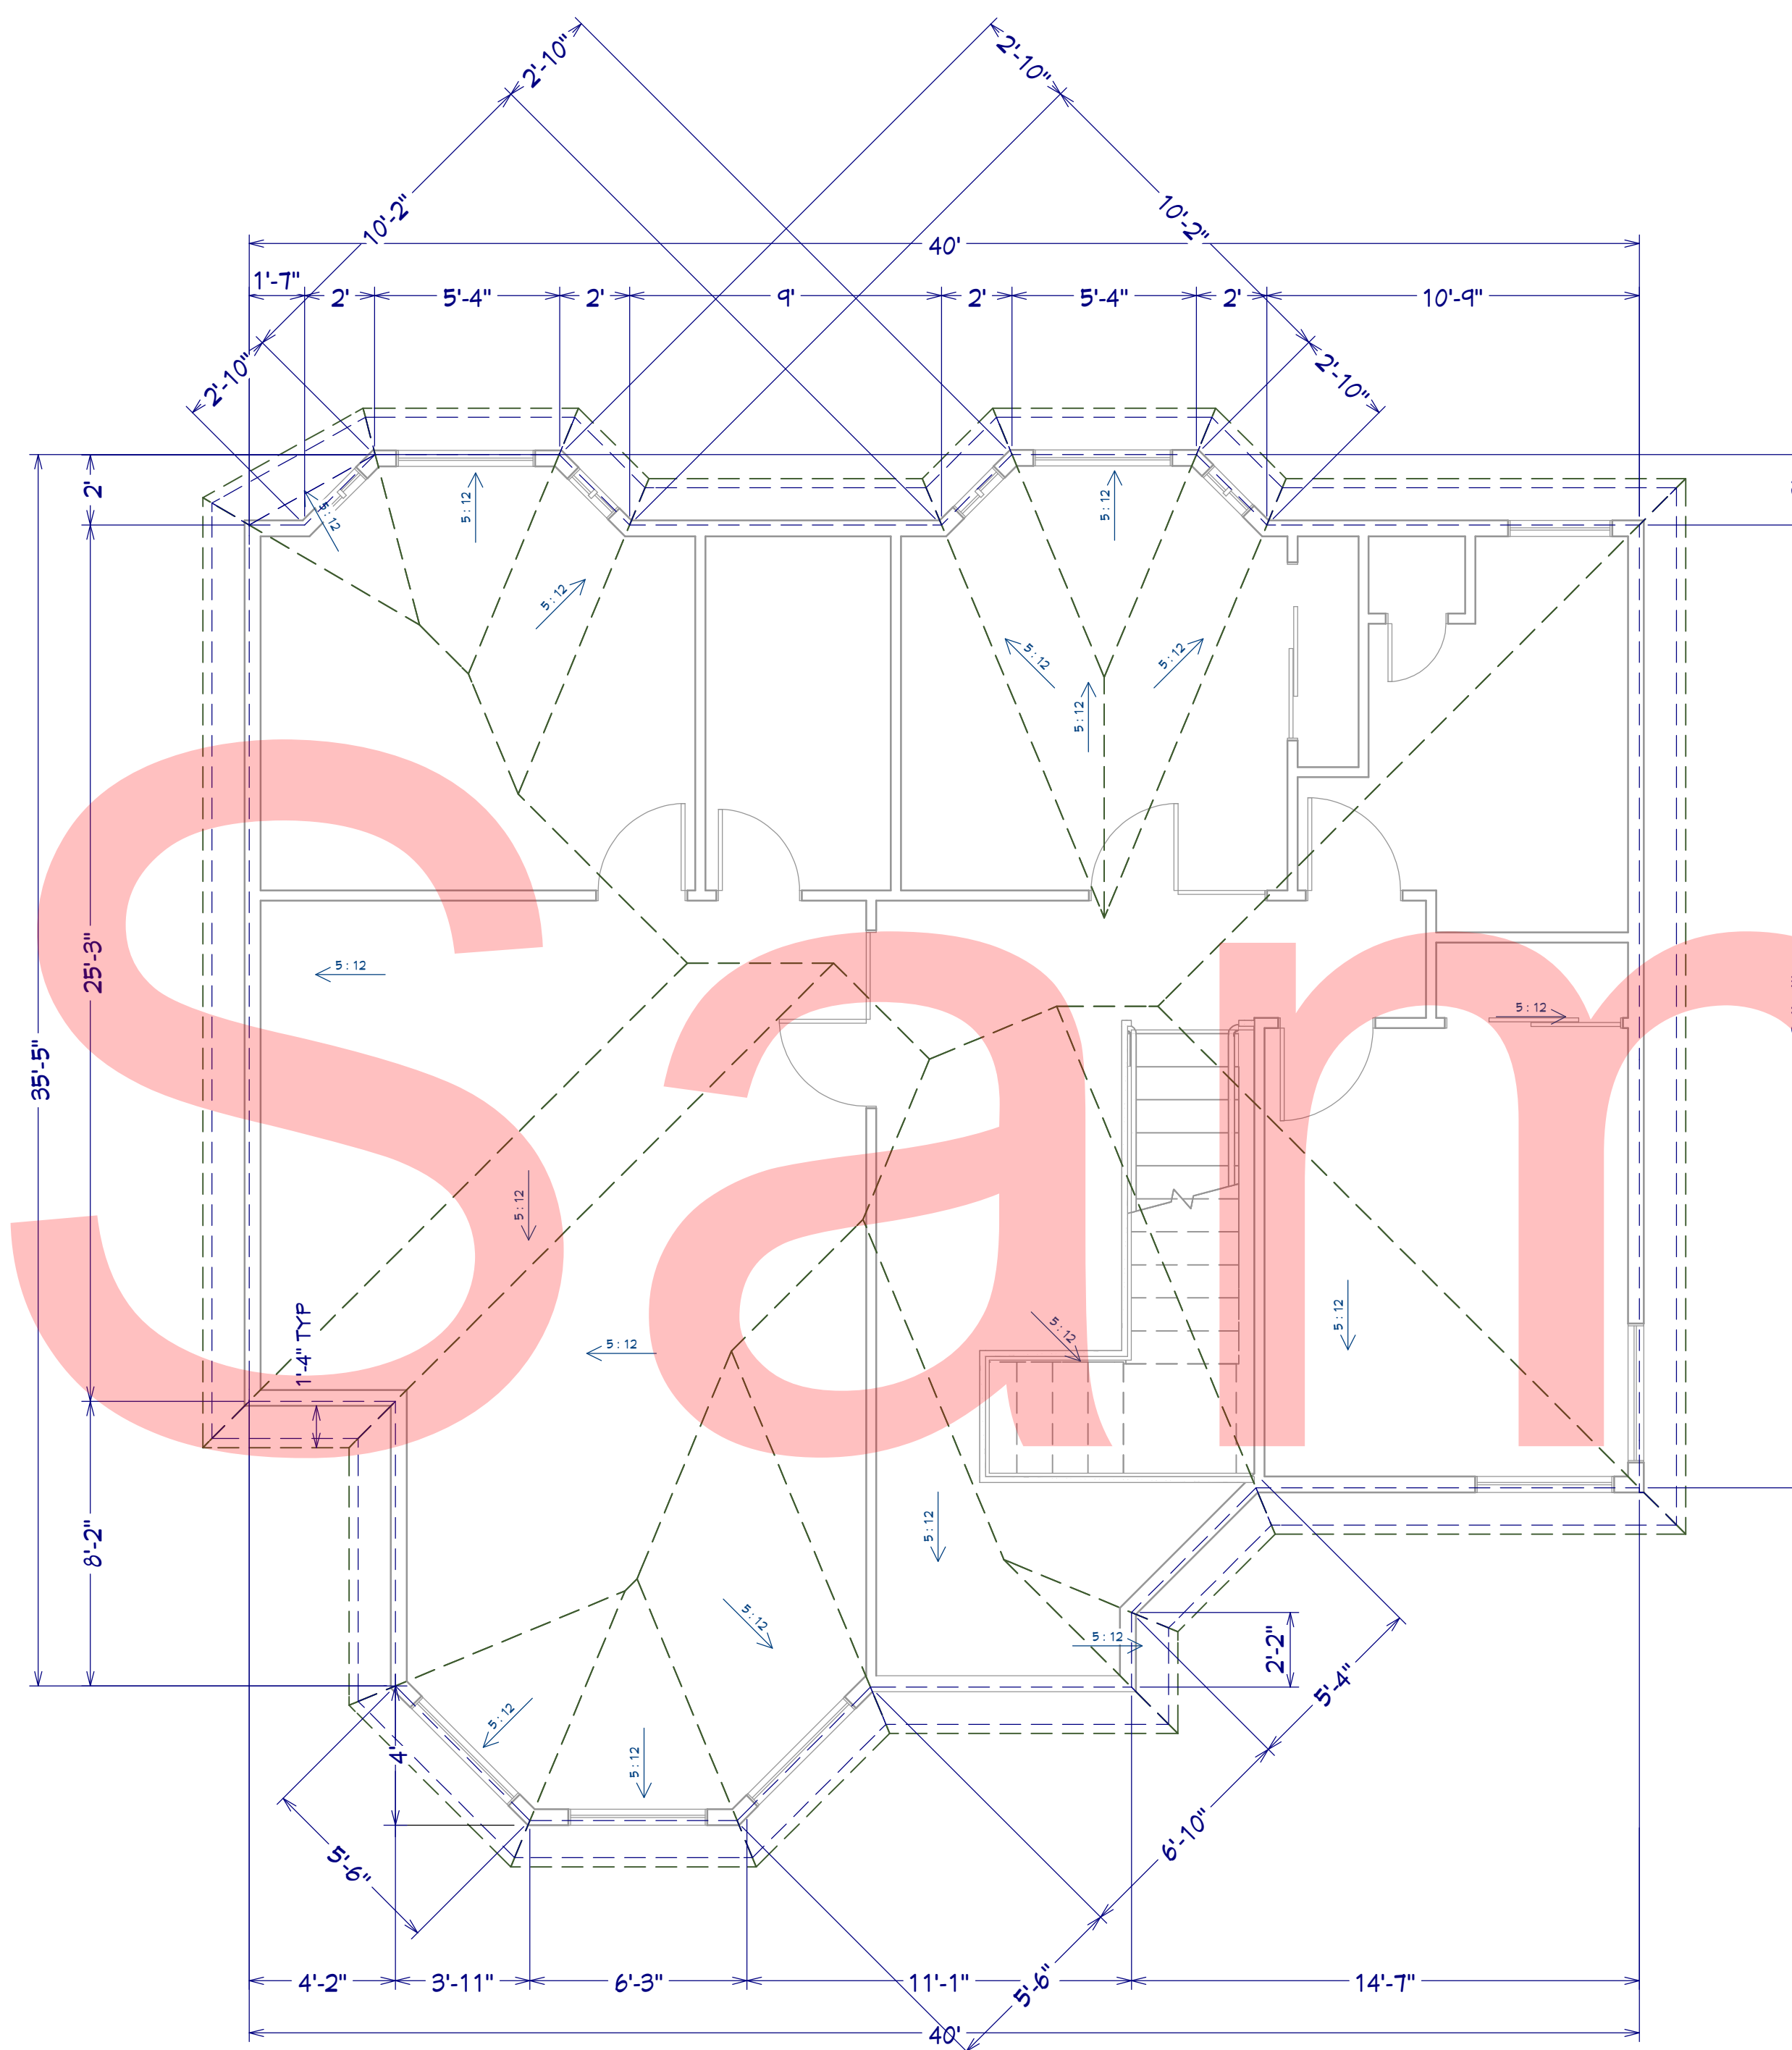

2nd Floor Roof Plan
Scale: 1/4" = 1'-0"

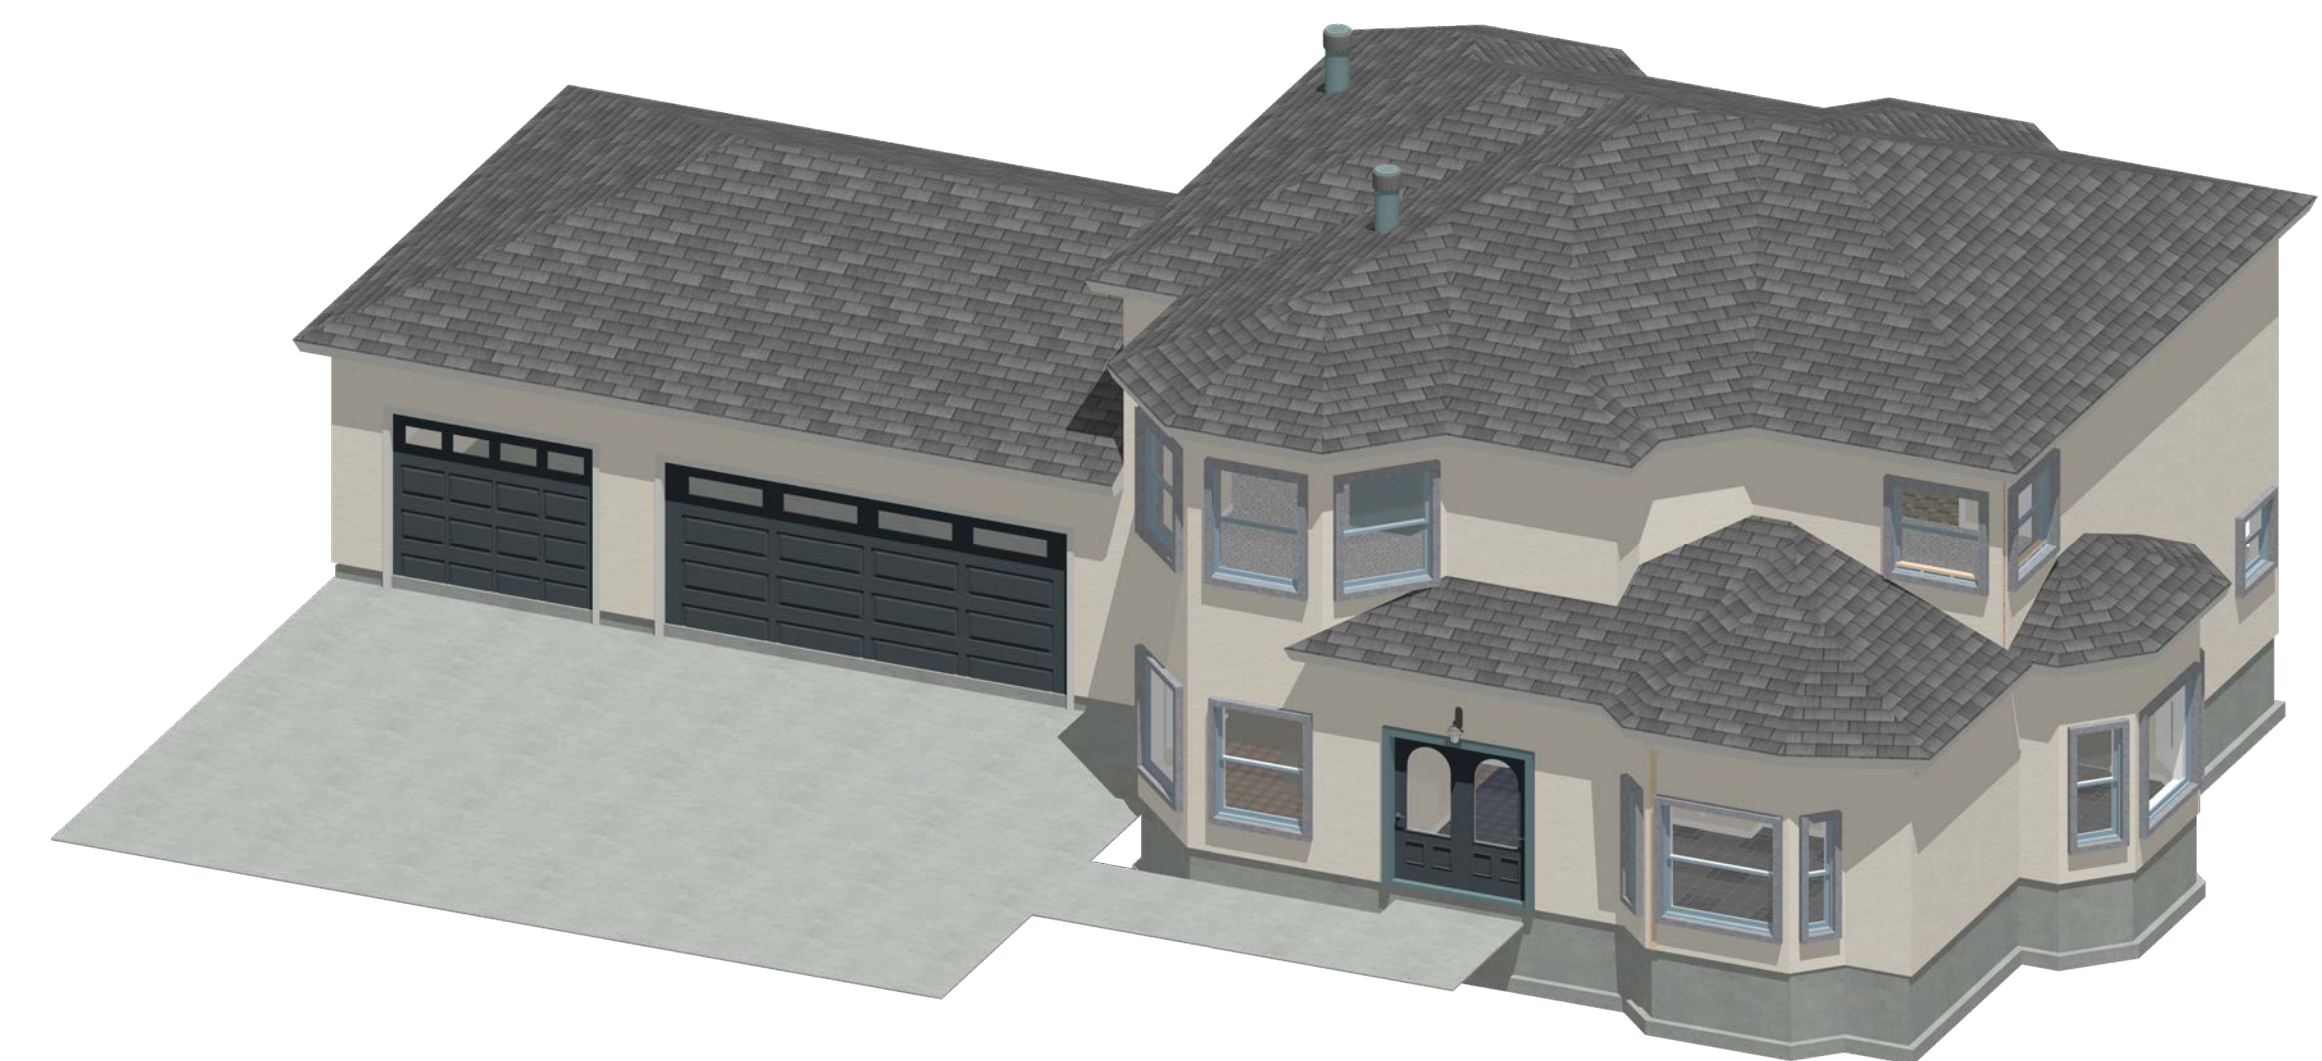[illegible]

2nd Floor Roof Plan

BC

DATE:
/15/2026

SCALE:

As shown

SHEET:

P-9