


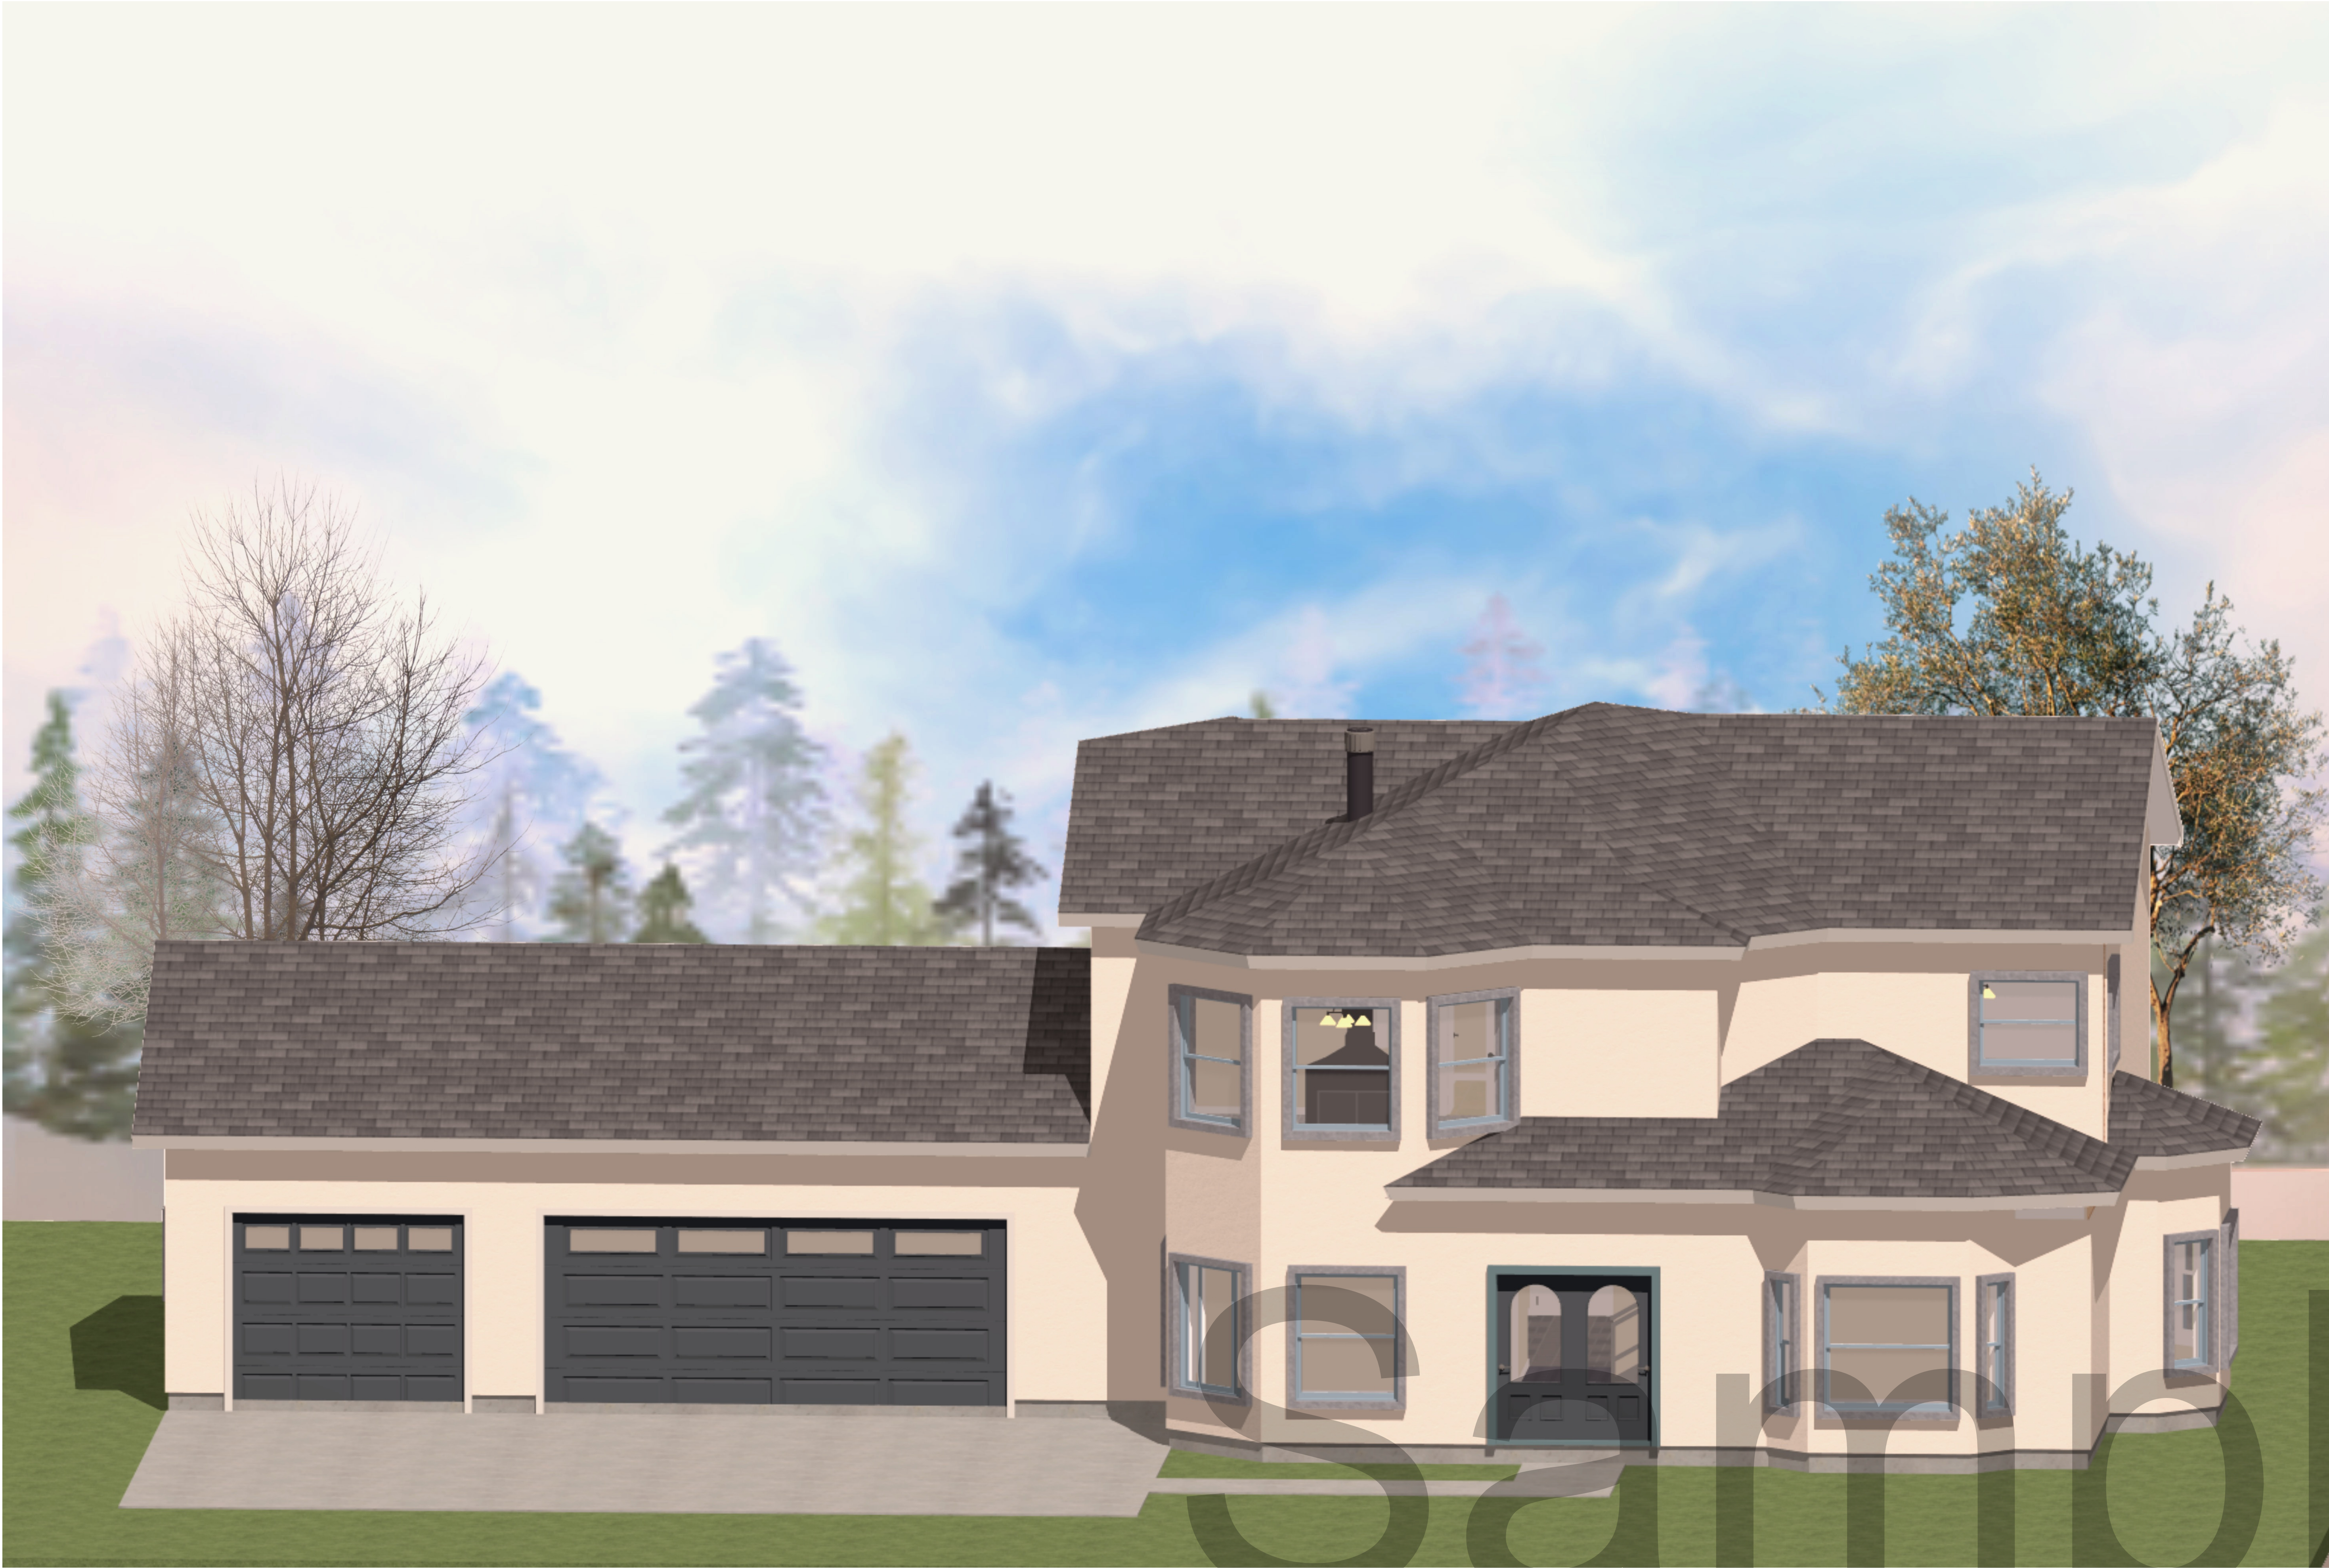

REVISION TABLE		REVISION TABLE	
NUMBER	DATE	REVISION BY	DESCRIPTION


Project Overview

DRAWINGS PROVIDED BY:
BC

DATE:
10/3/2025

SCALE:
as shown

SHEET:
P-1

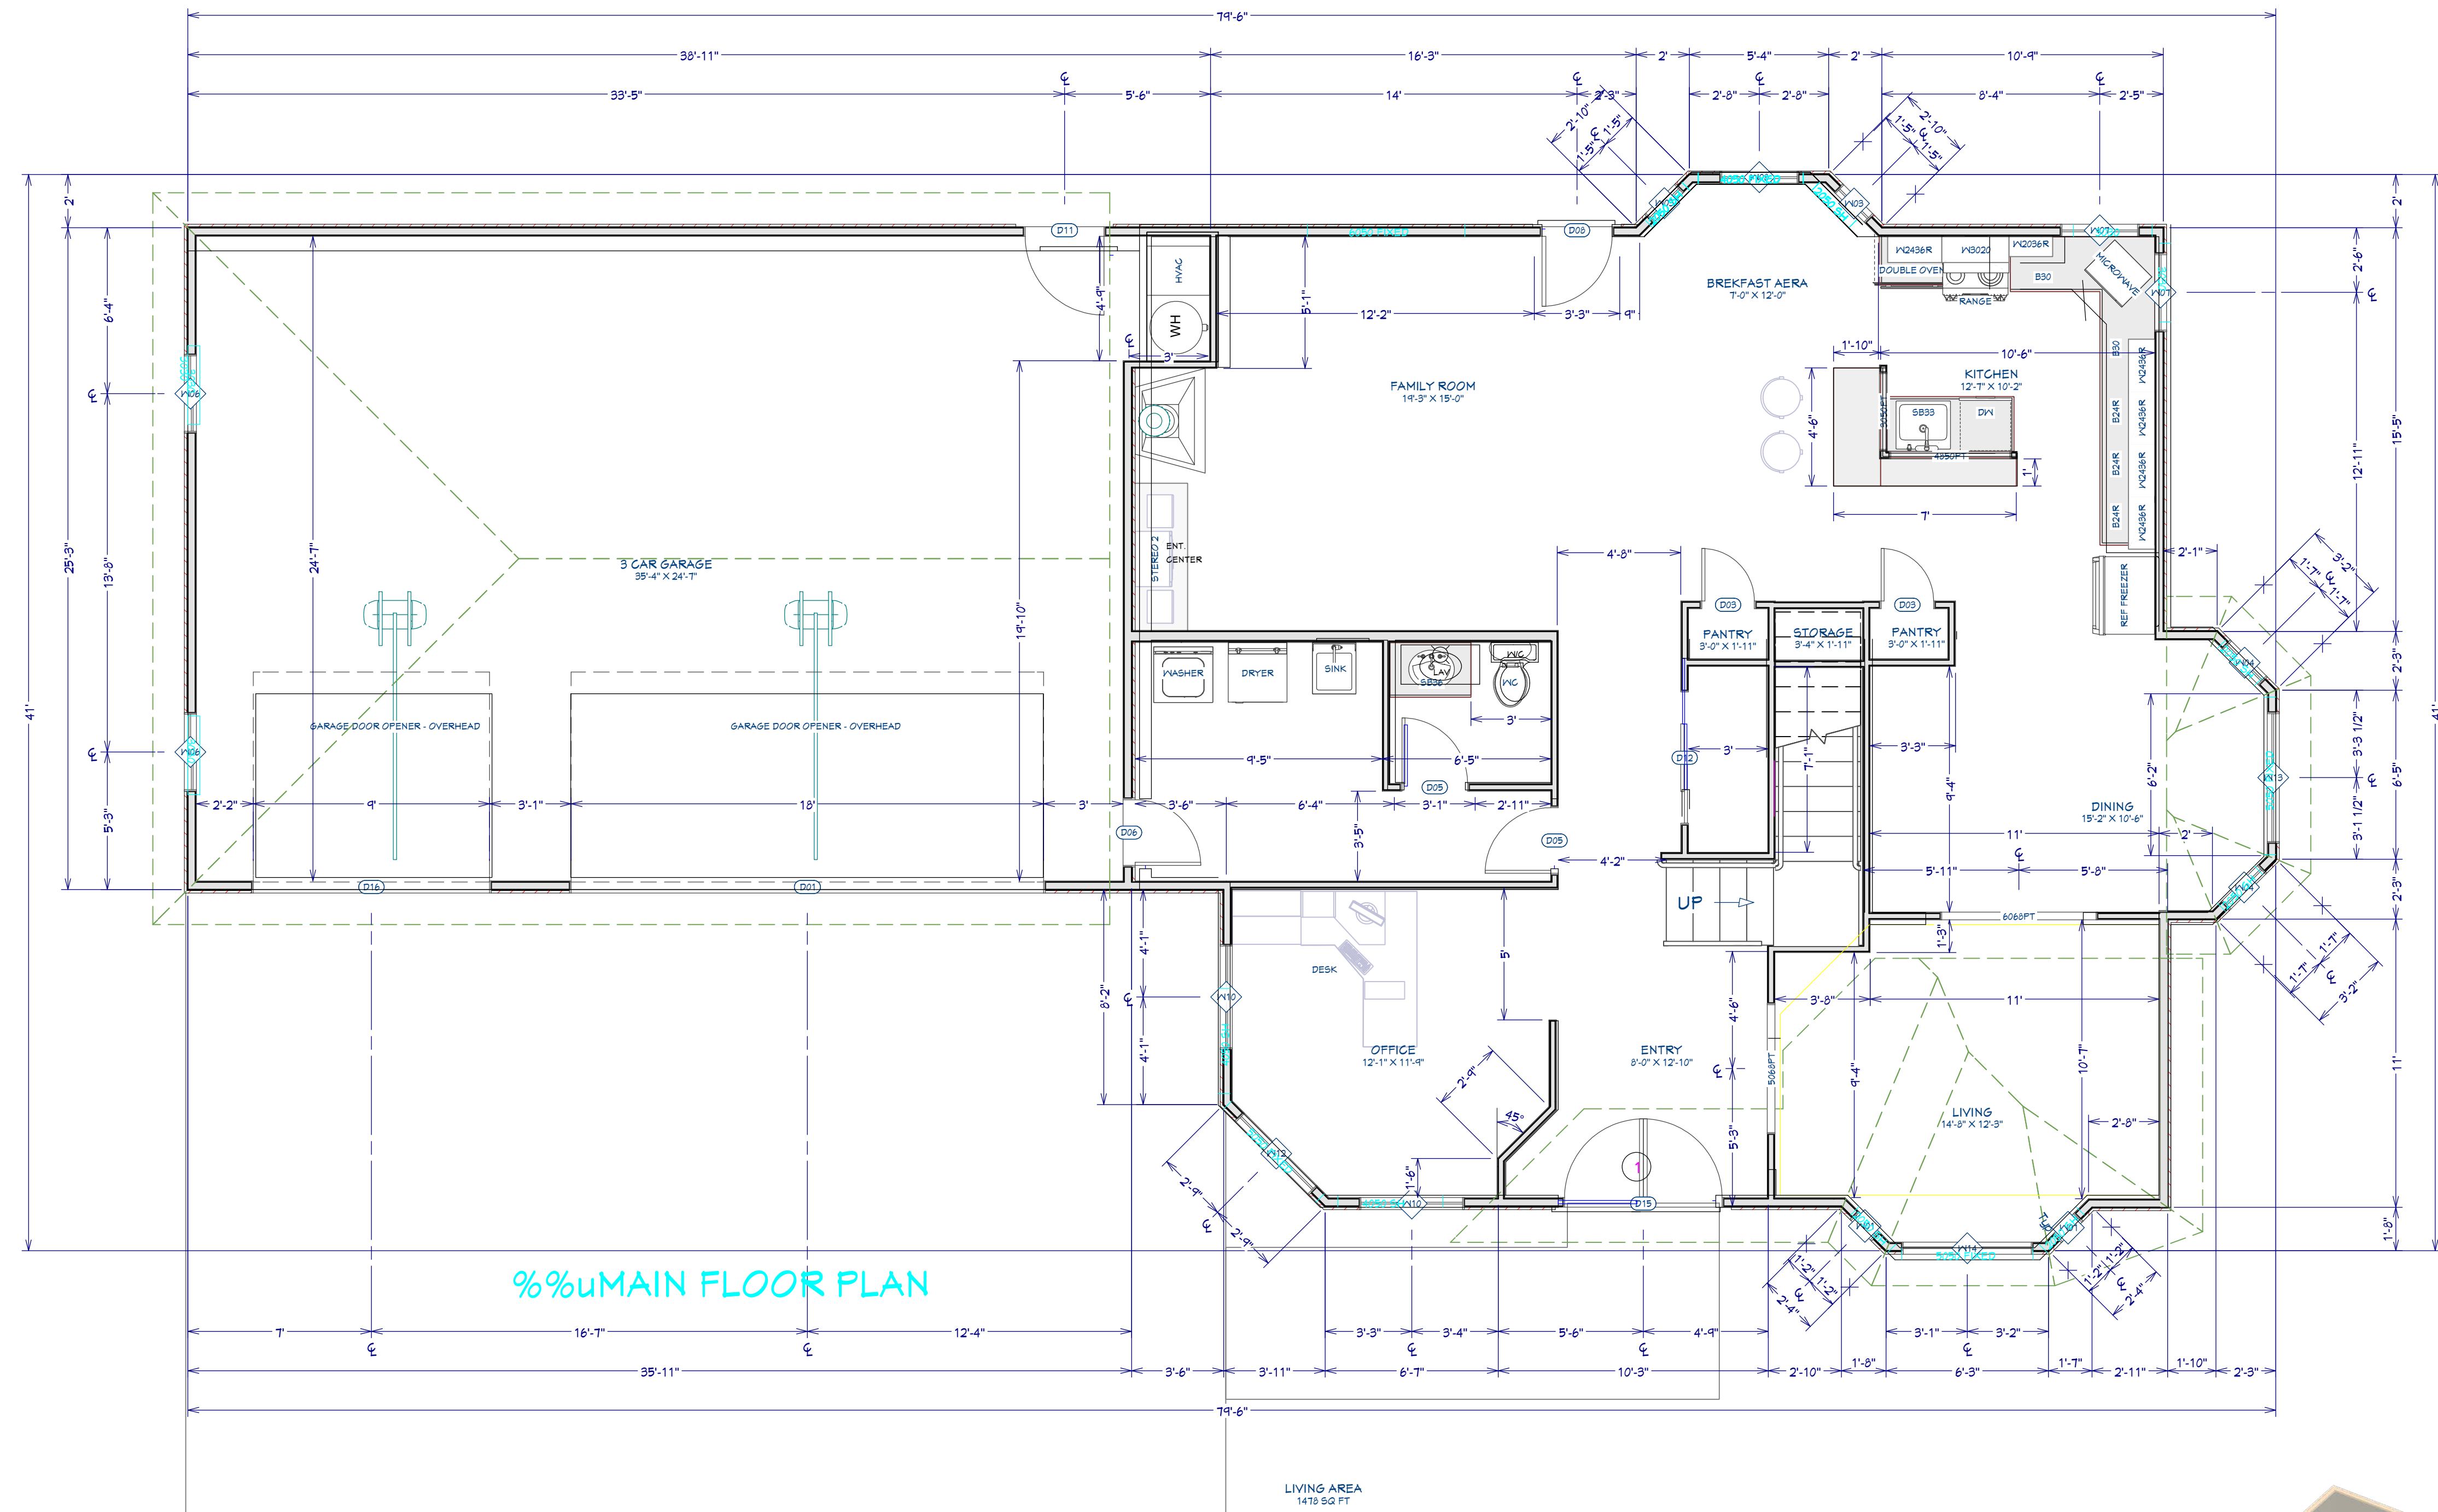

%%MAIN FLOOR PLAN

Main Floor Plan
Scale: 1/4" = 1'-0"

DOOR SCHEDULE									
NUMBER	LABEL	QTY	FLOOR	SIZE	R/O	DESCRIPTION	HEADER		FIRE
D01	13000	1	1	13000		210"X40"	GARAGE-ERP STYLELINE II T	2X12X24" (2)	
D02	1860	1	2	1860 R IN		22"X32 1/2"	HINGED-PANEL	2X6X25" (2)	
D03	2060	2	1	2060 L IN		26"X32 1/2"	HINGED-PANEL	2X6X24" (2)	
D04	2460	1	2	2460 L IN		32"X32 1/2"	HINGED-PANEL	2X6X35" (2)	
D05	2660	2	1	2660 L IN		32"X32 1/2"	HINGED-PANEL	2X6X35" (2)	
D06	2660	1	1	2660 R IN		32"X32 1/2"	HINGED-PANEL	2X6X35" (2)	
D07	2660	1	2	2660 R IN		32"X32 1/2"	HINGED-PANEL	2X6X35" (2)	
D08	2660	1	1	2660 R EX		34"X35"	EXT. HINGED-DOOR E02	4X8 11X31" (2)	
D09	2660	1	2	2660 L IN		34"X32 1/2"	HINGED-PANEL	2X6X31" (2)	
D10	2660	1	2	2660 R IN		34"X32 1/2"	HINGED-PANEL	2X6X31" (2)	
D11	5060	1	1	5060 L EX		50"X65"	EXT. HINGED-DOOR E01	4X8 12X41" (2)	
D12	5060	1	1	5060 R IN		62"X32 1/2"	SLIDER-DOOR F04	2X3X65" (2)	
D13	5060	2	2	5060 C-R IN		62"X32 1/2"	DOUBLE HINGED-PANEL	2X3X65" (2)	
D14	5060	2	2	5060 L IN		62"X32 1/2"	SLIDER-DOOR F01	2X3X65" (2)	
D15	6060	1	1	6060 C-LR EX		14"X35"	EXT. DOUBLE HINGED-DOOR E11	4X9 14X11" (2)	
D16	9060	1	1	9060		110"X94"	GARAGE-ERP STYLELINE II T	2X12X116" (2)	

WINDOW SCHEDULE									
NUMBER	LABEL	QTY	FLOOR	SIZE	R/O	DEGRESS	DESCRIPTION	HEADER	
W01	1250DH	2	1	1250DH			DOUBLE HUNG	2X6X19" (2)	
W02	1350RS	4	2	1350RS			RIGHT SLIDING	2X6X24" (2)	
W03	1350SH	2	1	1350SH			SINGLE HUNG	2X6X24" (2)	
W04	2050SH	2	1	2050SH		YES	SINGLE HUNG	2X6X25" (2)	
W05	3050FX	1	2	3050FX			FIXED GLASS	2X6X40" (2)	
W06	3050RS	2	1	3050RS			RIGHT SLIDING	2X6X40" (2)	
W07	3050SH	2	1	3050SH			SINGLE HUNG	2X6X40" (2)	
W08	3050SH	1	1	3050SH		YES	SINGLE HUNG	2X6X40" (2)	
W10	4050SH	12	1	4050SH			SINGLE HUNG	2X3X52" (2)	
W11	4050SH	5	2	4050SH		YES	SINGLE HUNG	2X3X52" (2)	
W12	4050FX	1	1	4050FX		YES	FIXED GLASS	2X3X52" (2)	
W13	5050FX	1	1	5050FX			FIXED GLASS	2X3X64" (2)	
W14	5050SH	1	1	5050SH		YES	SINGLE HUNG	2X3X64" (2)	
W15	4040SH	2	2	4040SH		YES	SINGLE HUNG	2X3X52" (2)	

REVISION TABLE		REVISION BY	DESCRIPTION
NUMBER	DATE		

Main Floor Plan

DRAWINGS PROVIDED BY:

BC

DATE:


10/3/2025


SCALE:

as shown

SHEET:


P-2

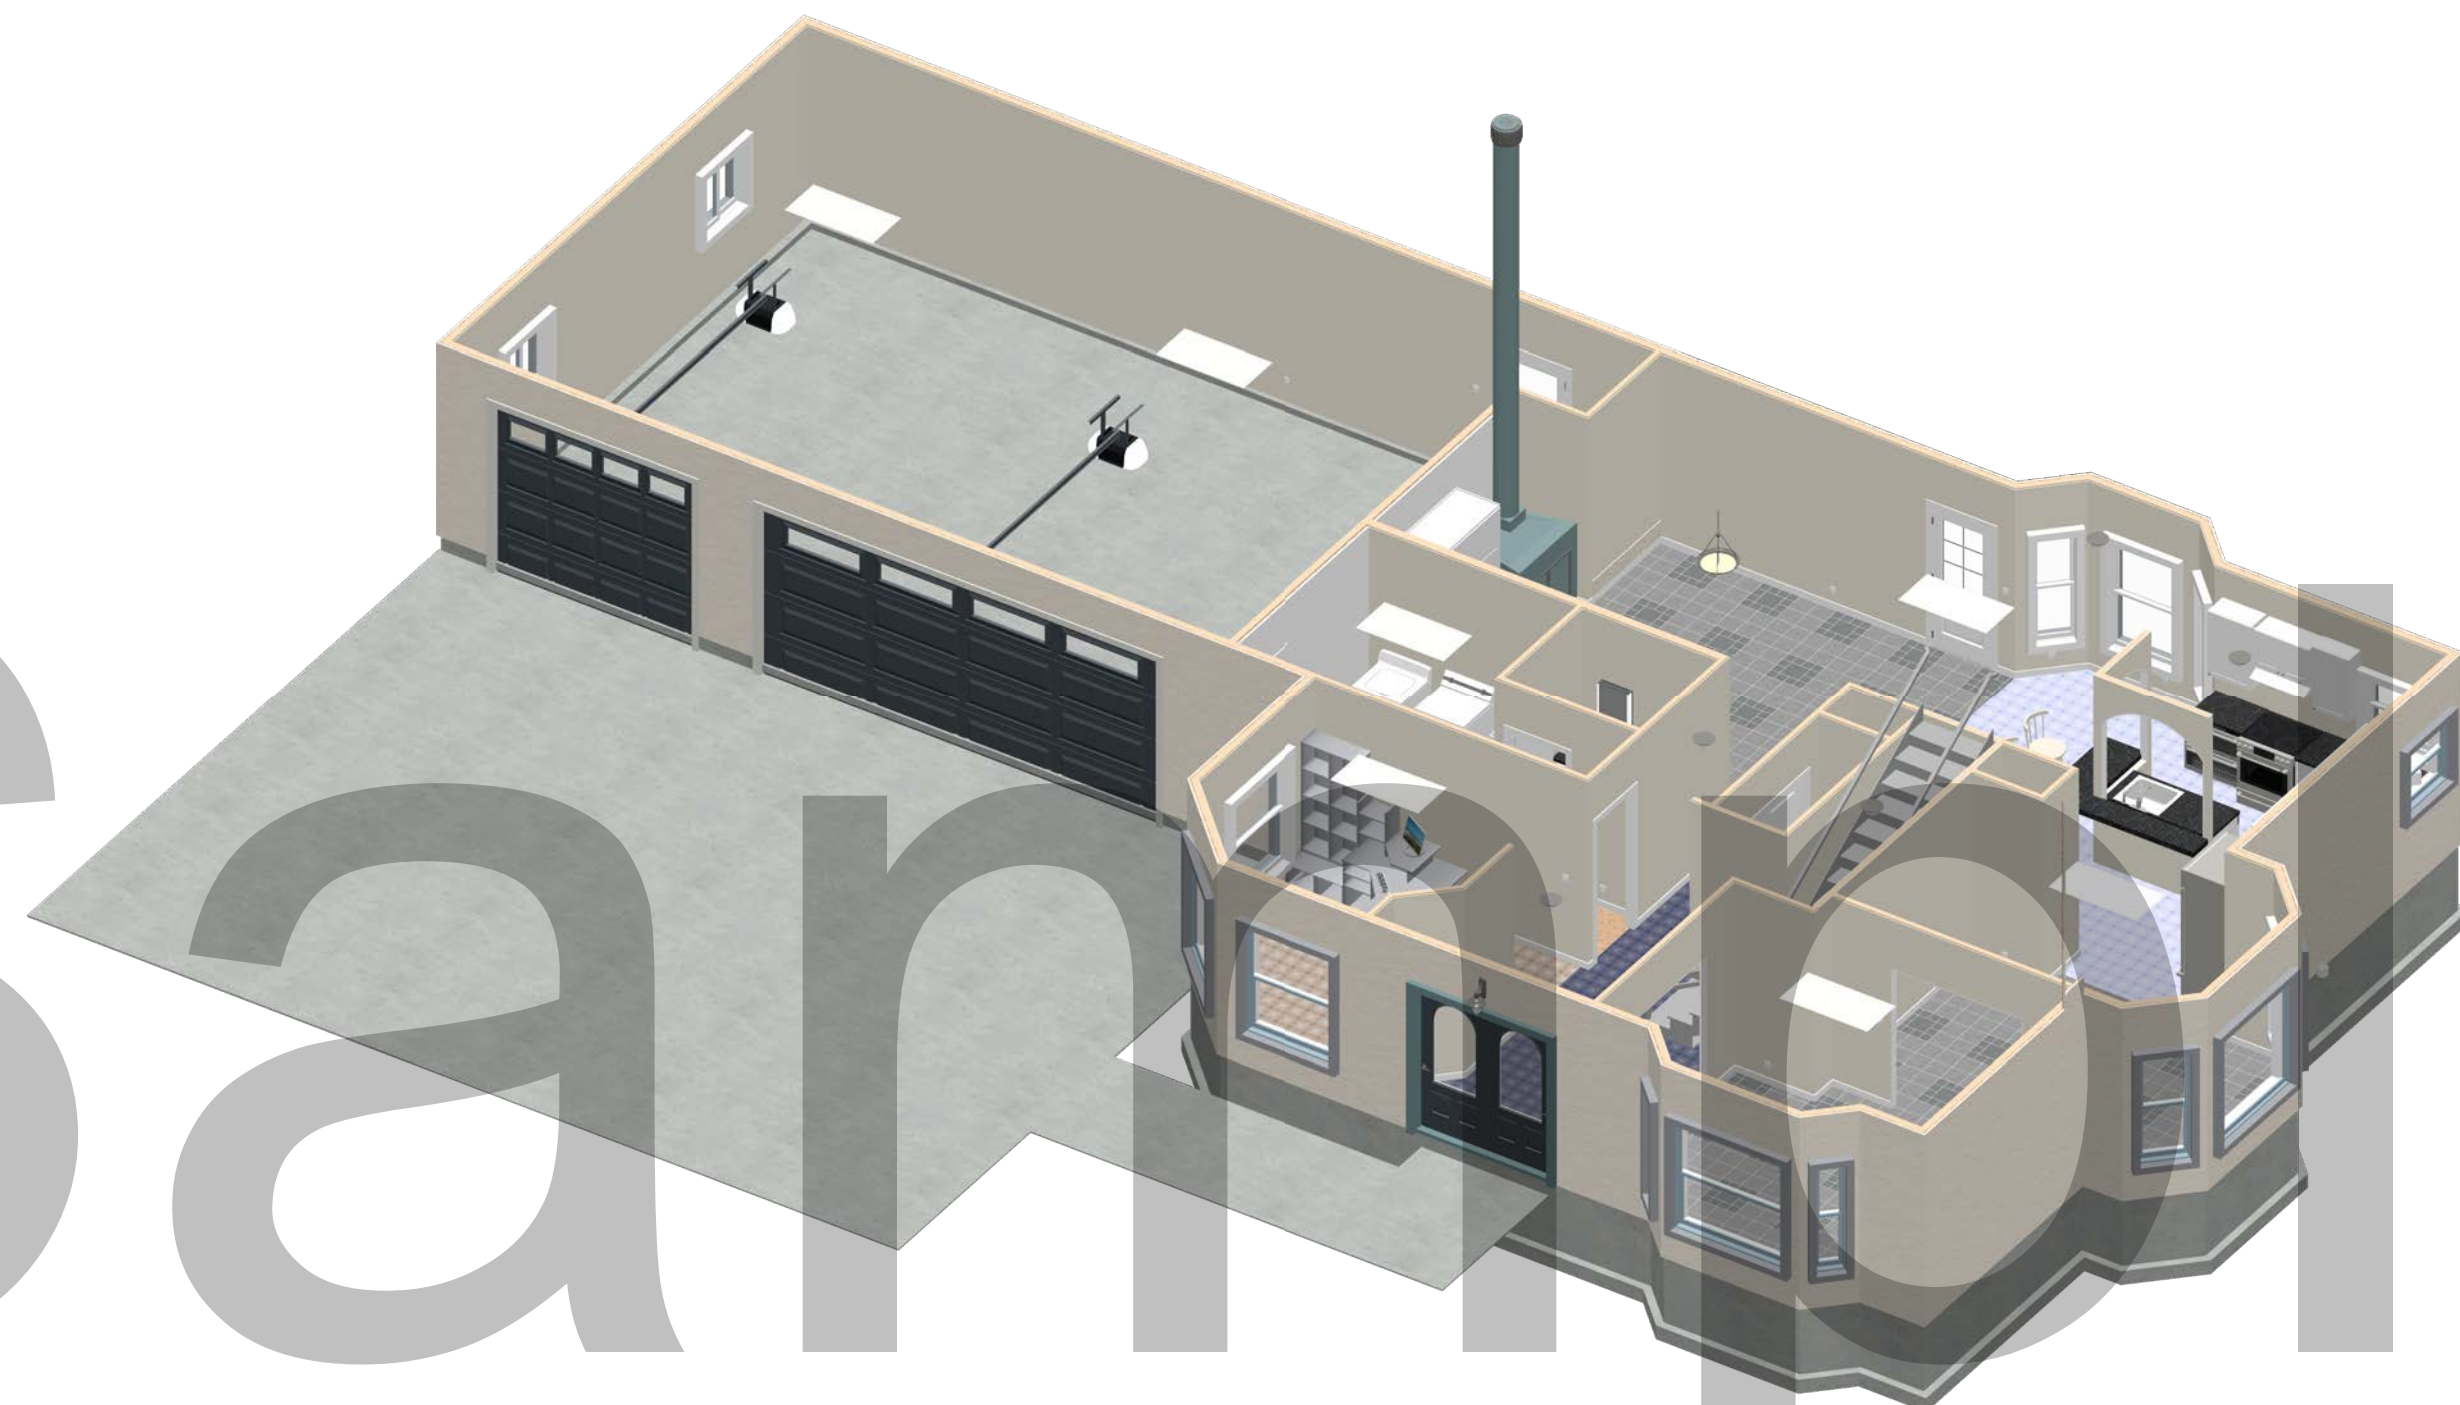

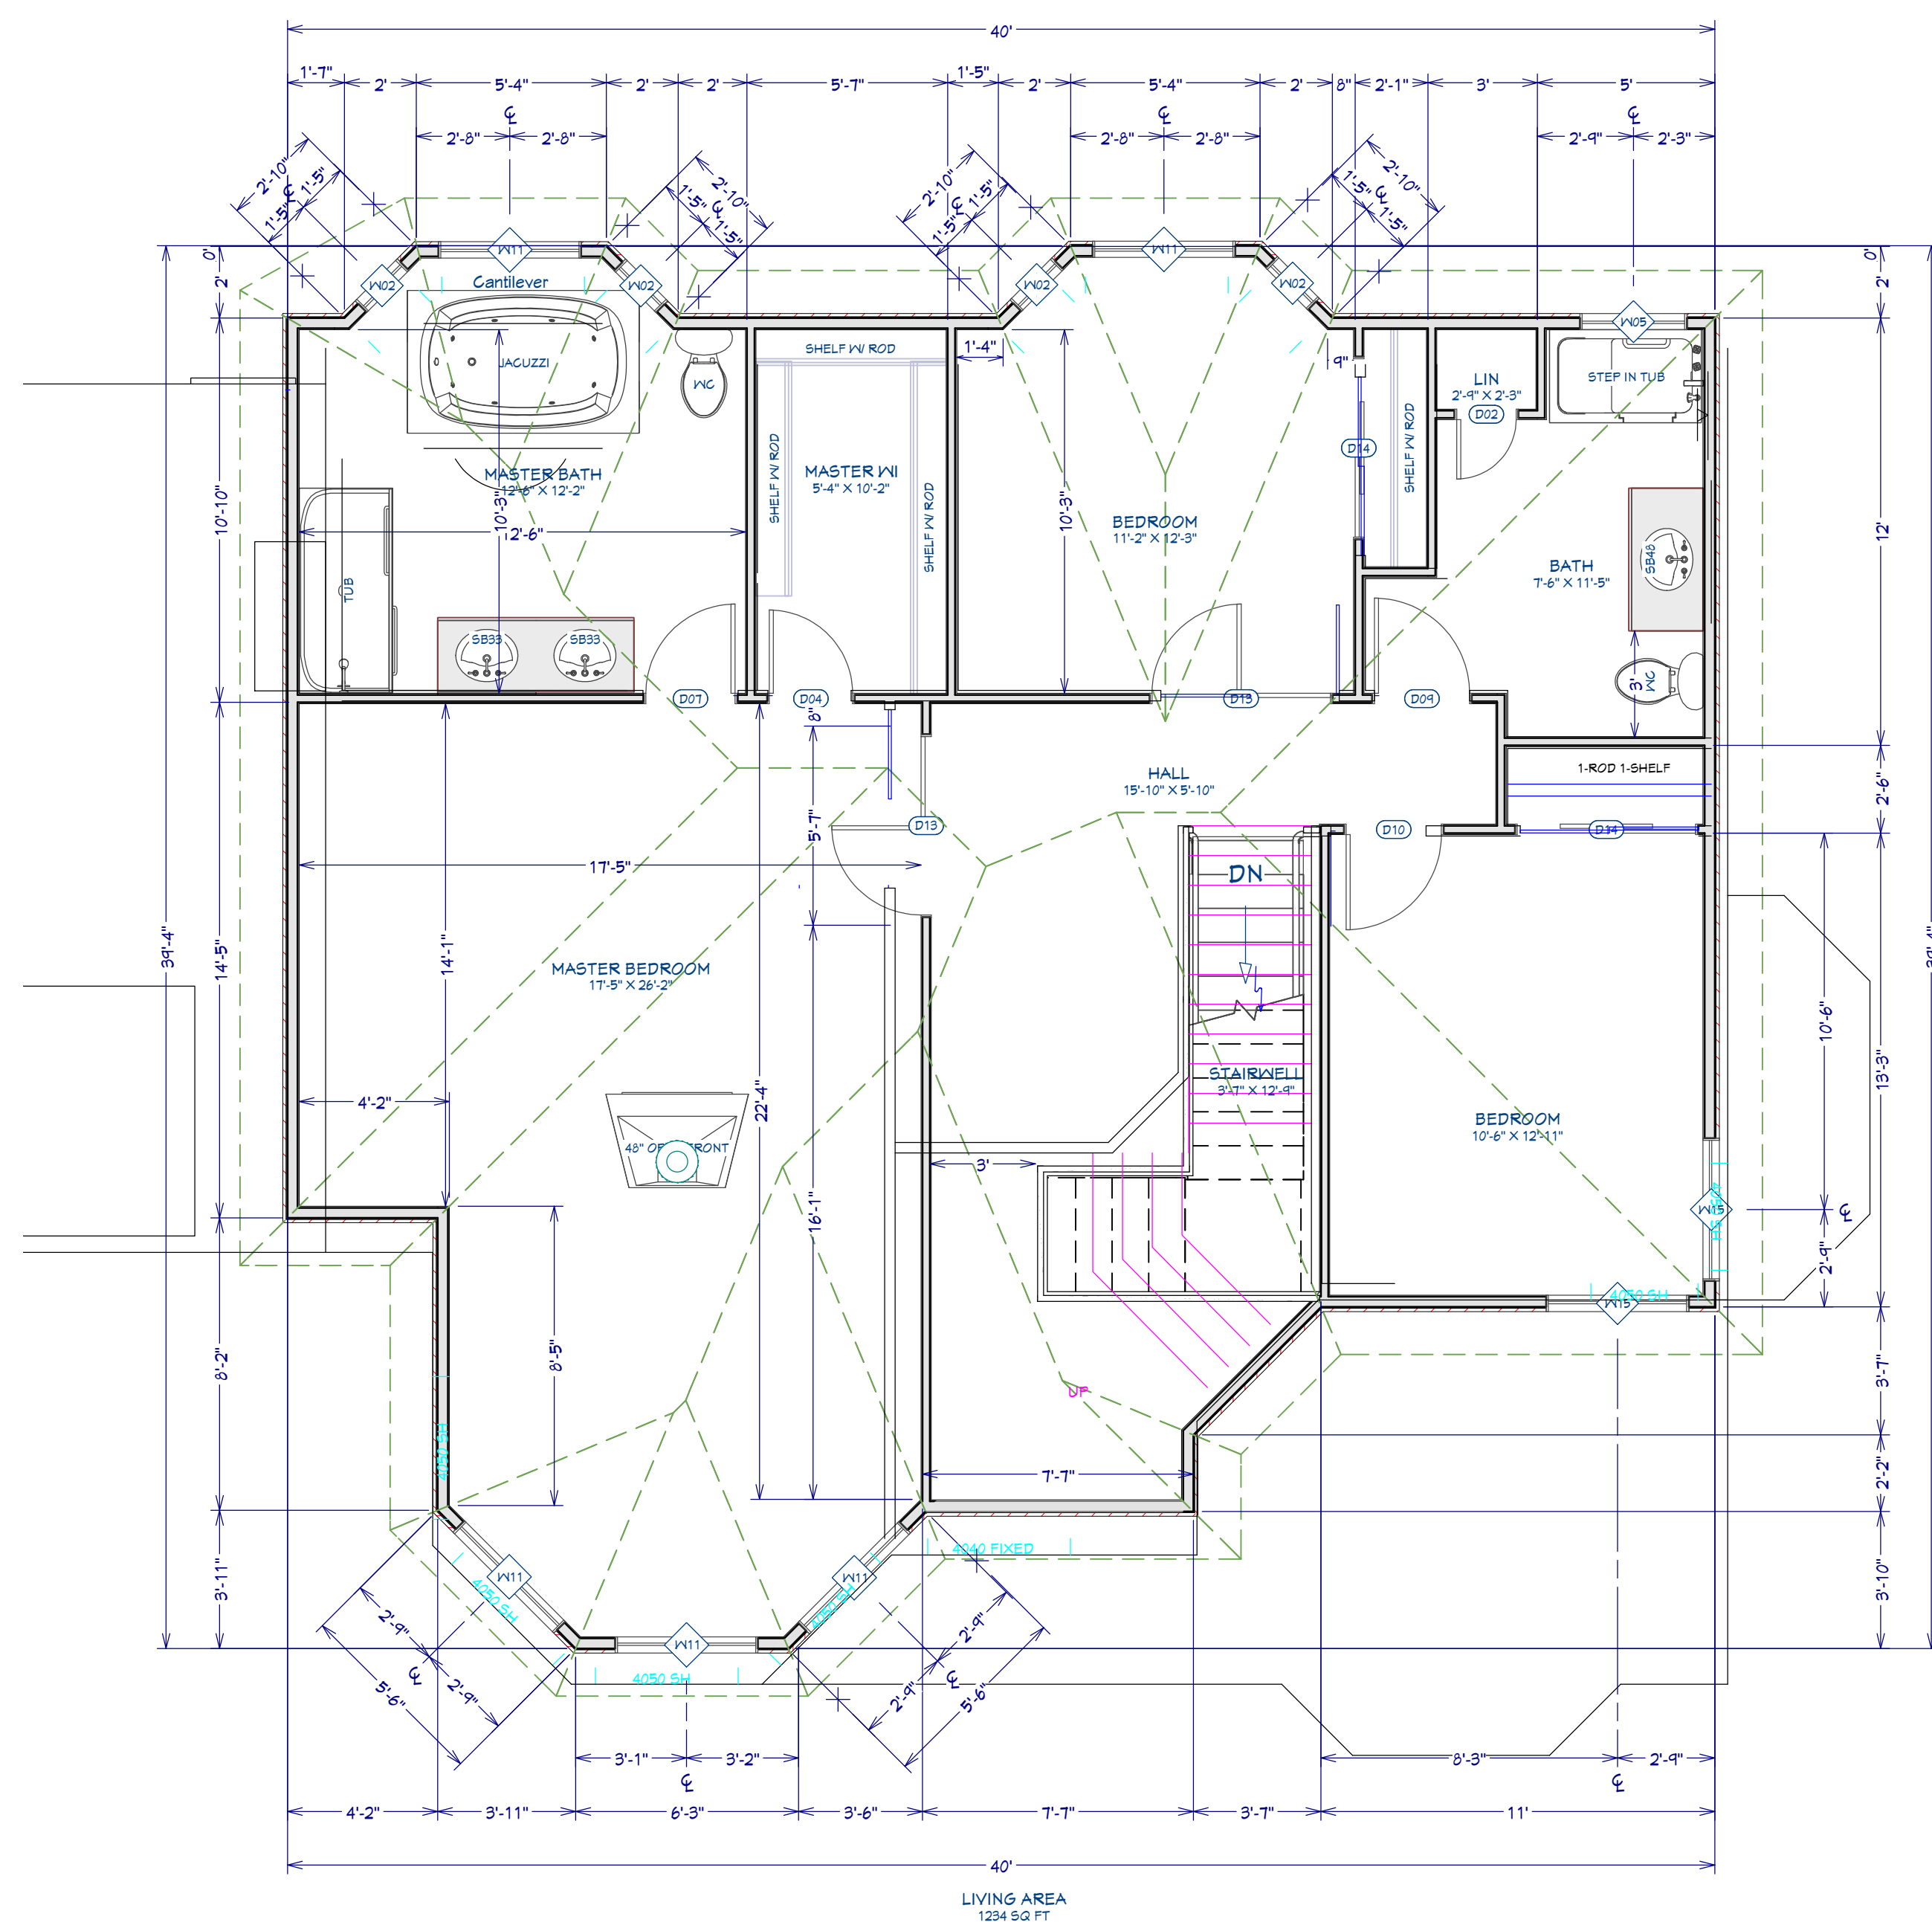

NUMBER		LAB	QTY	FLGR	SIZE	DOOR SCHEDULE		HEADER	FI
						R/O	DESCRIPTION		
D01	12029	1	1	1800		218 X34"	GARAGE-ERP STAYLINE II T	218X242X4"	(2)
D02	12030	1	1	1800	R IN	218 X34"	GARAGE-ERP STAYLINE II T	218X242X4"	(2)
D03	22620	2	1	2060	L IN	304 X172"	HINGED-PANEL	206X172"	(2)
D04	22621	2	1	2060	L IN	304 X172"	HINGED-PANEL	206X172"	(2)
D05	22622	2	1	2060	L IN	304 X172"	HINGED-PANEL	206X172"	(2)
D06	22623	2	1	2060	L IN	304 X172"	HINGED-PANEL	206X172"	(2)
D07	22624	1	1	2060	R IN	304 X172"	HINGED-PANEL	206X172"	(2)
D08	22625	1	1	2060	R IN	304 X172"	HINGED-PANEL	206X172"	(2)
D09	22626	1	1	2260	R EX	34 X35"	EXT HINGED-DOOR E02	226X35"	(2)
D10	22627	1	2	2260	L IN	34 X172"	HINGED-PANEL	4X35"	(2)
D11	30063	1	1	3060	L EX	303 X35"	EXT HINGED-DOOR E01	4X35"	(2)
D12	50063	1	1	5060	R IN	62 X172"	SLIDER-DOOR R04	206X172"	(2)
D13	50064	2	1	5060	L IN	62 X172"	SLIDER-DOOR R04	206X172"	(2)
D14	50062	2	1	5060	L IN	62 X172"	SLIDER-DOOR R04	206X172"	(2)
D15	60063	1	2	6060	C/L R EX	74 X35"	EXT DOUBLE HINGED-DOOR E11	4X35"	(2)
D16	60064	1	2	6060	C/L R EX	74 X35"	EXT DOUBLE HINGED-DOOR E11	4X35"	(2)

WINDOW SCHEDULE							
NUMBER	LABEL	QTY	FLOOR	SIZE	R/O	EGRESS	DESCRIPTION
XW01	1250D10	1	1	1250D10	15'x6"1		DOUBLE HUNG 26X613'1
XW02	150RSR5	4	1	150RSR5	21'x6"1		RIGHT SLIDING 26X24"2
XW03	2050GH	1	1	2050GH	26'x6"1		SINGLE HUNG 26X613'1
XW04	2050S10	1	1	2050S10	26'x6"1	YES	SINGLE HUNG 26X613'1
XW05	3000FPX	1	2	3000FPX	37'x3"1		FIXED GLASS 26X46"0
XW06	3000RS	2	1	3000RS	37'x3"1		RIGHT SLIDING 26X46"0
XW07	3000GH	1	1	3000GH	37'x3"1		SINGLE HUNG 26X46"0
XW08	3000S10	1	1	3000S10	37'x3"1	YES	SINGLE HUNG 26X46"0
XW10	4000S10	2	1	4000S10	44'x6"1		SINGLE HUNG 26X52"2
XW11	4000GH	1	1	4000GH	44'x6"1		SINGLE HUNG 26X52"2
XW12	4000FPX	1	1	4000FPX	44'x6"1	YES	FIXED GLASS 26X52"2
XW13	5000FPX	1	1	5000FPX	61'x6"1		FIXED GLASS 26X64"4
XW14	5000GH	1	1	5000GH	61'x6"1	YES	SINGLE HUNG 26X64"4
XW15	5000S10	2	1	5000S10	61'x6"1	YES	SINGLE HUNG 26X64"4

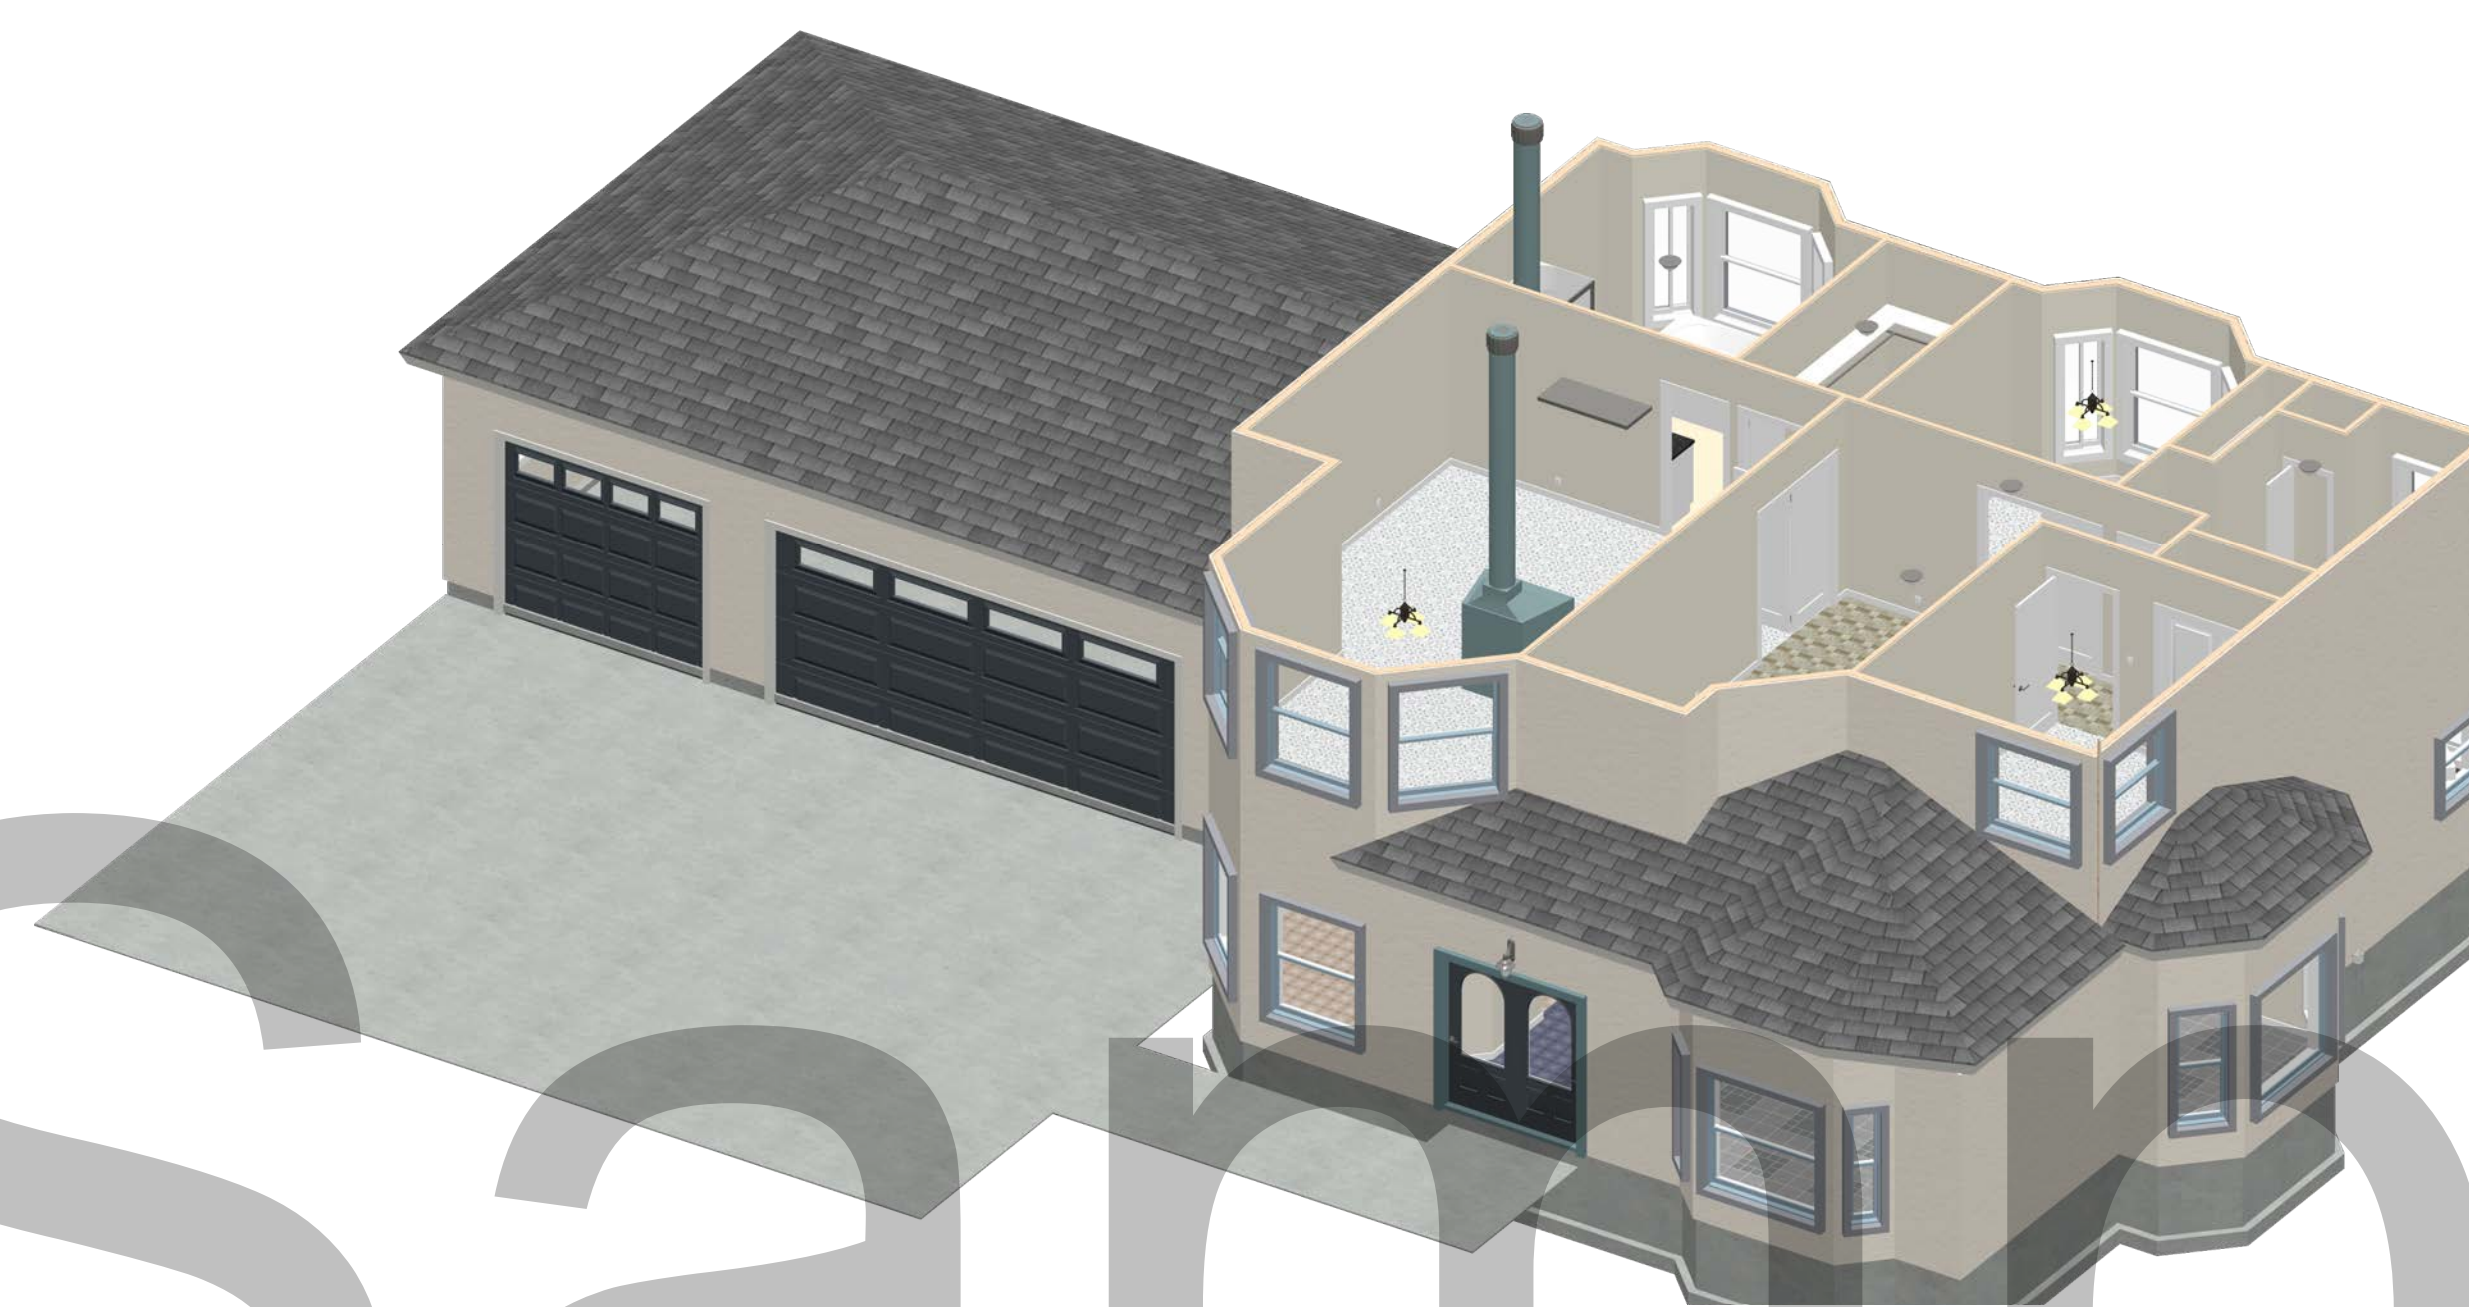[illegible]

Second Floor Plan

DRAWINGS PROVIDED BY:

BC

DATE:



10/3/2025

SCALE:


as shown

SHEET:

P-3

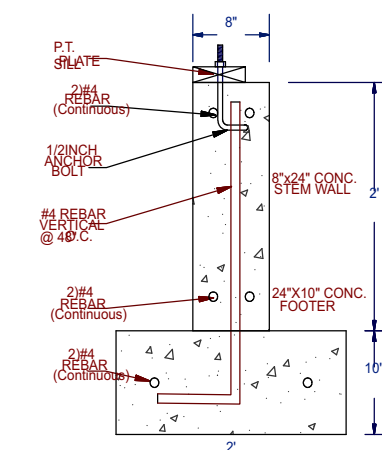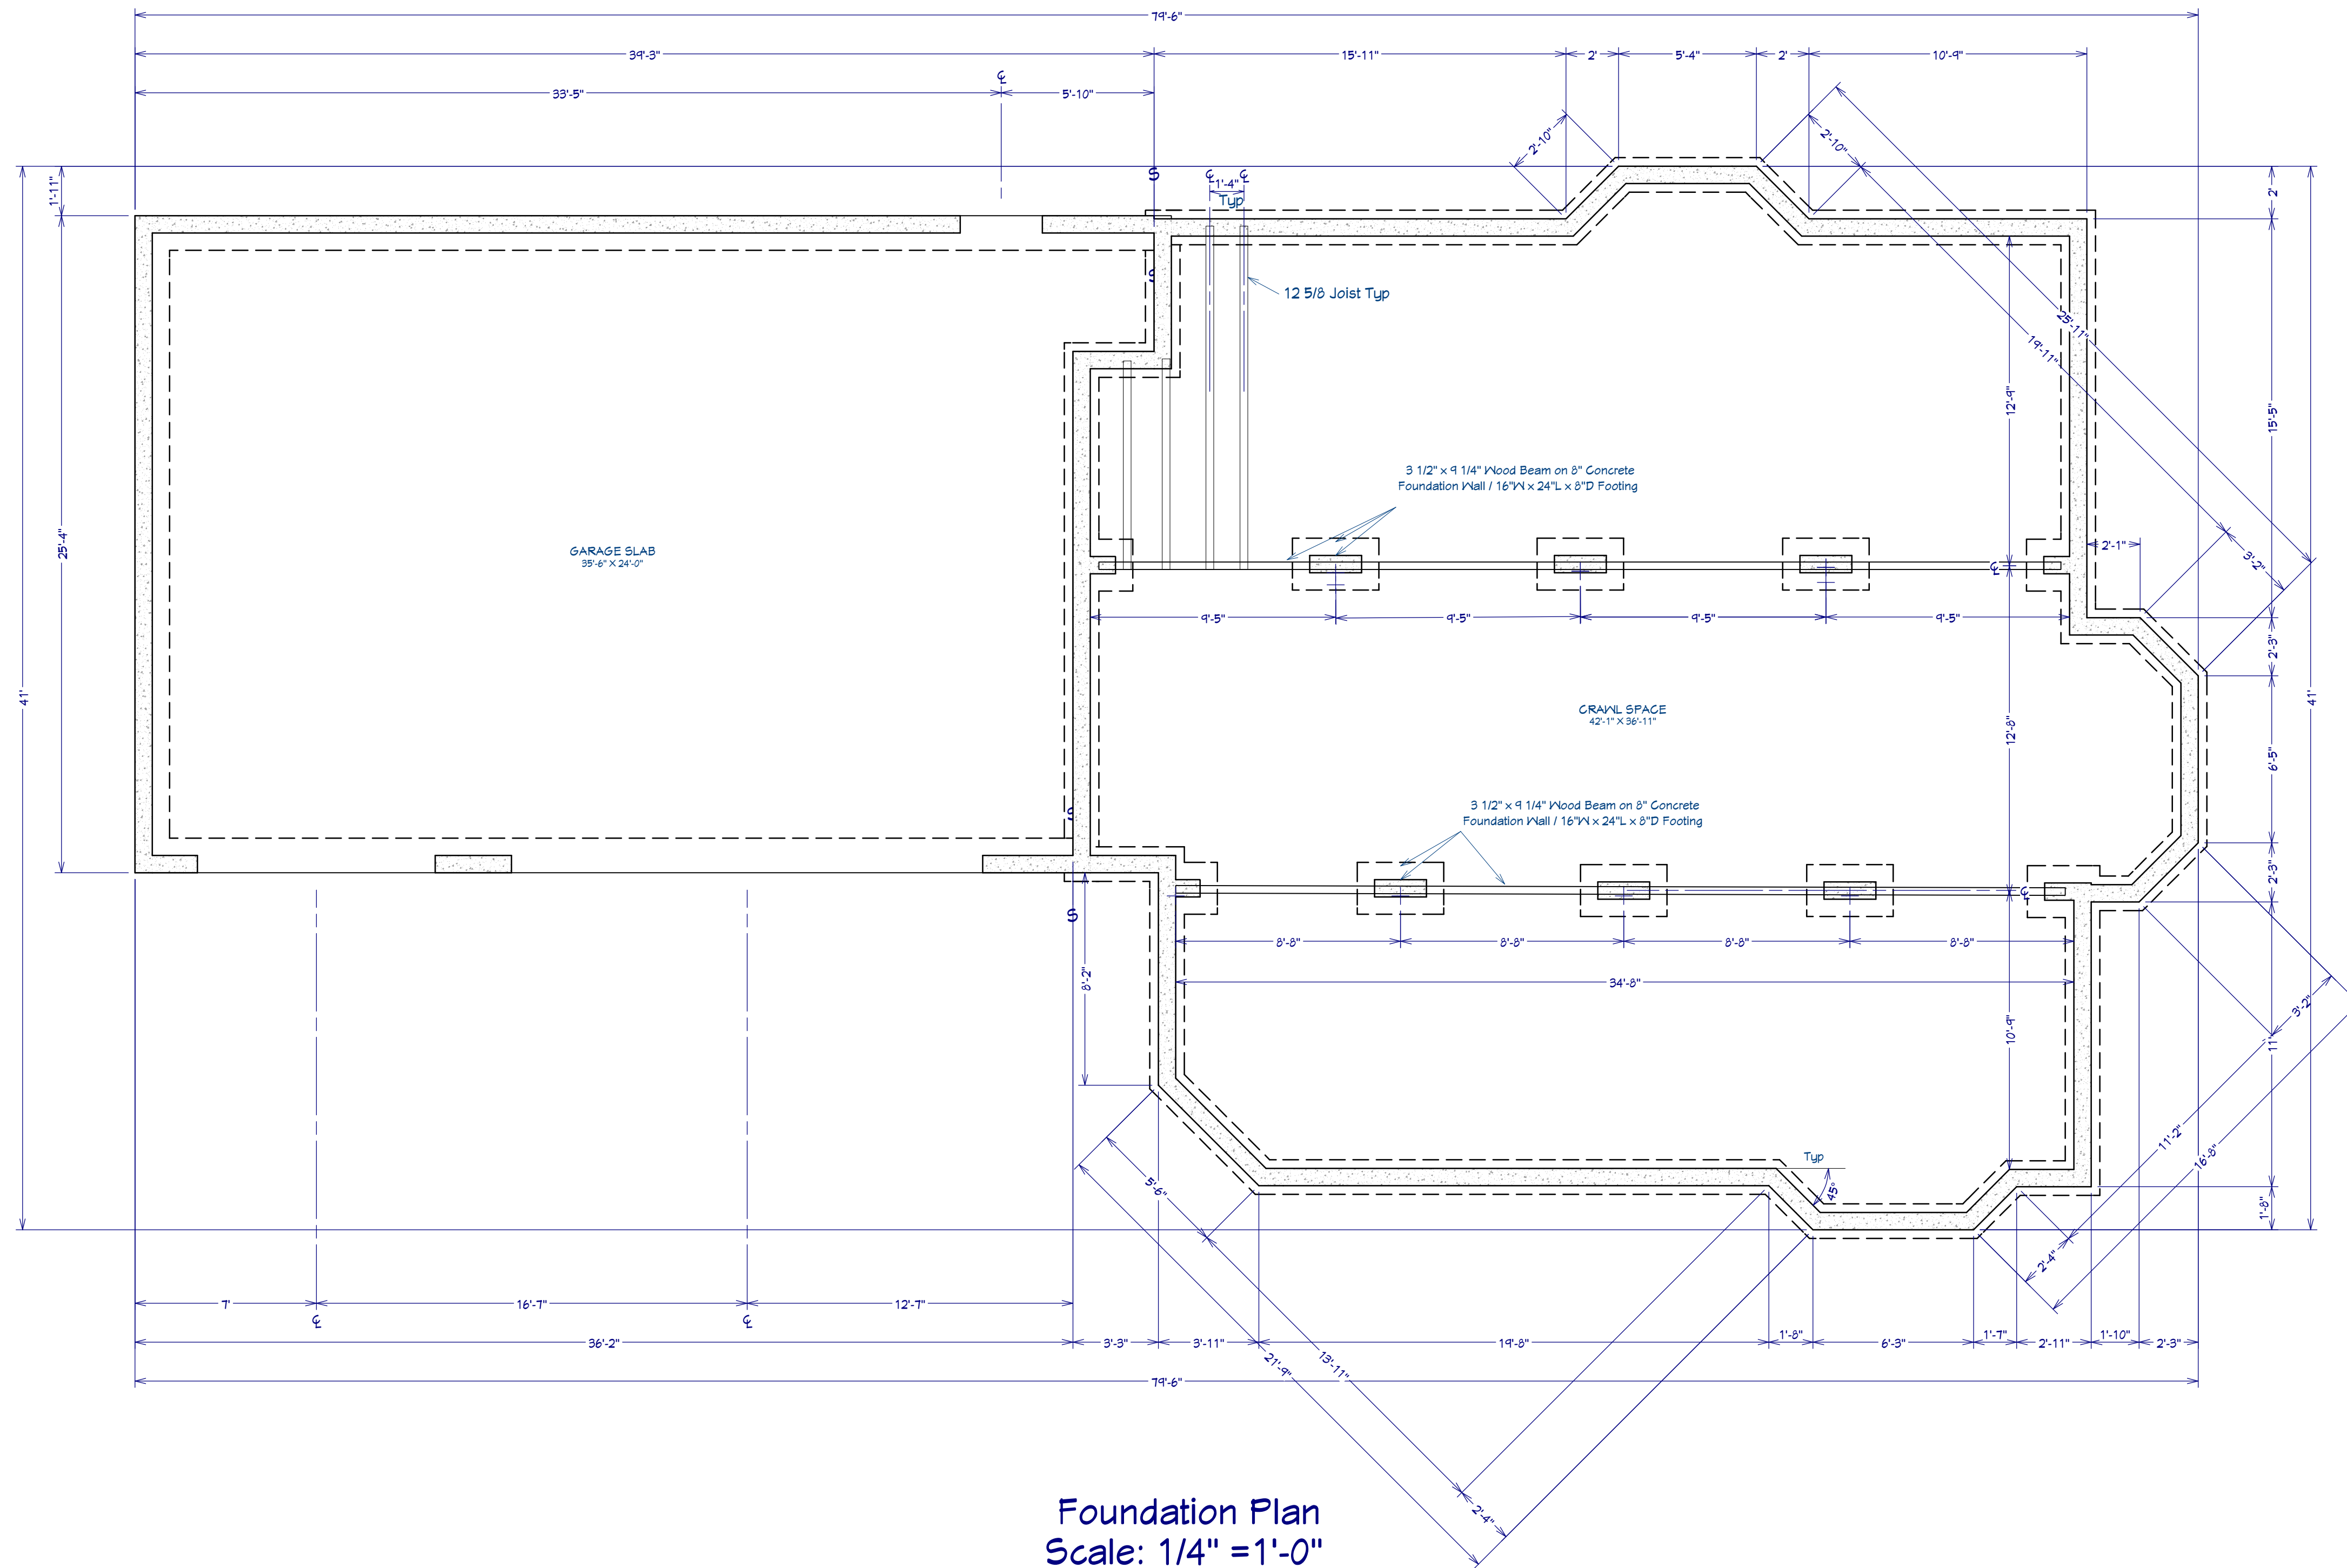

NOTE:
ALL REBAR PER LOCAL CODE
AND/OR ENGINEER'S DESIGN

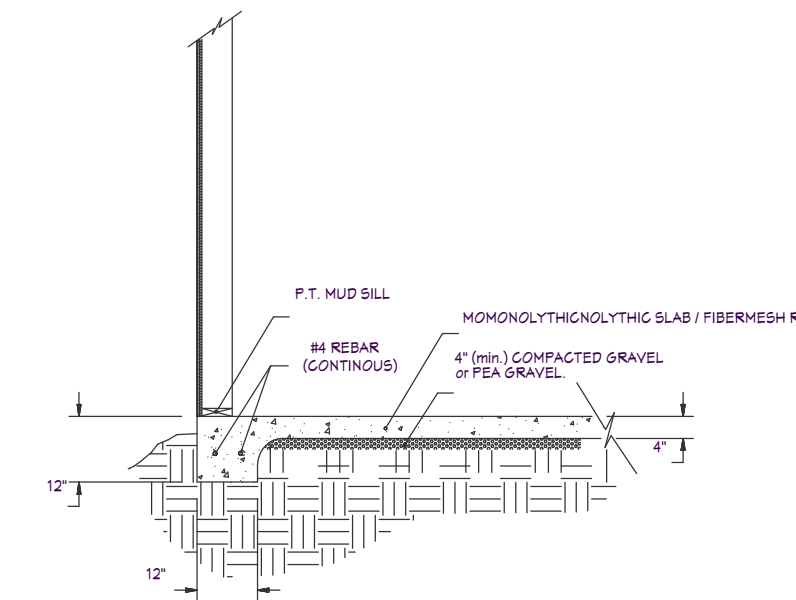

NOTE:
ALL REBAR PER LOCAL CODE
AND/OR ENGINEER'S DESIGN

REVISION TABLE		DESCRIPTION
NUMBER	DATE	REVISION BY

Foundation Plan

DRAWINGS PROVIDED BY:
BC

DATE:

10/3/2025

SCALE:

as shown

SHEET:

P-4



Exterior Elevation Front
Scale: 3/16" = 1'-0"

NUMBER		LABEL		QTY		FLOOR		SIZE		R/O		DESCRIPTION		HEADER		FIRE	
D01	18000	1	1	18000				210"x94"				GARAGE-ERP STYLELINE II T		2X12X22X4"	(2)		
D02	1860	1	2	1860	R IN			22"x62 1/2"				HINGED-PANEL		2X6X25"	(2)		
D03	2060	2	1	2060	L IN			26"x62 1/2"				HINGED-PANEL		2X6X35"	(2)		
D04	2460	1	2	2460	L IN			30"x62 1/2"				HINGED-PANEL		2X6X35"	(2)		
D05	2660	2	1	2660	L IN			32"x62 1/2"				HINGED-PANEL		2X6X35"	(2)		
D06	2660	1	1	2660	R IN			32"x62 1/2"				HINGED-PANEL		2X6X35"	(2)		
D07	2660	1	2	2660	R IN			32"x62 1/2"				HINGED-PANEL		2X6X35"	(2)		
D08	2660	1	1	2660	R EX			34"x63"				EXT. HINGED-DOOR E02		4X8 1/2X37"	(2)		
D09	2660	1	2	2660	L IN			34"x62 1/2"				HINGED-PANEL		2X6X37"	(2)		
D10	2660	1	2	2660	R IN			34"x62 1/2"				HINGED-PANEL		2X6X37"	(2)		
D11	3060	1	1	3060	L EX			36"x63"				EXT. HINGED-DOOR E01		4X8 1/2X41"	(2)		
D12	3060	1	1	3060	R IN			34"x62 1/2"				HINGED-PANEL		2X6X37"	(2)		
D13	5060	2	2	5060	C-R IN			62"x62 1/2"				DOUBLE HINGED-PANEL		2X6X65"	(2)		
D14	5060	2	2	5060	L IN			62"x62 1/2"				SLIDER-DOOR F04		2X6X65"	(2)		
D15	6060	1	1	6060	C-L/R EX			74"x63"				EXT. DOUBLE HINGED-DOOR E11		4X8 14X11"	(2)		
D16	6060	1	1	6060				110"x94"				GARAGE-ERP STYLELINE II T		2X12X116"	(2)		


NUMBER		LABEL		QTY		FLOOR		SIZE		R/O		DESCRIPTION		HEADER	
JN01	1250DH	2	1	1250DH				19"x61"				DOUBLE HUNG		2X6X18"	(2)
JN02	1950RS	4	2	1950RS				21"x61"				RIGHT SLIDING		2X6X24"	(2)
JN03	1850SH	2	1	1850SH				21"x61"				SINGLE HUNG		2X6X24"	(2)
JN04	2050SH	2	1	2050SH				25"x61"		YES		SINGLE HUNG		2X6X28"	(2)
JN05	3030FX	1	2	3030FX				31"x37"				FIXED GLASS		2X6X40"	(2)
JN06	3030RS	2	1	3030RS				31"x37"				RIGHT SLIDING		2X6X40"	(2)
JN07	3030SH	2	1	3030SH				31"x37"				SINGLE HUNG		2X6X40"	(2)
JN08	3050SH	1	1	3050SH				37"x61"		YES		SINGLE HUNG		2X6X40"	(2)
JN09	4050SH	2	1	4050SH				44"x61"		YES		SINGLE HUNG		2X6X52"	(2)
JN10	4050SH	2	1	4050SH				44"x61"		YES		SINGLE HUNG		2X6X52"	(2)
JN11	4050SH	5	2	4050SH				44"x61"		YES		SINGLE HUNG		2X6X52"	(2)
JN12	4050FX	1	1	4050FX				44"x61"		YES		FIXED GLASS		2X6X52"	(2)
JN13	5050FX	1	1	5050FX				61"x61"		YES		FIXED GLASS		2X6X64"	(2)
JN14	5050SH	1	1	5050SH				61"x61"		YES		SINGLE HUNG		2X6X64"	(2)
JN15	4040SH	2	2	4040SH				44"x44"		YES		SINGLE HUNG		2X6X52"	(2)



Exterior Elevation Back
Scale: 3/16" = 1'-0"



Exterior Elevation Left
Scale: 3/16" = 1'-0"

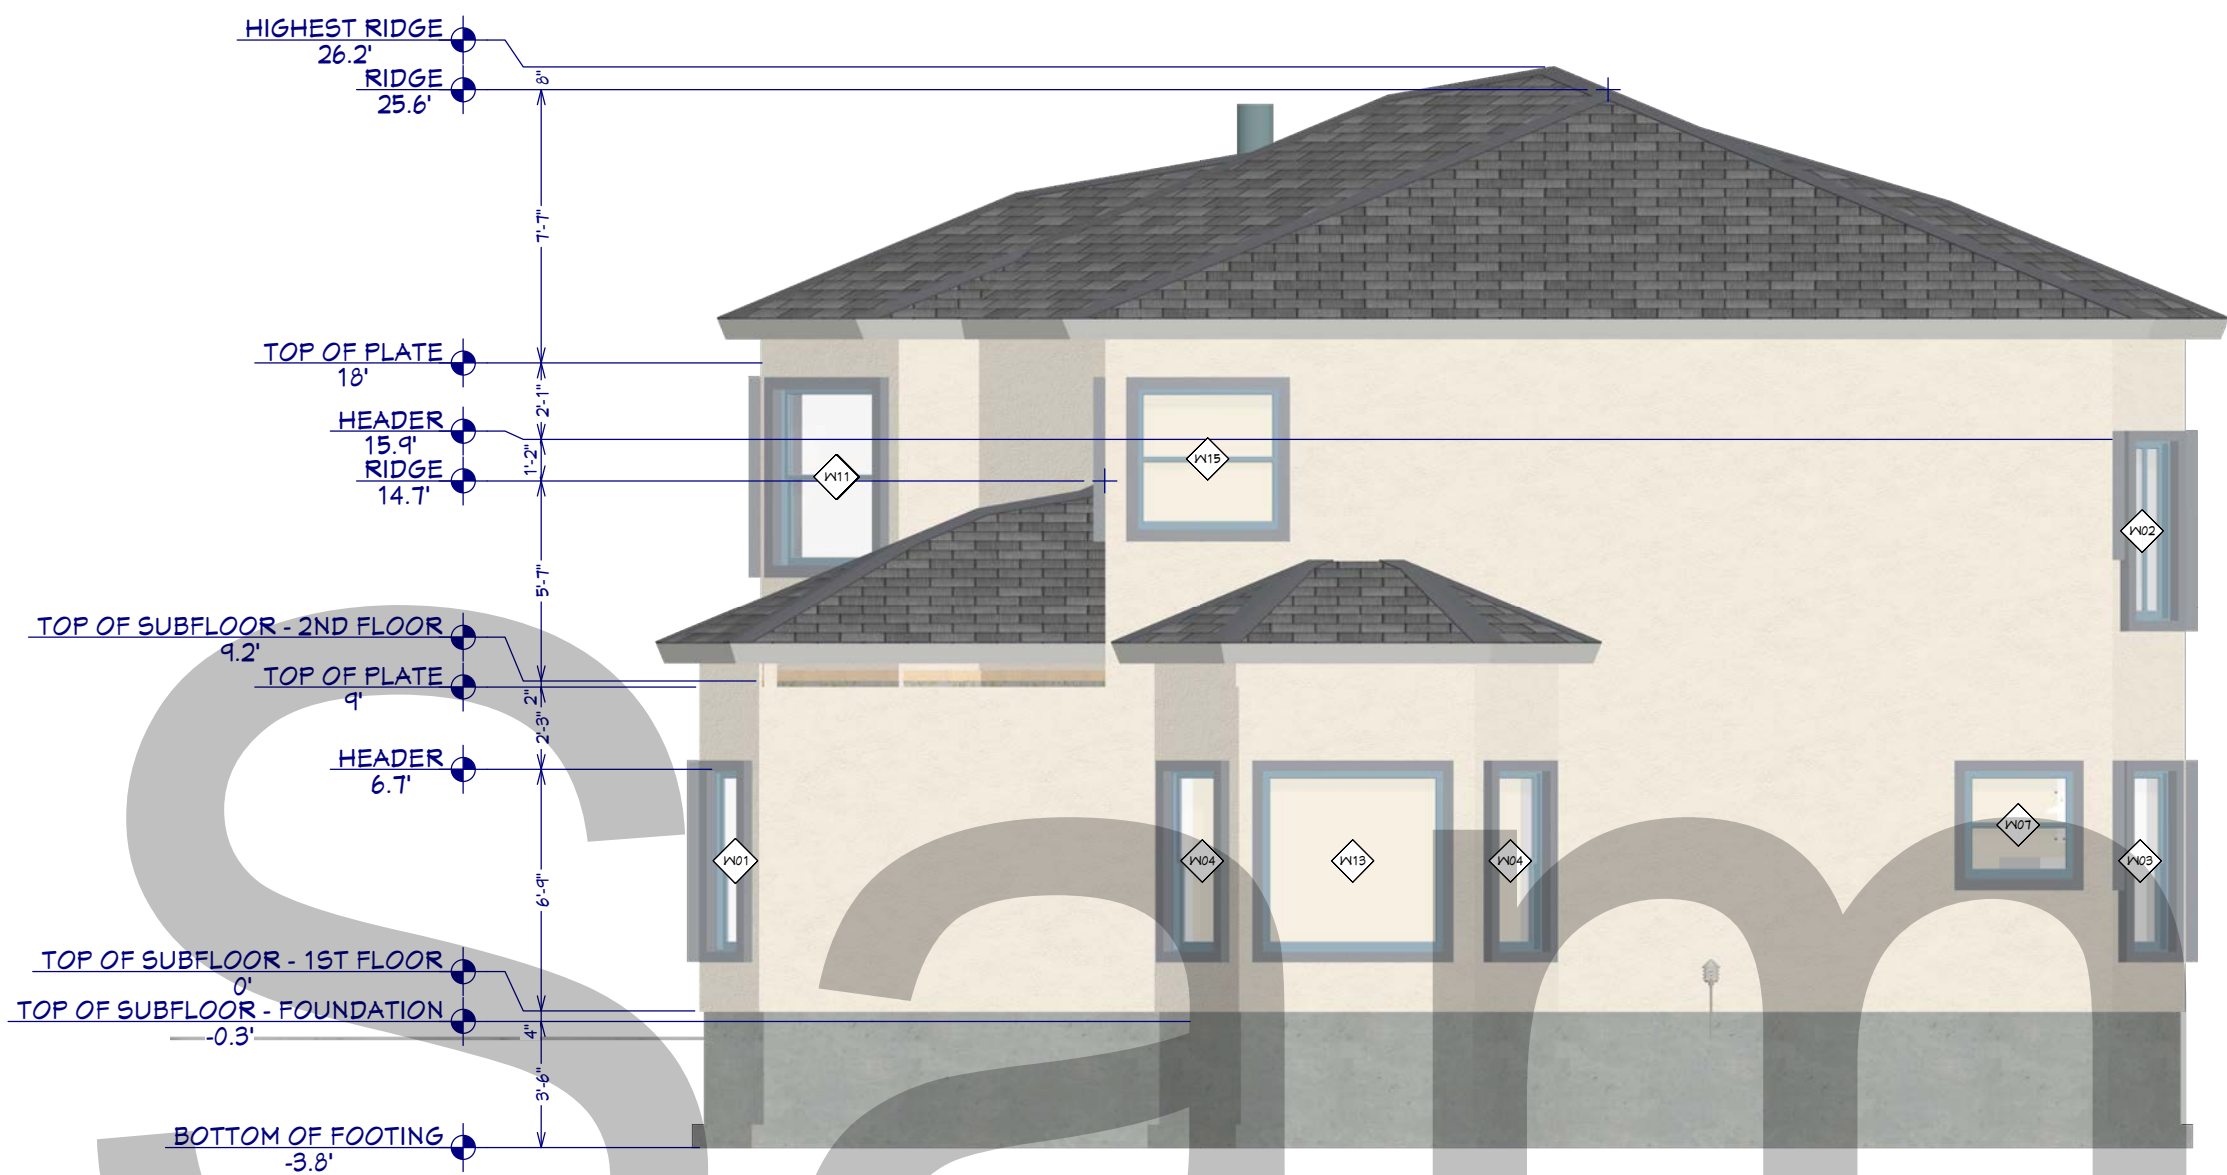


Exterior Elevation Right
Scale: 3/16" = 1'-0"

REVISION TABLE		REVISION BY		DESCRIPTION	
NUMBER	DATE				

Exterior Elevations


DRAWINGS PROVIDED BY:
BC

DATE:
10/3/2025
SCALE:
as shown
SHEET:
P-5

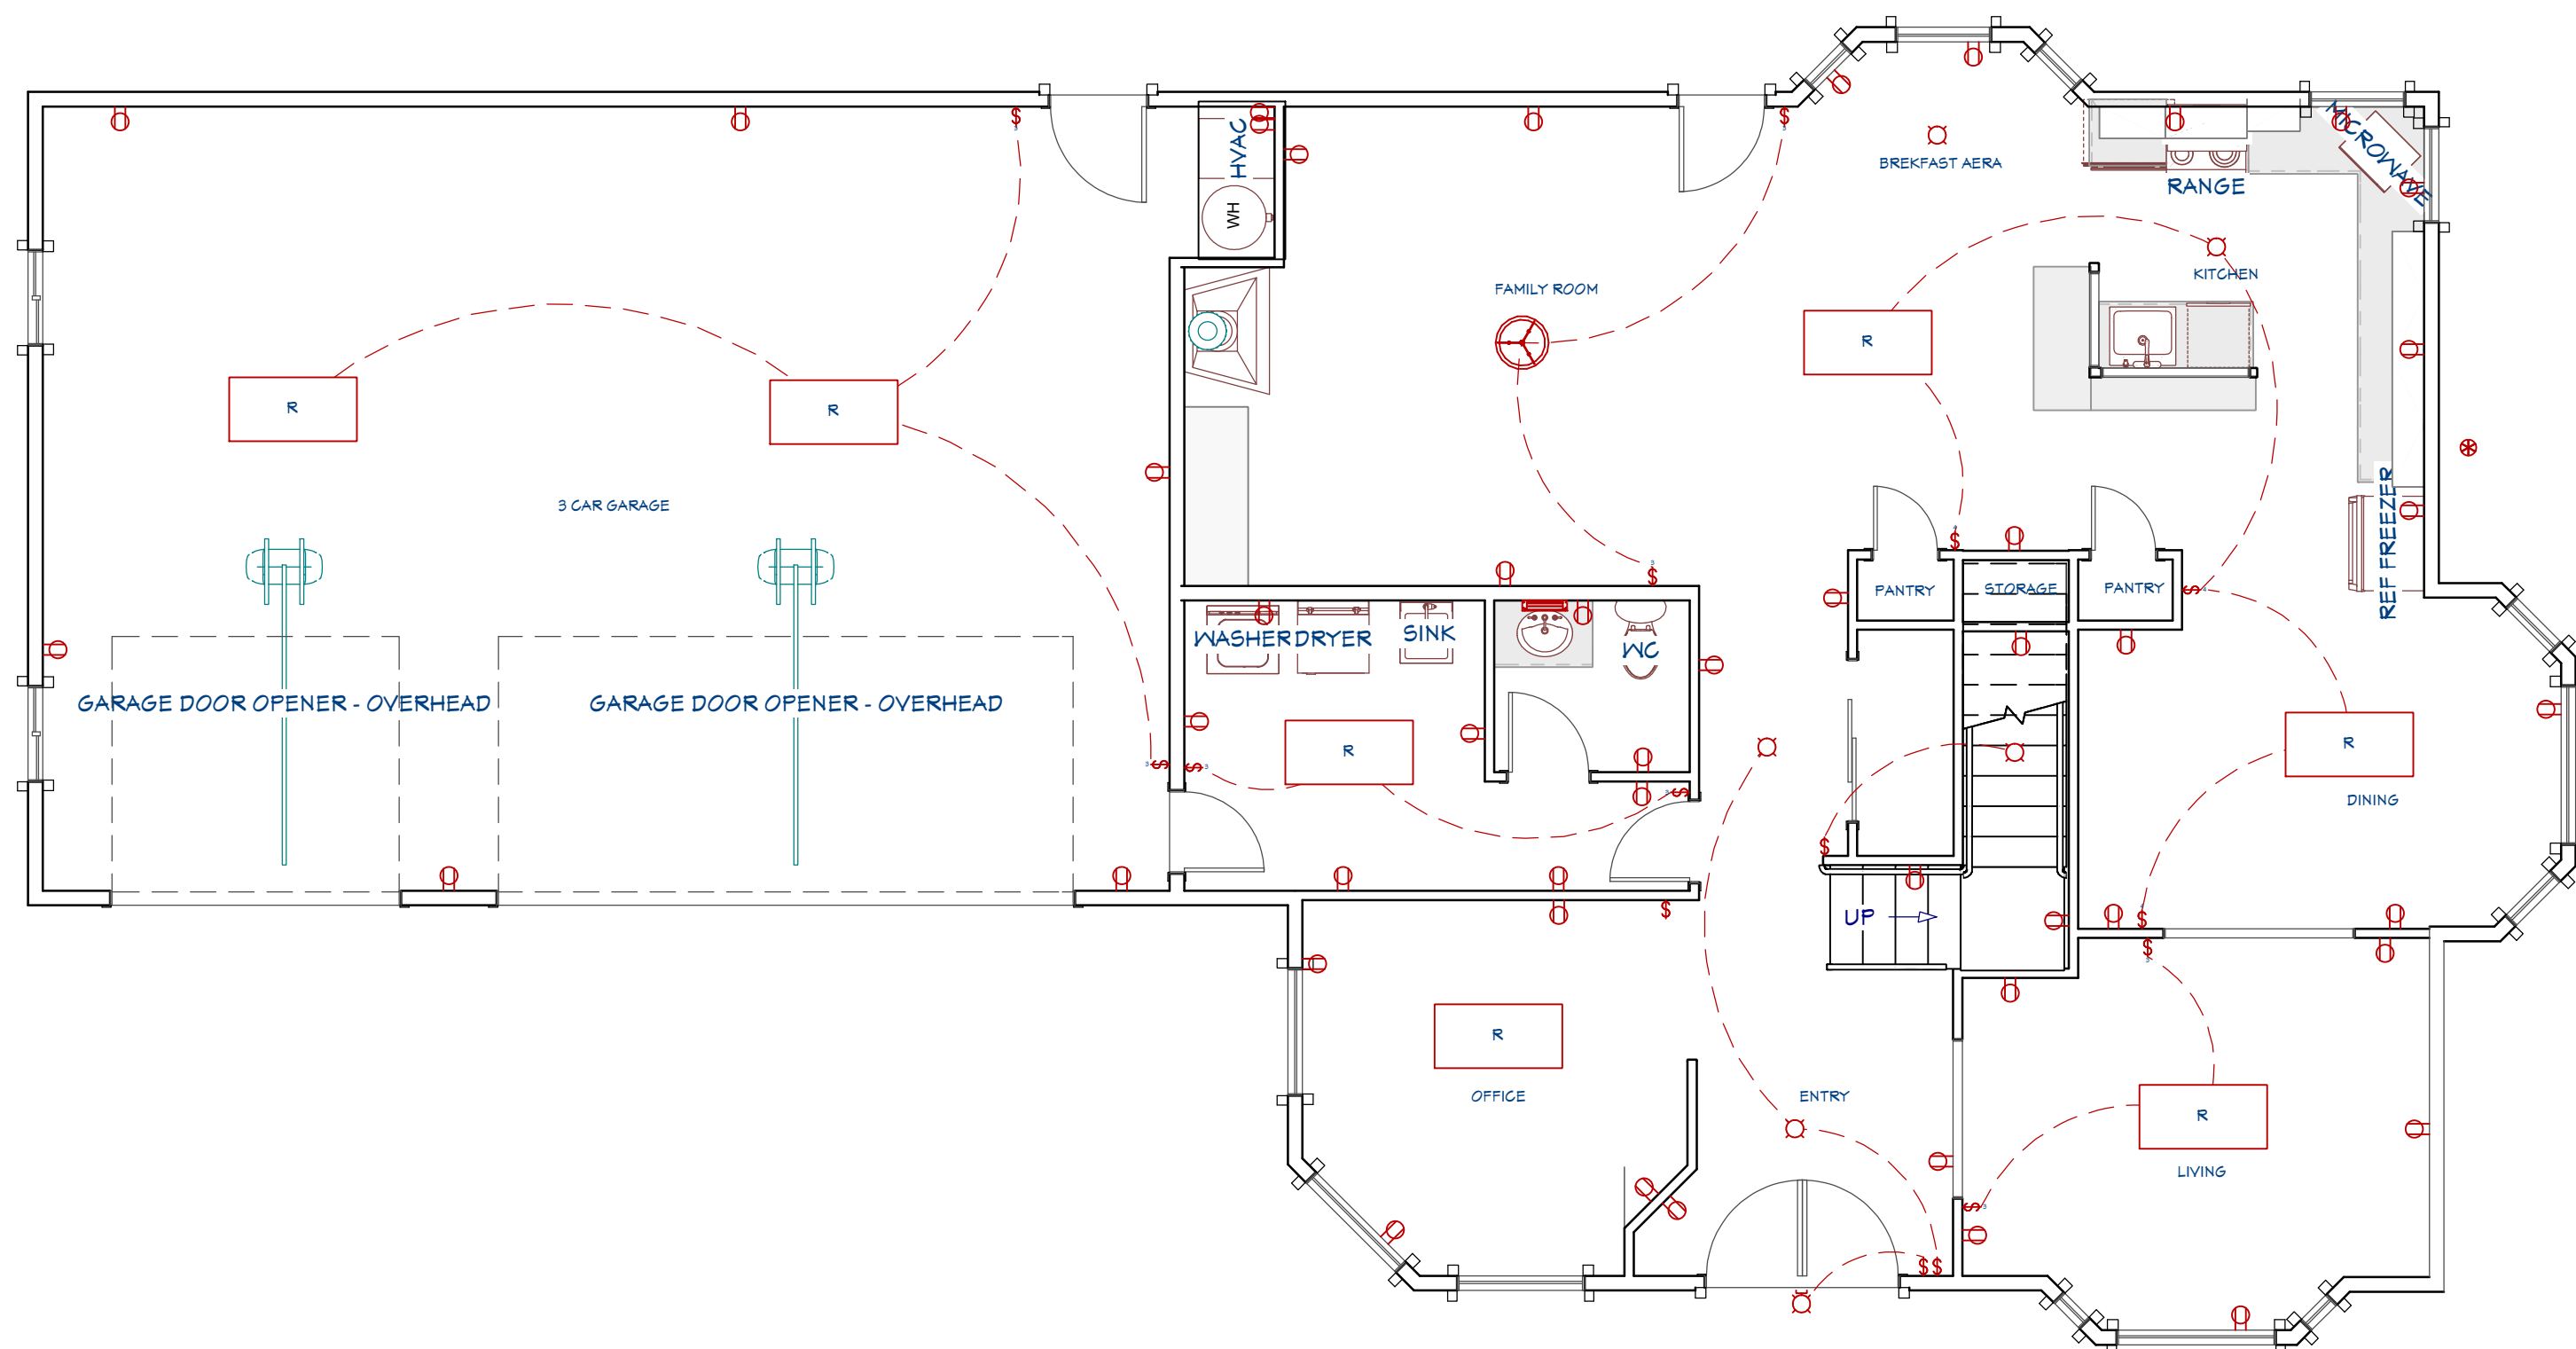

Main Floor Electrical Plan
Scale: 3/16" = 1'-0"

ELECTRICAL SCHEDULE			
SYMBOL	QTY	PL/220R	DESCRIPTION
3	1		3-WAY SWITCH
4	1		4-WAY SWITCH
5	2		ARTS & CRAFTS CHANDELIER
6	1		BOYL PENDANT CHANDELIER
7	1		CAGED LANTERN SCORGE
8	41		DUPLEX
9	1		SFCI
10	1		K-81144-SLE MAXSTON LIGHTED MEDICINE CABINET
11	2		MEDIUM DOUBLE SURFACE MOUNTED TUBE LIGHT (48"x21")
12	1		PATH LIGHT
13	1		SHORT DOUBLE RECESSED TUBE LIGHT (48"x24")
14	4		SINGLE POLE SWITCH
15	5		TRADITIONAL FLUSH DOME
16	20		DUPLEX
17	2		K-81144-SLE MAXSTON LIGHTED MEDICINE CABINET
18	1		SINGLE POLE SWITCH
19	5		TRADITIONAL FLUSH DOME

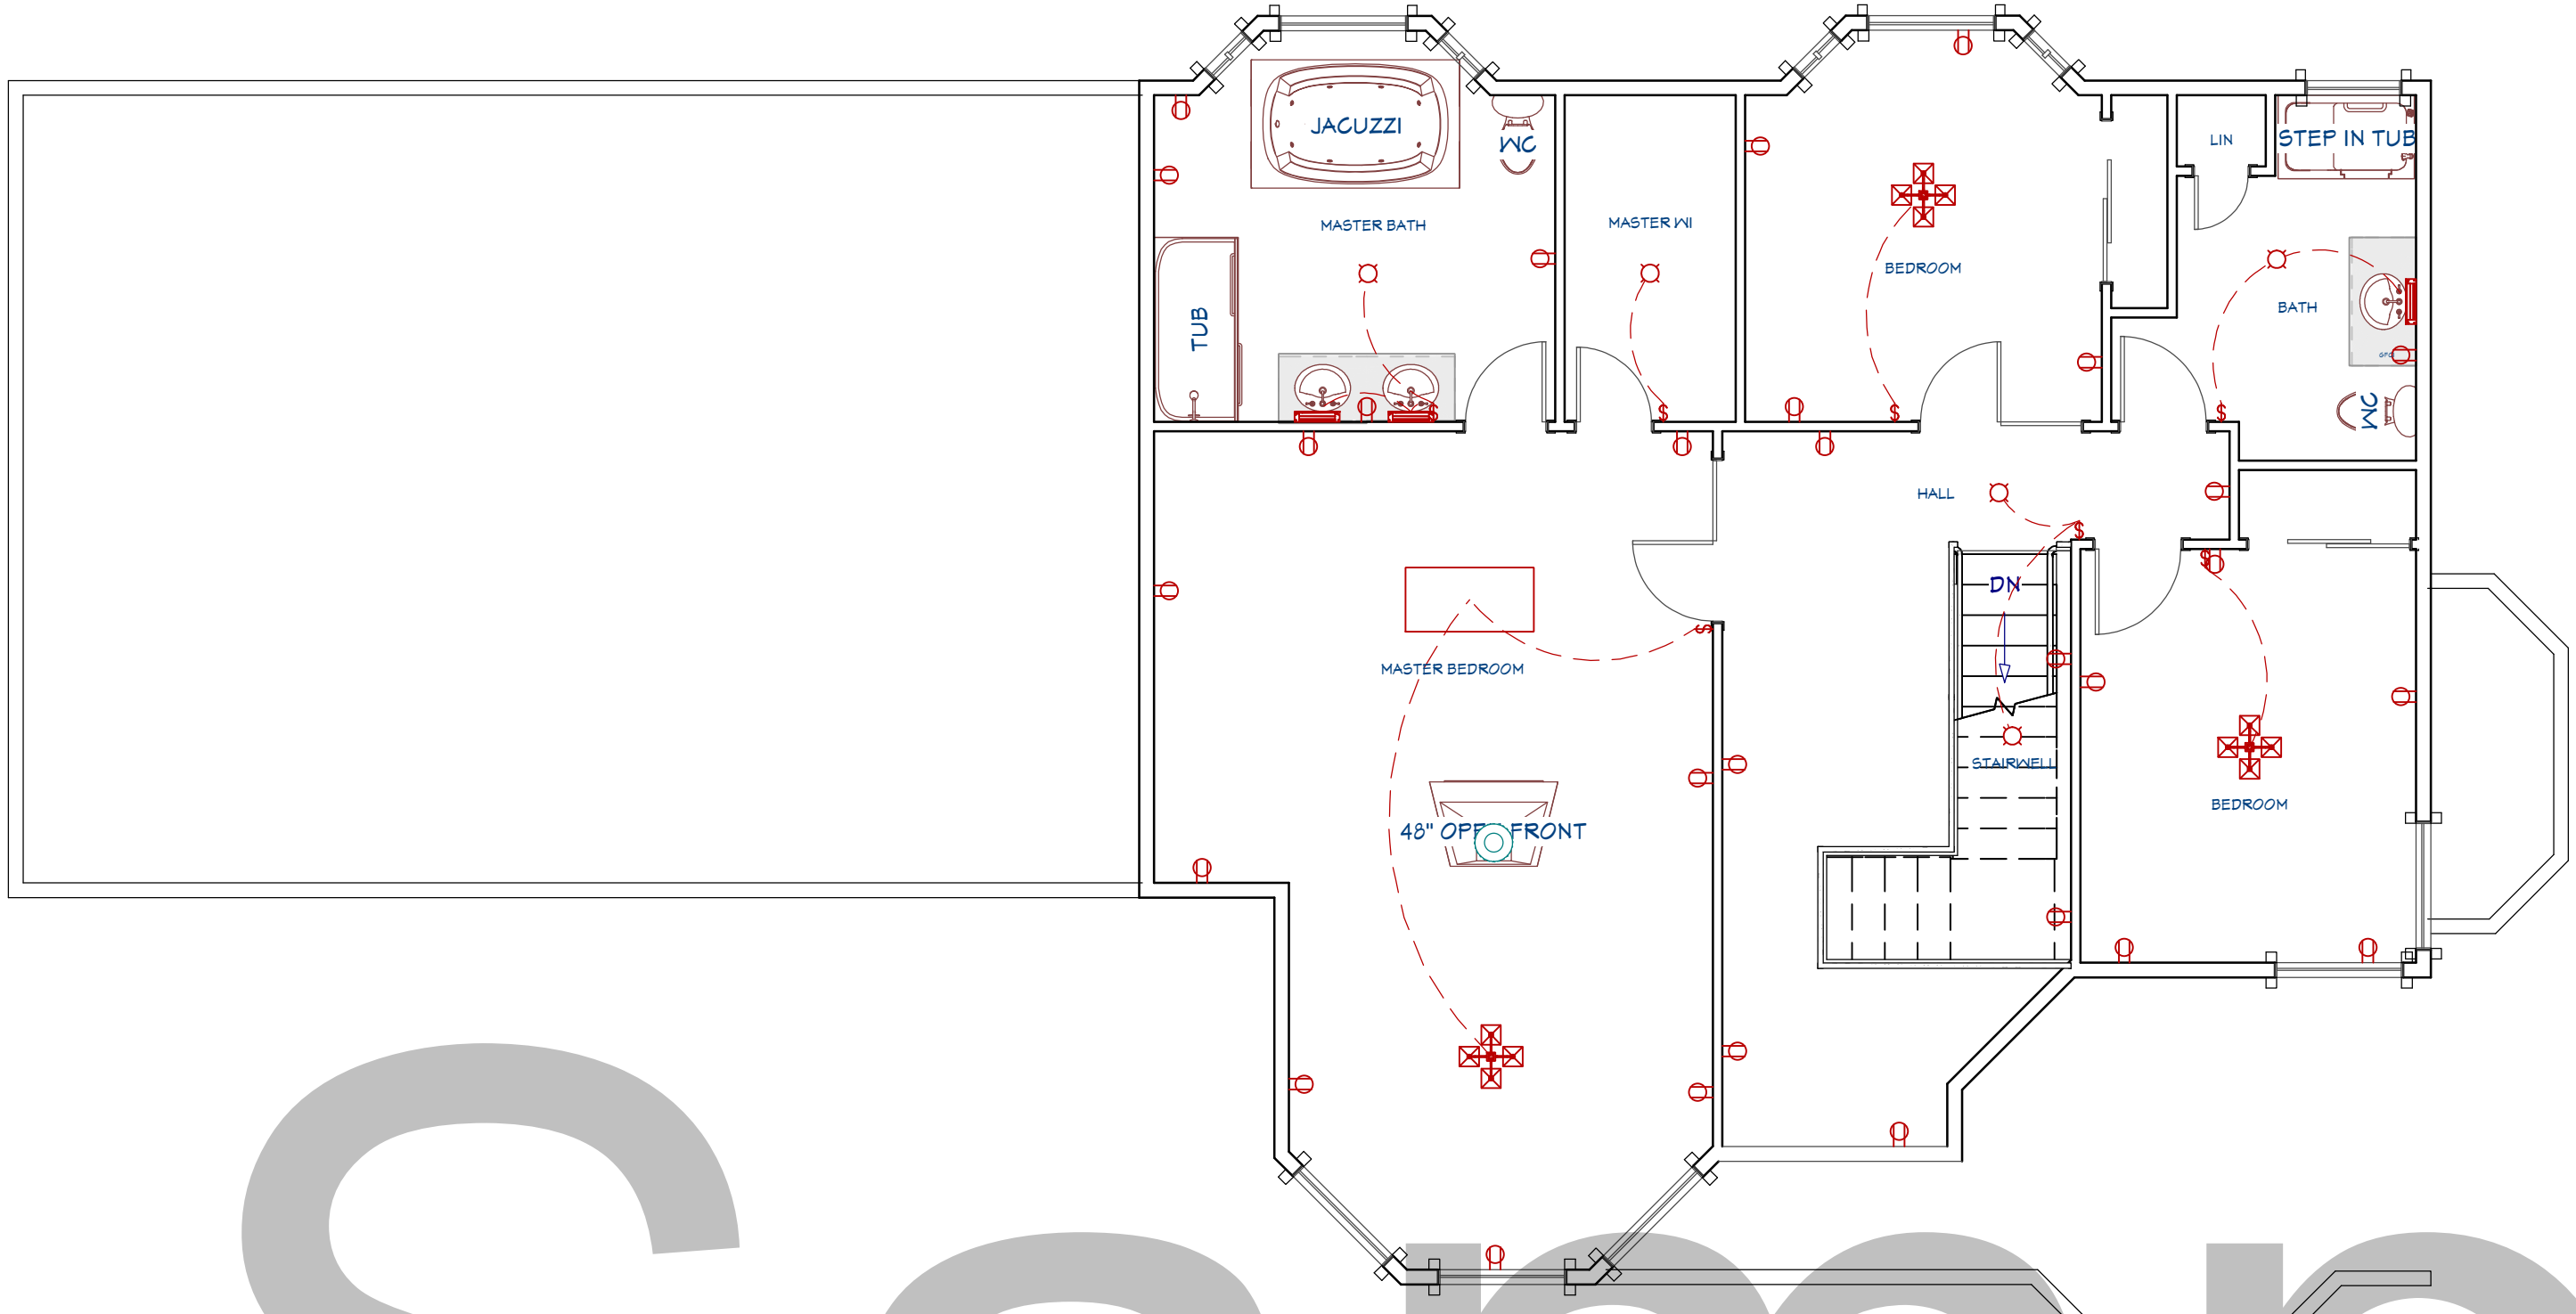

Second Floor Electrical Plan
Scale: 3/16" = 1'-0"

REVISION TABLE

NUMBER	DATE	REVISION BY	DESCRIPTION

Drawings Provided By:

BC

DATE:

10/3/2025


SCALE:

as shown

SHEET:

P-6

Electrical Plan

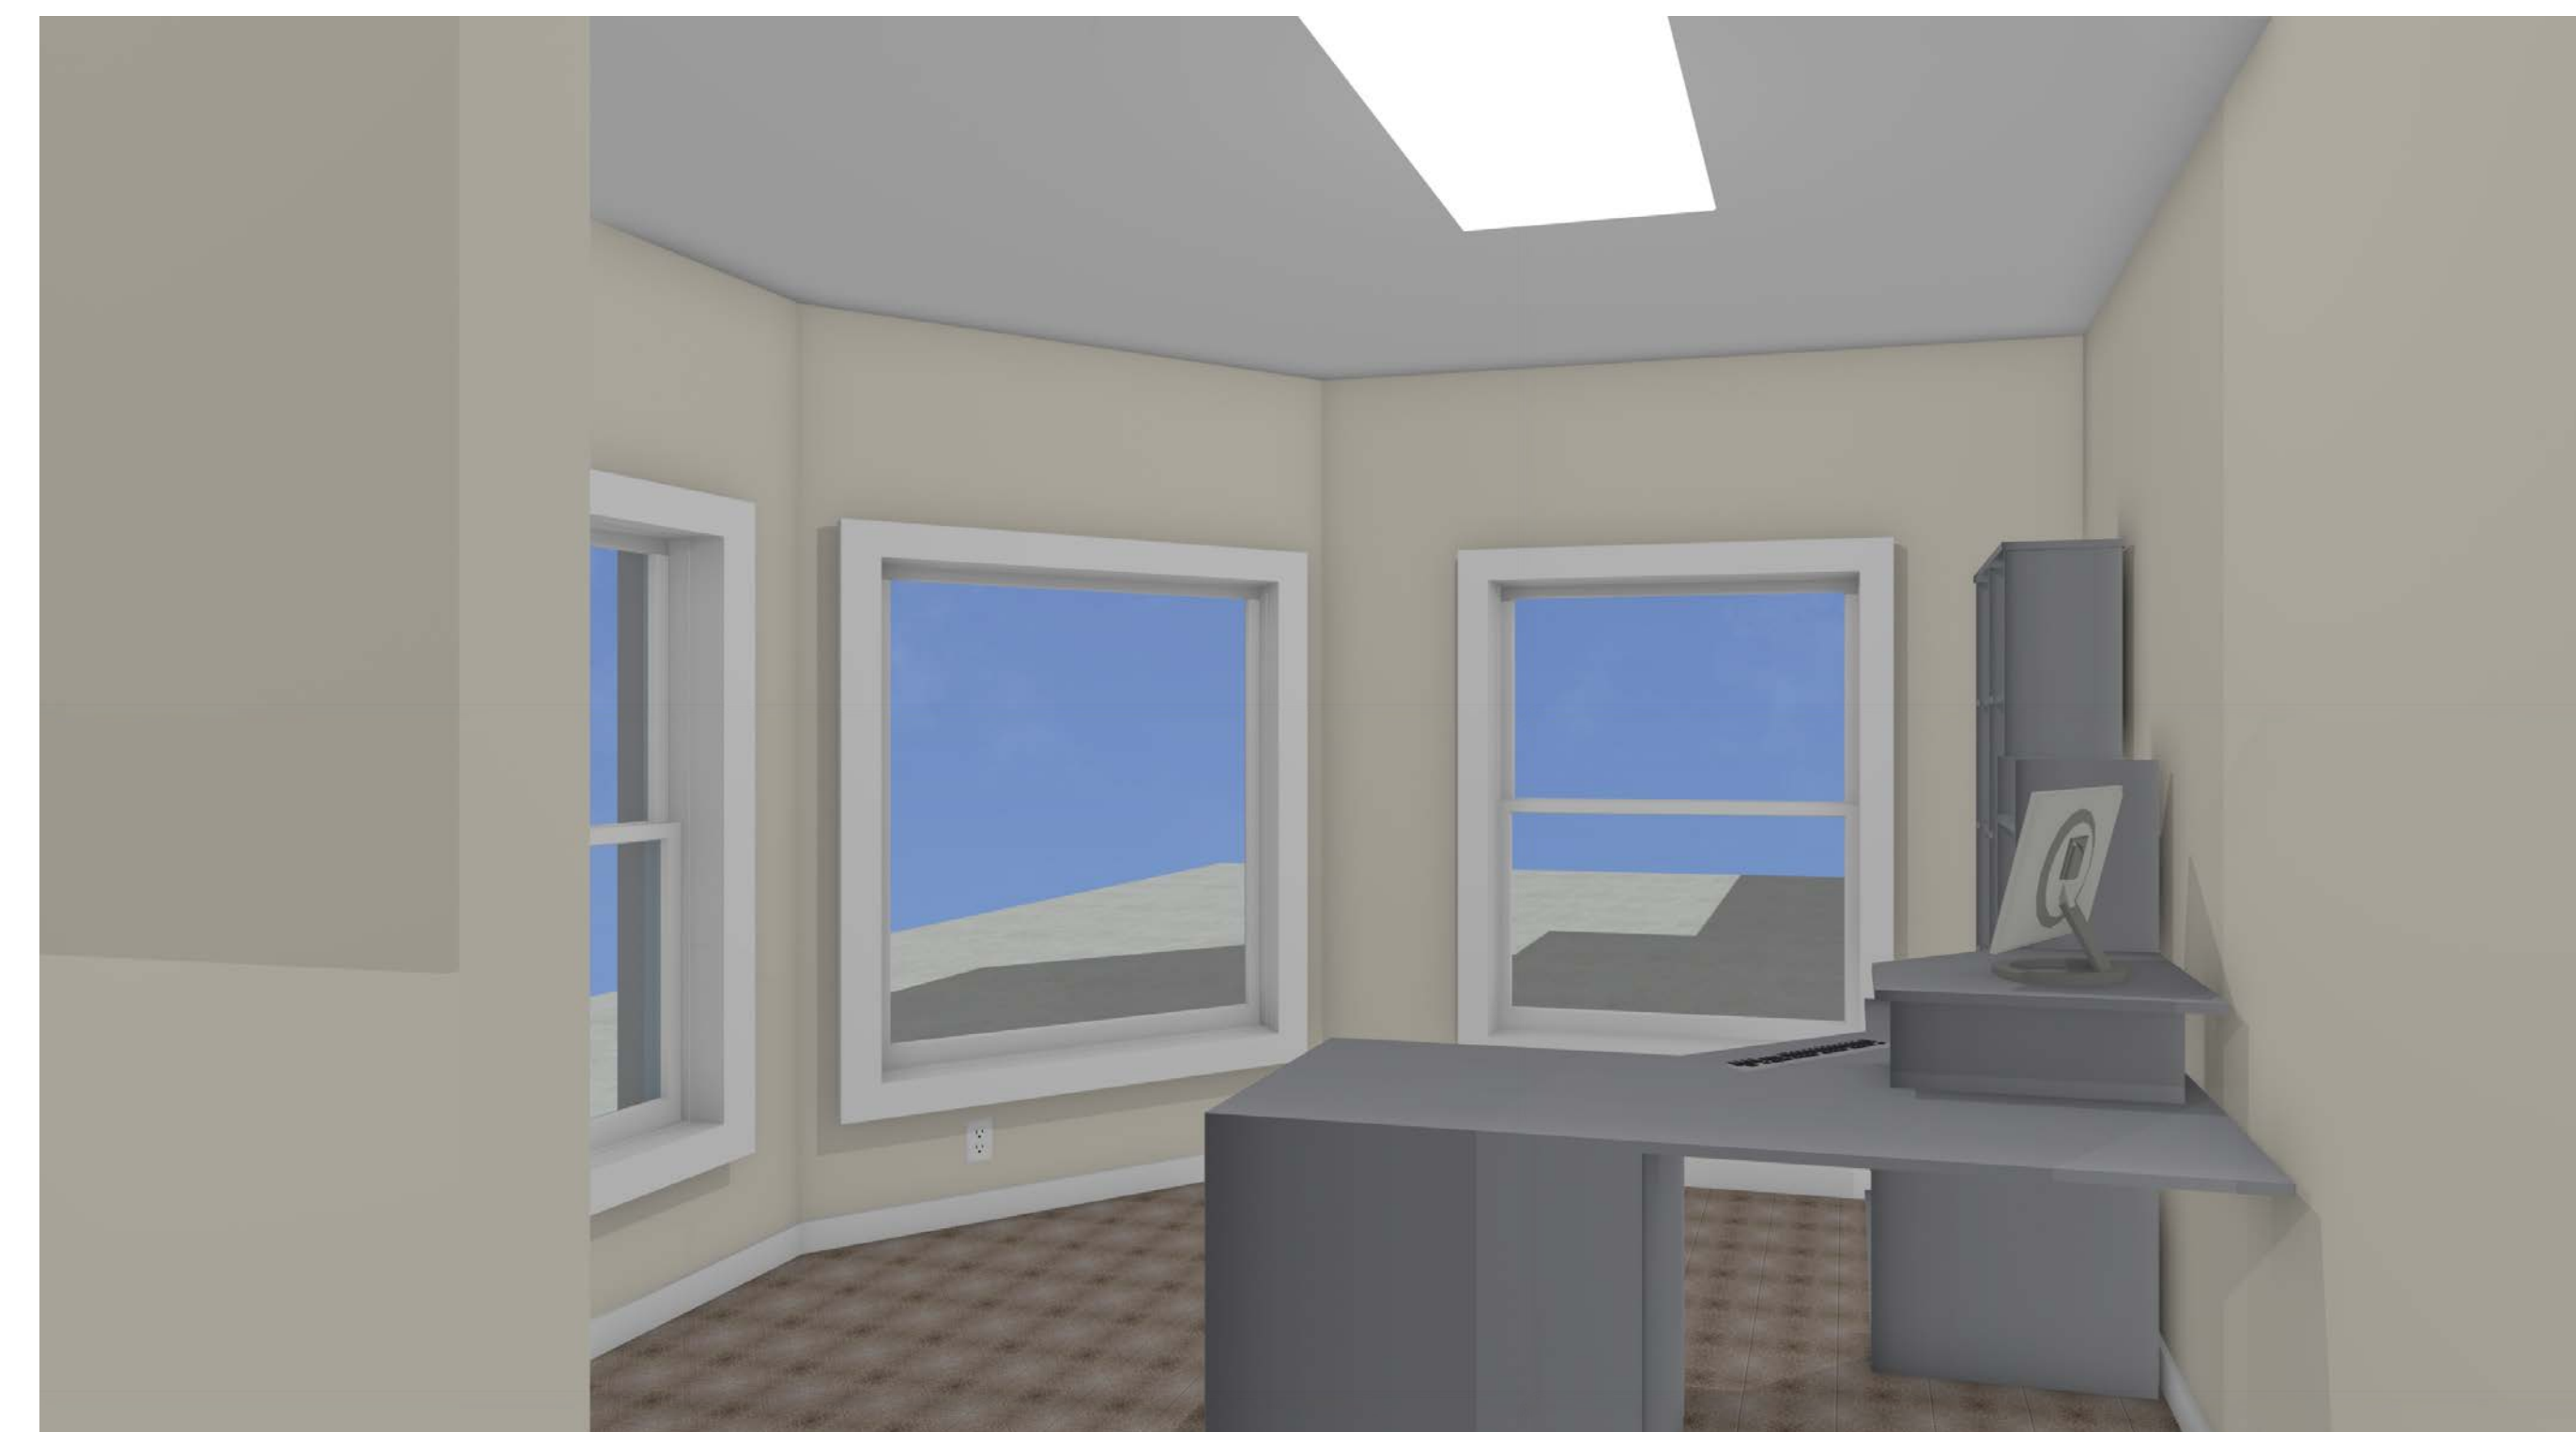[illegible]


Interior Views

DRAWINGS PROVIDED BY: BC

DATE:
10/3/2025

SCALE:
as shown

SHEET:
P-7

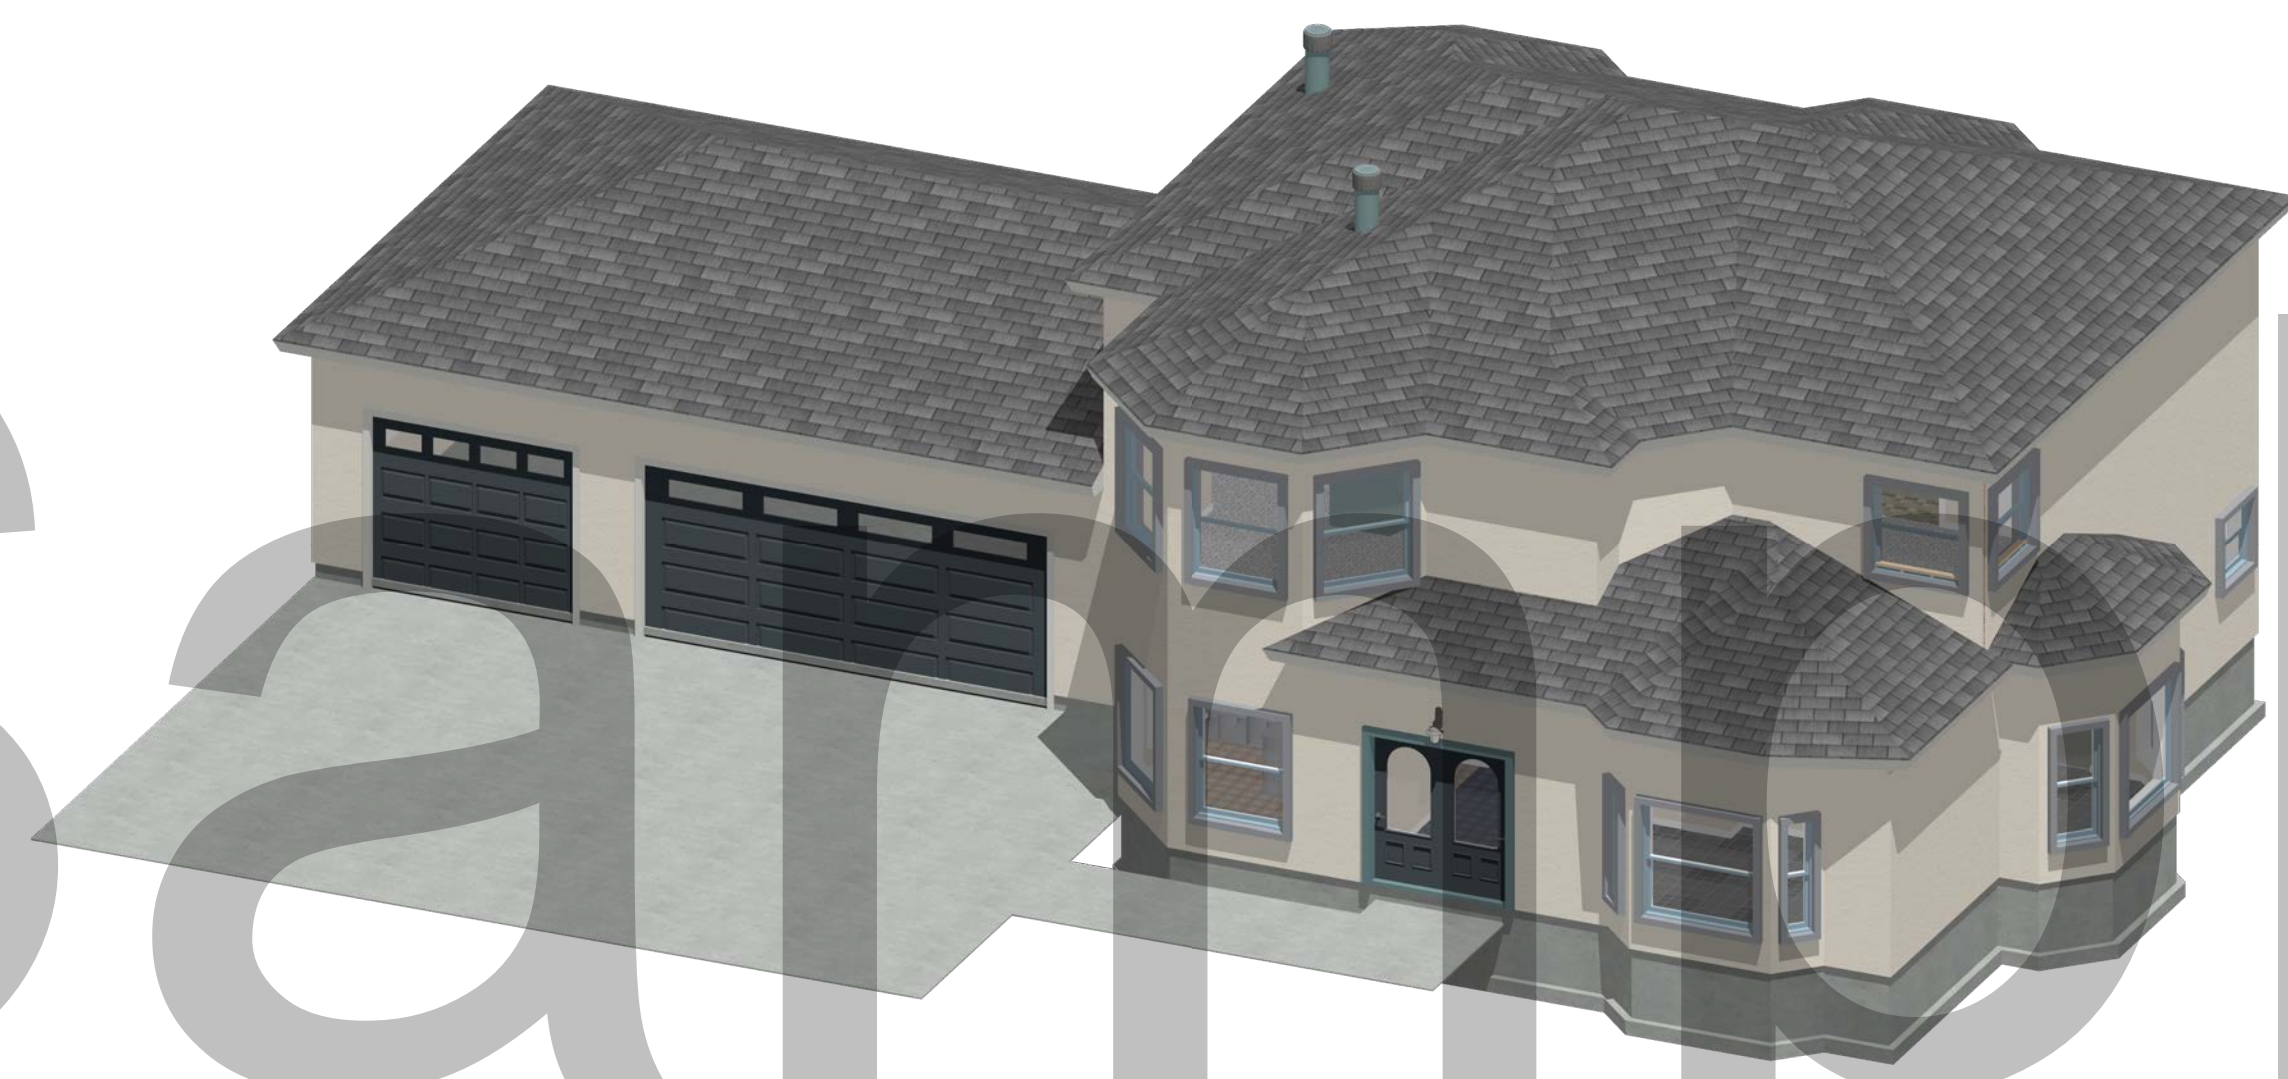[illegible]

Main Floor Roof Plan

DRAWINGS PROVIDED BY:

BC

DATE:

10/3/2025

SCALE:

as shown

SHEET:

P-8



A 3D architectural rendering of a two-story house with a grey shingled roof, beige siding, and a dark grey garage. The house features a front porch with a dark door and several windows. A large, semi-transparent 'Sale' watermark is overlaid across the center of the image.

DRAWINGS PROVIDED BY:	BC
DATE:	10/3/2025
SCALE:	as shown
SHEET:	p-q