



The David Home Rendering  
Scale None  
2790 Sq. Ft.

NUMBER	DATE	REVISION TABLE	REVISOR	DESCRIPTION

Project Overview

DRAWINGS PROVIDED BY:  
Bill Cullum

DATE:  
5/25/2026

SCALE:  
as  
shown

SHEET:

P-1






Exterior Elevation Front  
3/16" = 1' 0"



Exterior Elevation Back  
3/16" = 1' 0"

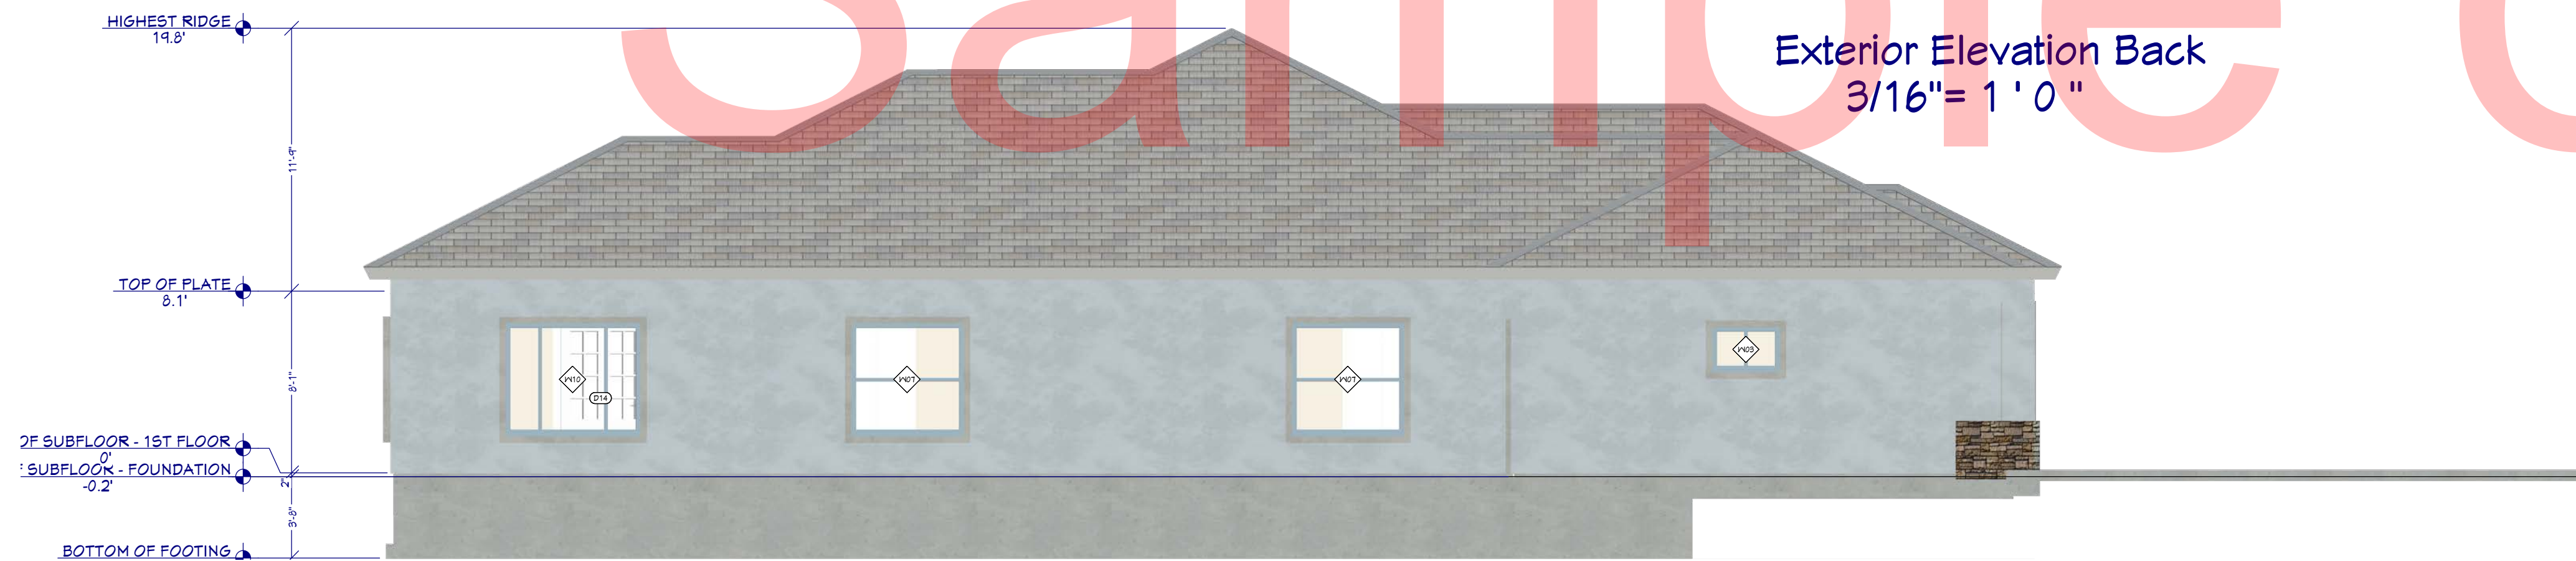

Exterior Elevation Left  
3/16" = 1' 0"



Exterior Elevation Right  
3/16" = 1' 0"

Sample only

REVISION TABLE	
NUMBER	DATE

REVISION TABLE	REVISION BY	DESCRIPTION

Elevations

DRAWINGS PROVIDED BY:  
Bill Cullum

DATE:


5/25/2026

SCALE:


as  
shown

SHEET:

P3

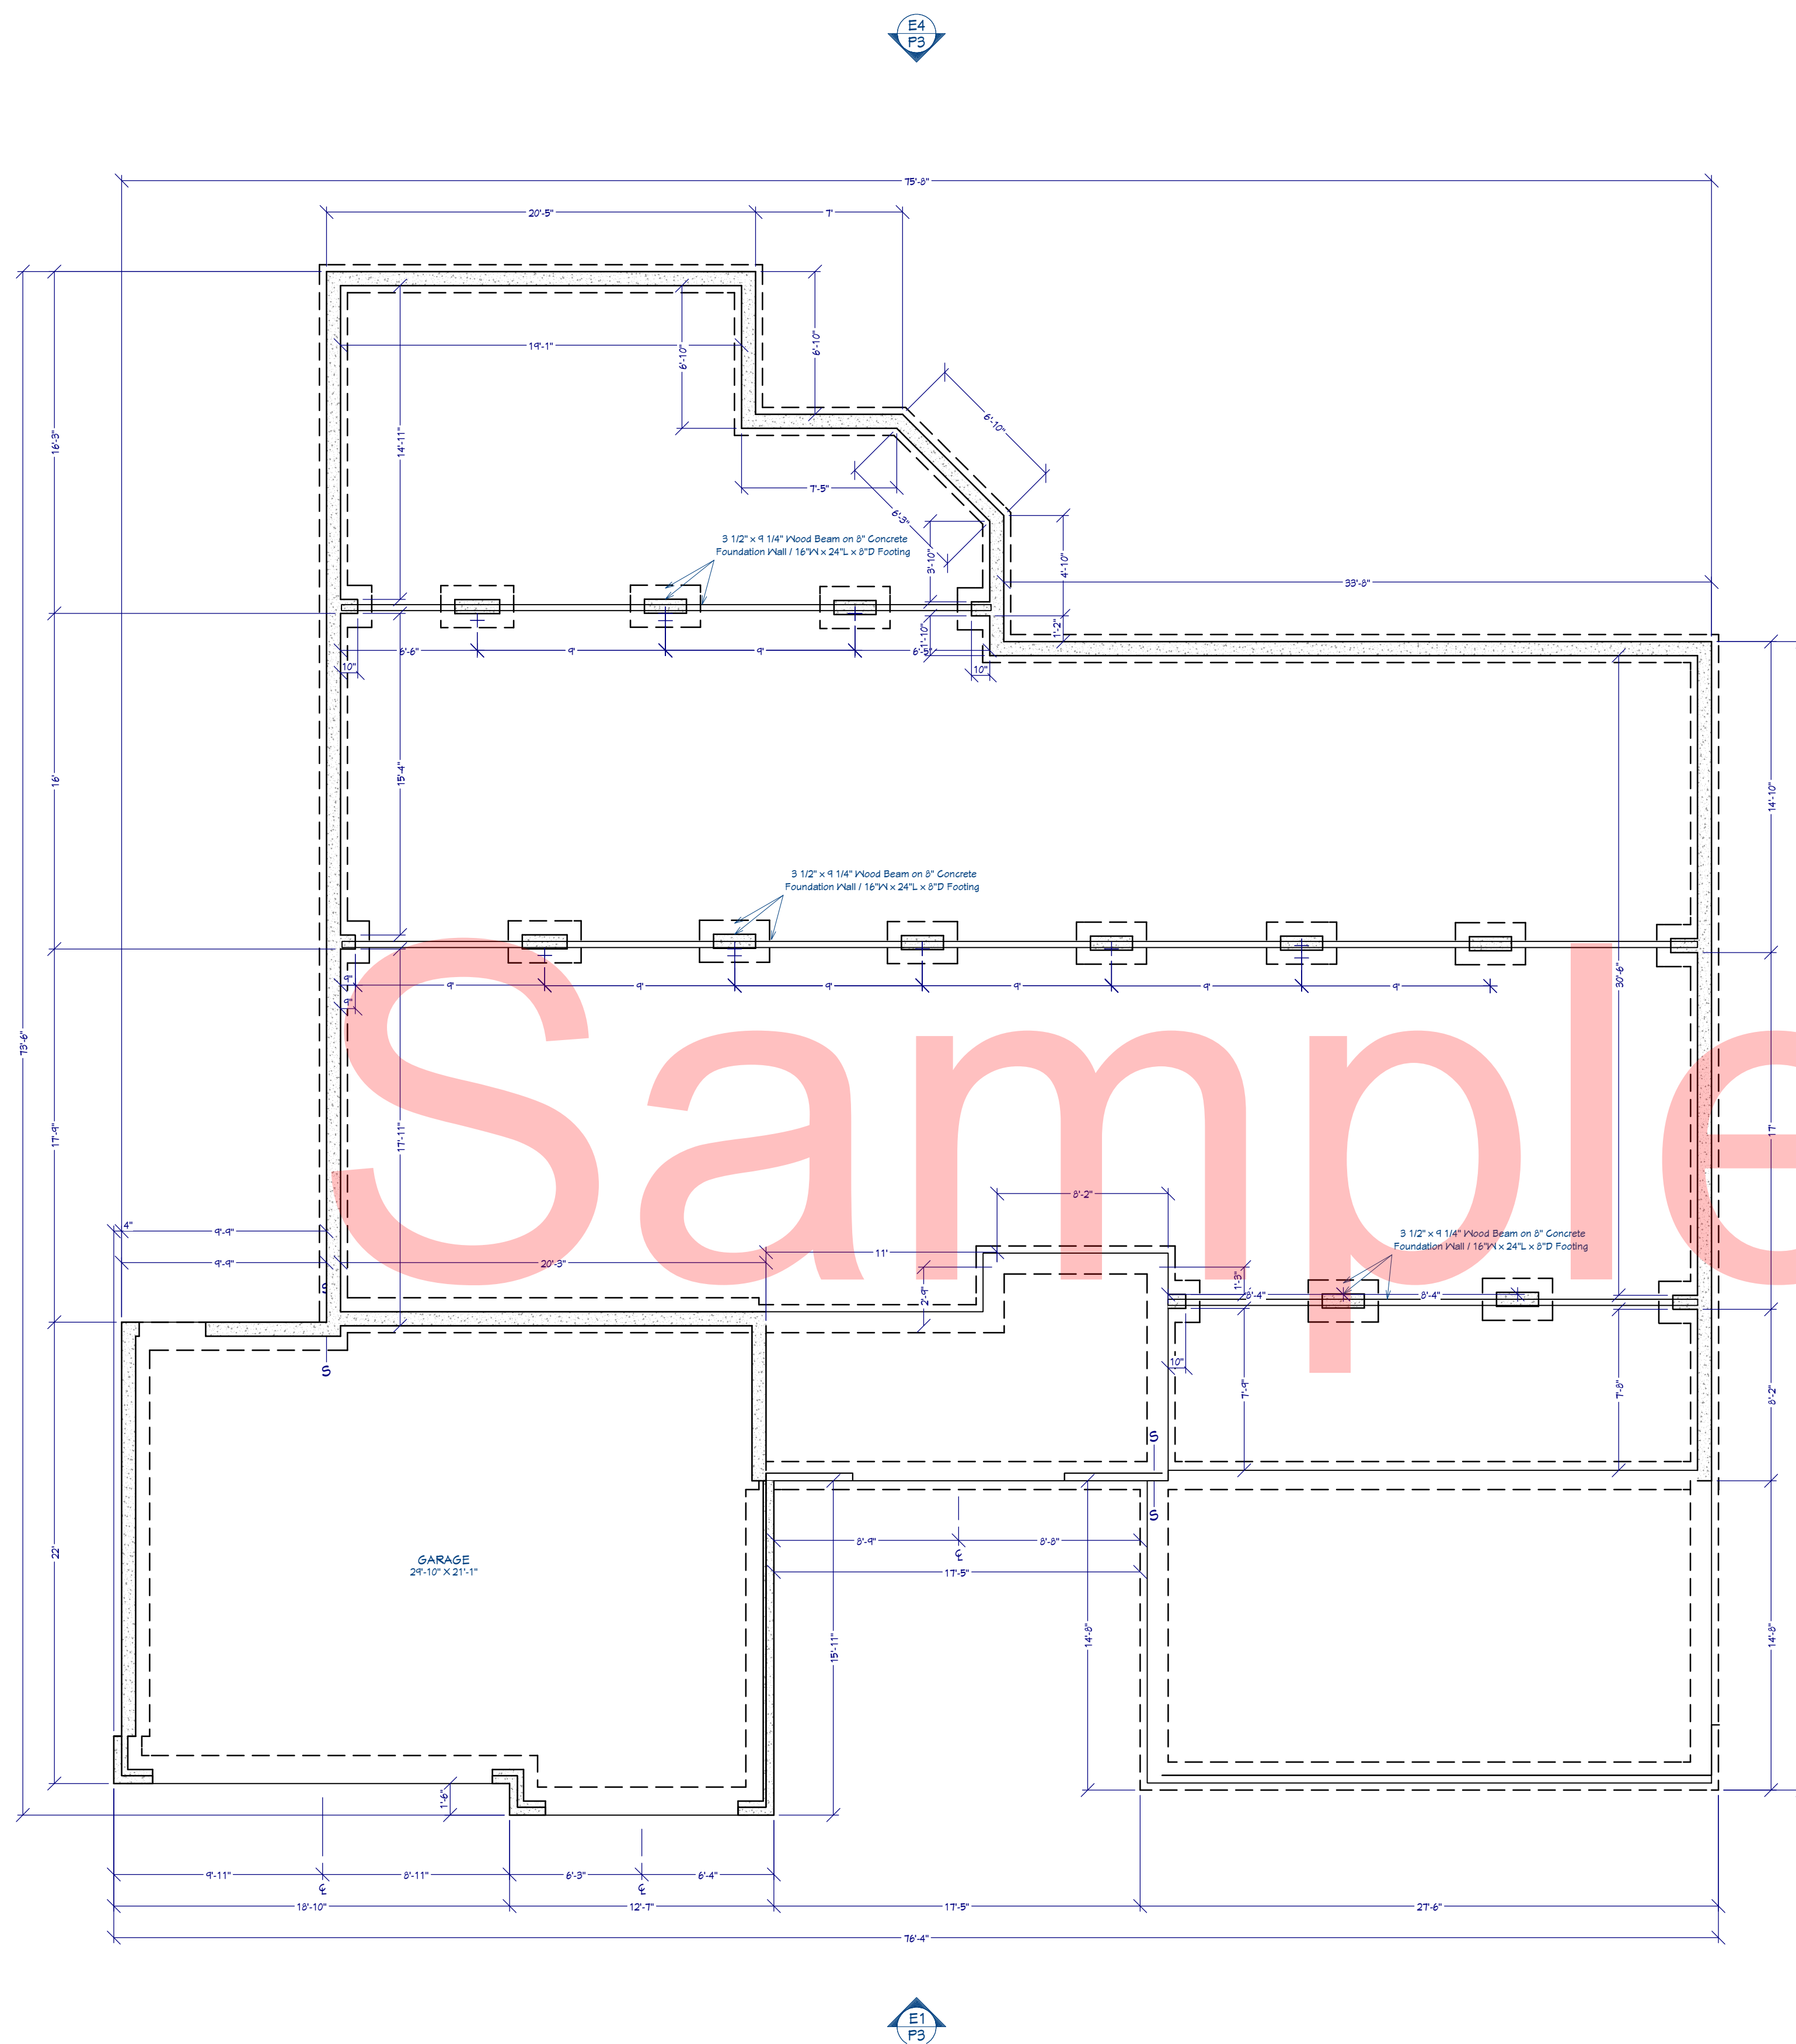


Foundation Plan View  
scale 3/16" = 1'-0"

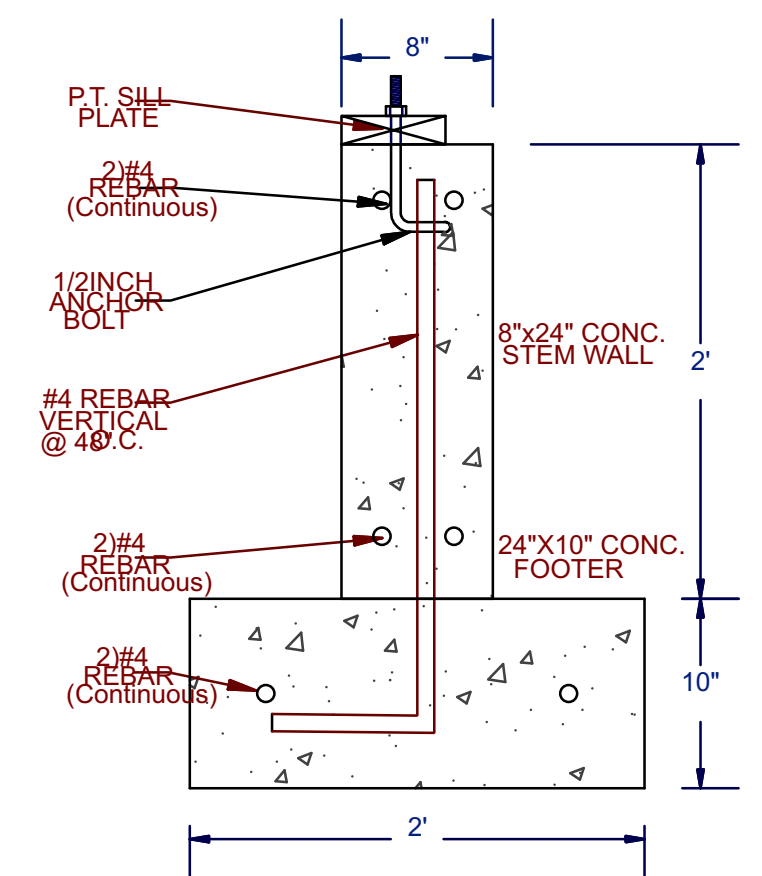


Typical Application around  
Perimeter Stem Walls

NOTE:  
ALL REBAR PER LOCAL CODE  
AND /OR ENGINEER'S DESIGN

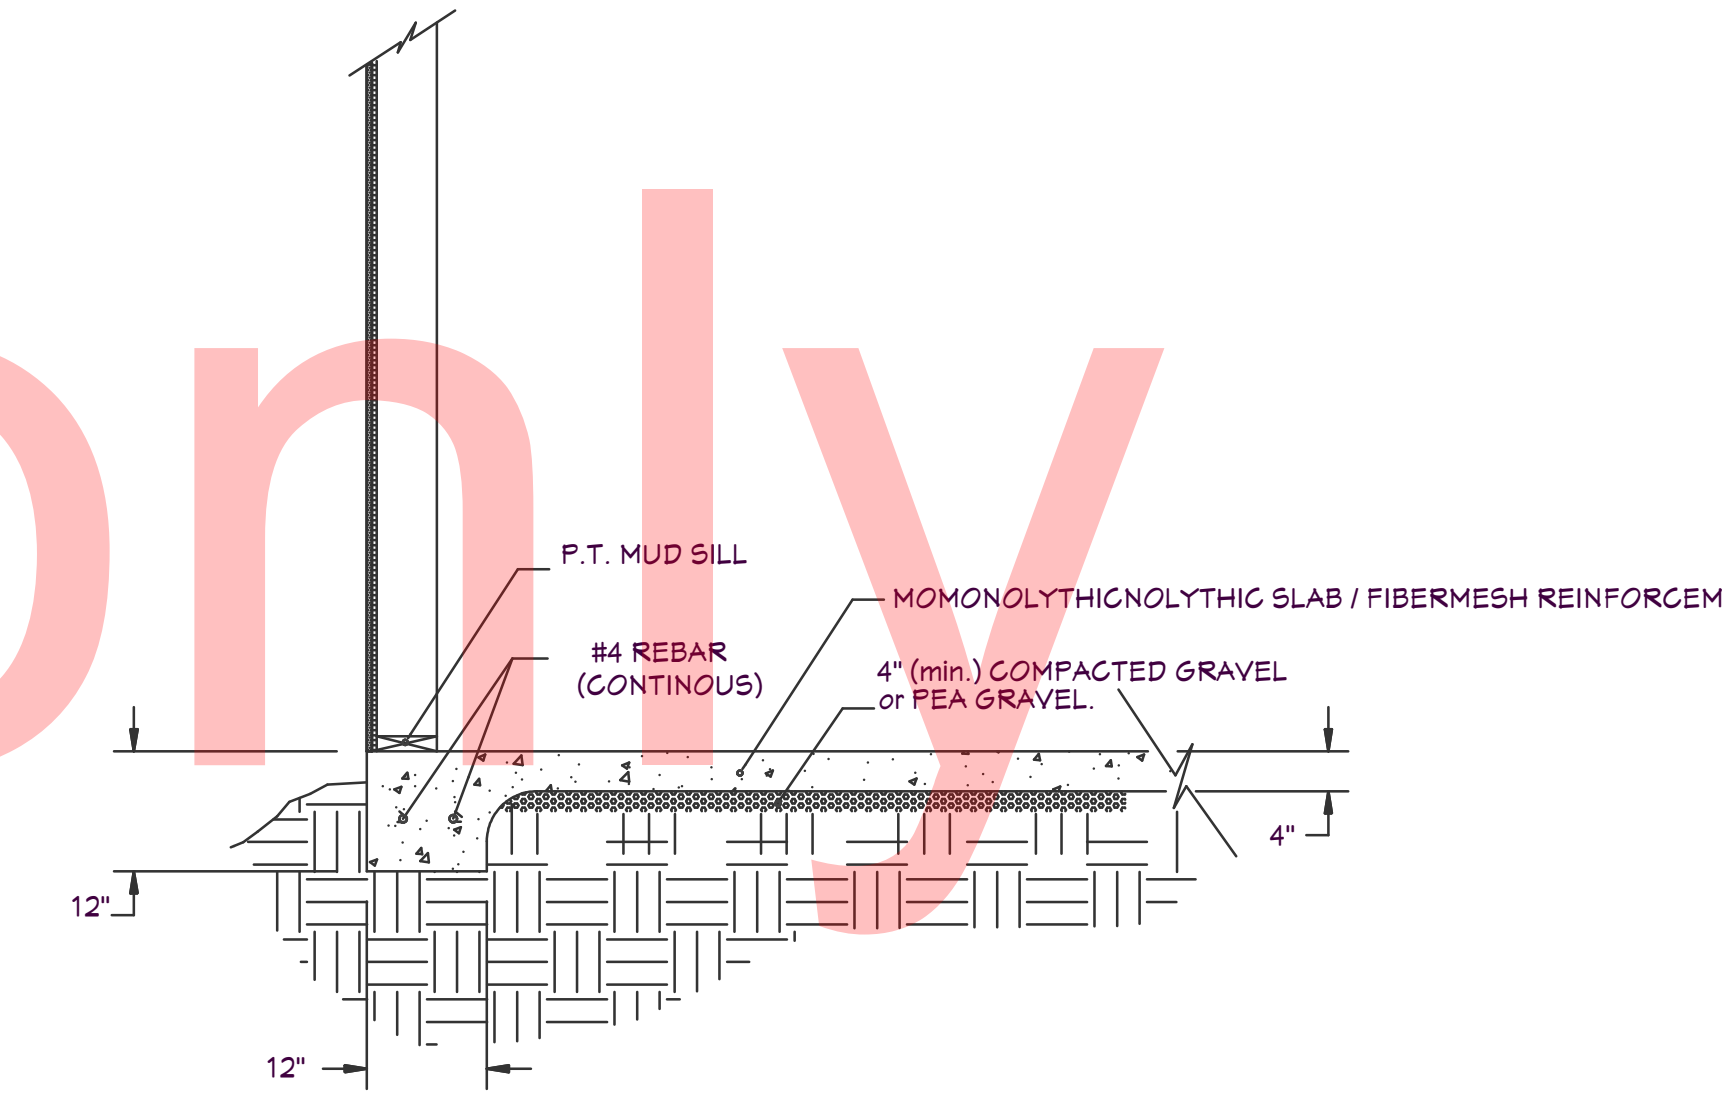

Garage Floor  
& Green House  
Section

NOTE:  
ALL REBAR PER LOCAL CODE  
AND /OR ENGINEER'S DESIGN

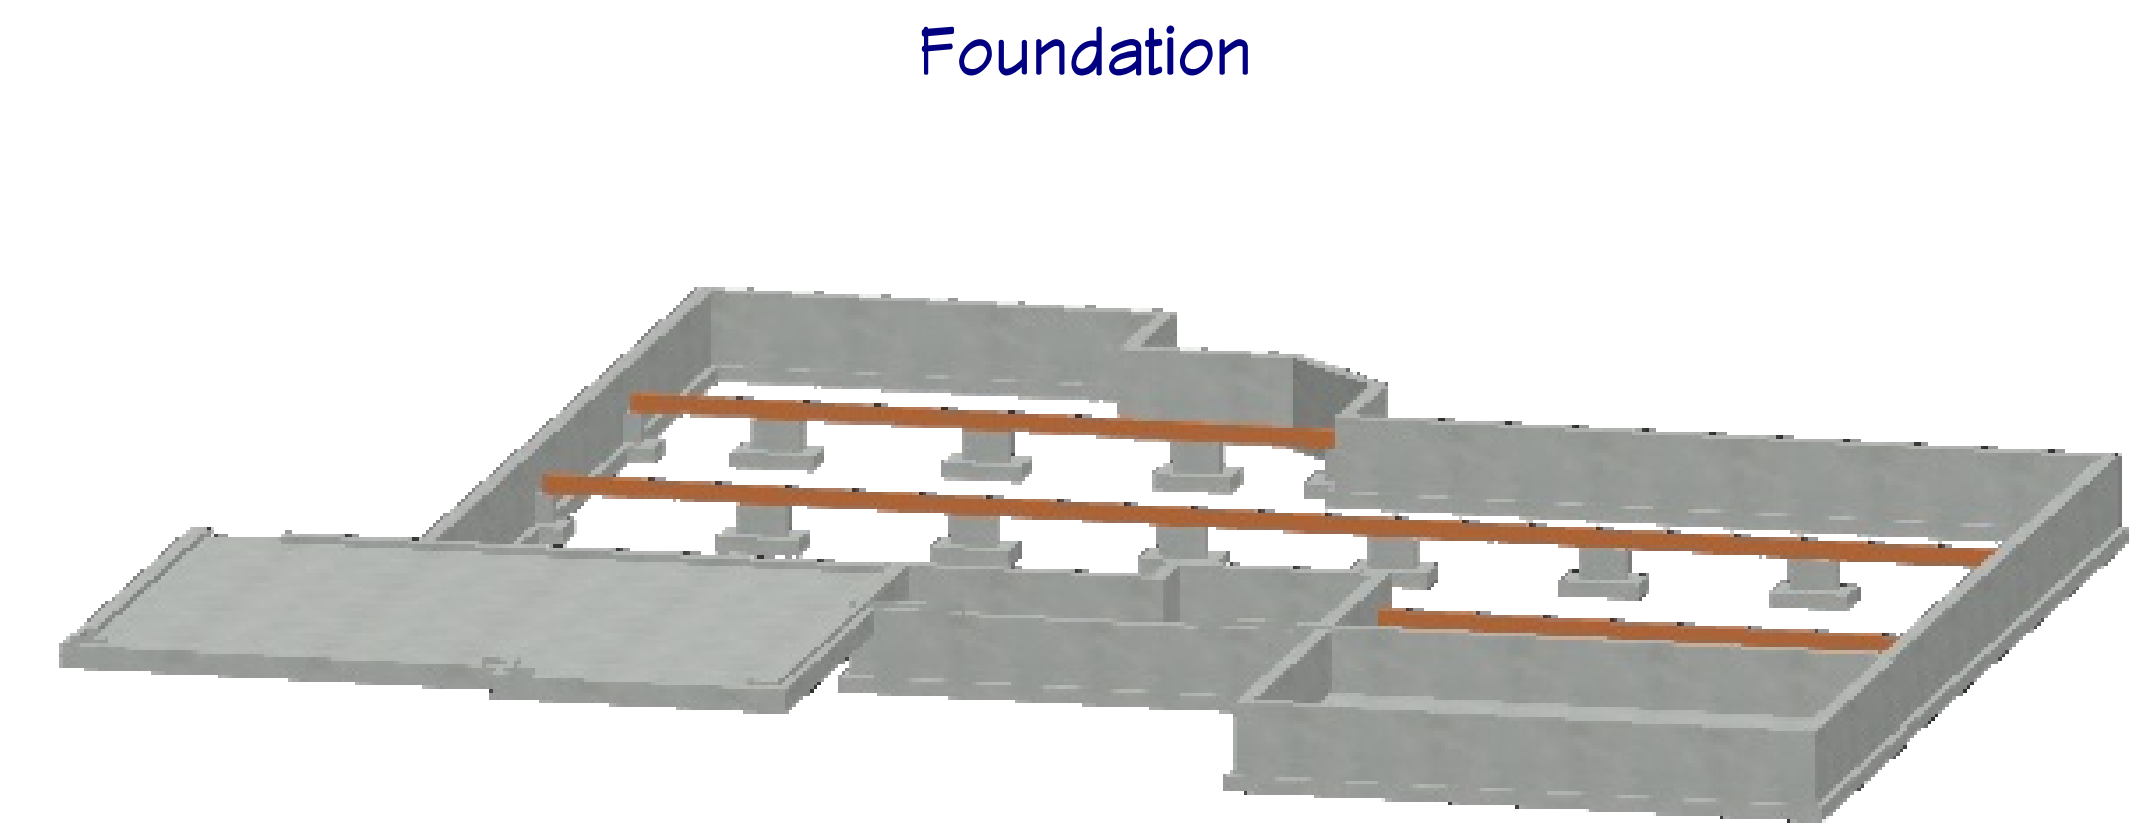

Foundation

REVISION TABLE	
NUMBER	DATE / REVISION BY / DESCRIPTION


Foundation Plan

DRAWINGS PROVIDED BY:  
Bill Cullum


DATE:  
5/25/2026

SCALE:  
as  
shown



SHEET:  
P4

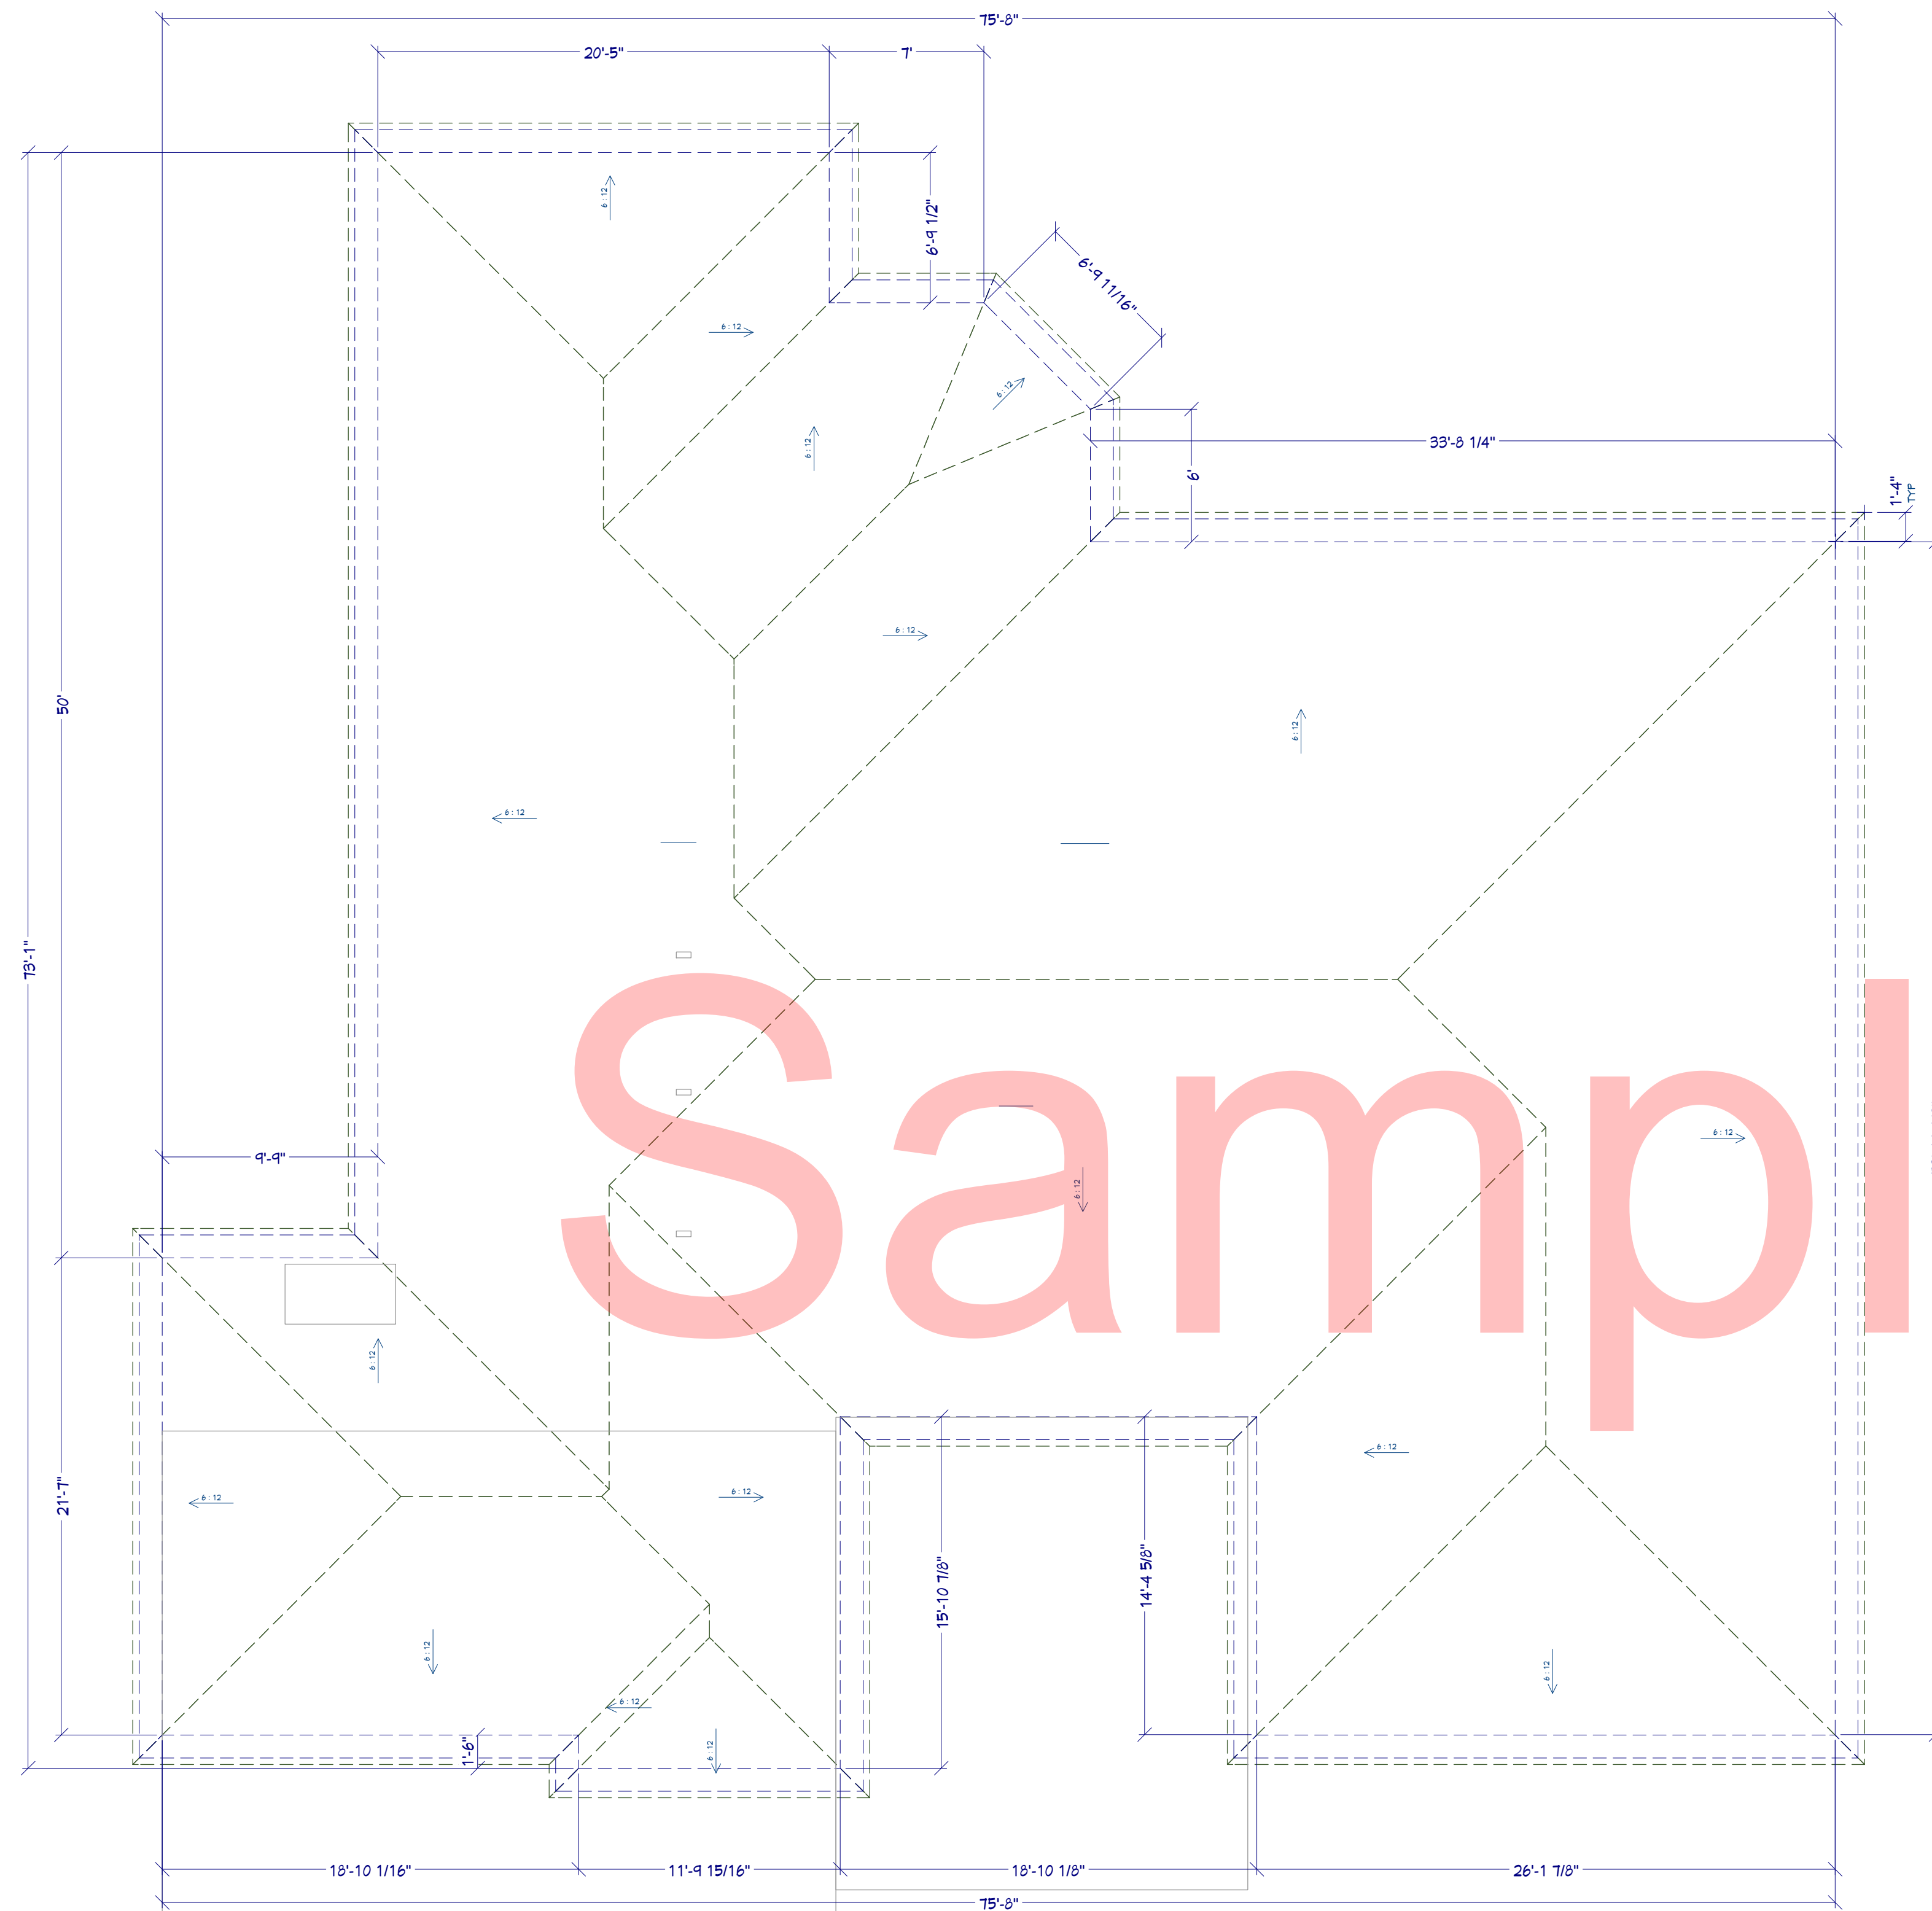

Roof Plan View  
3/16" = 1'-0"

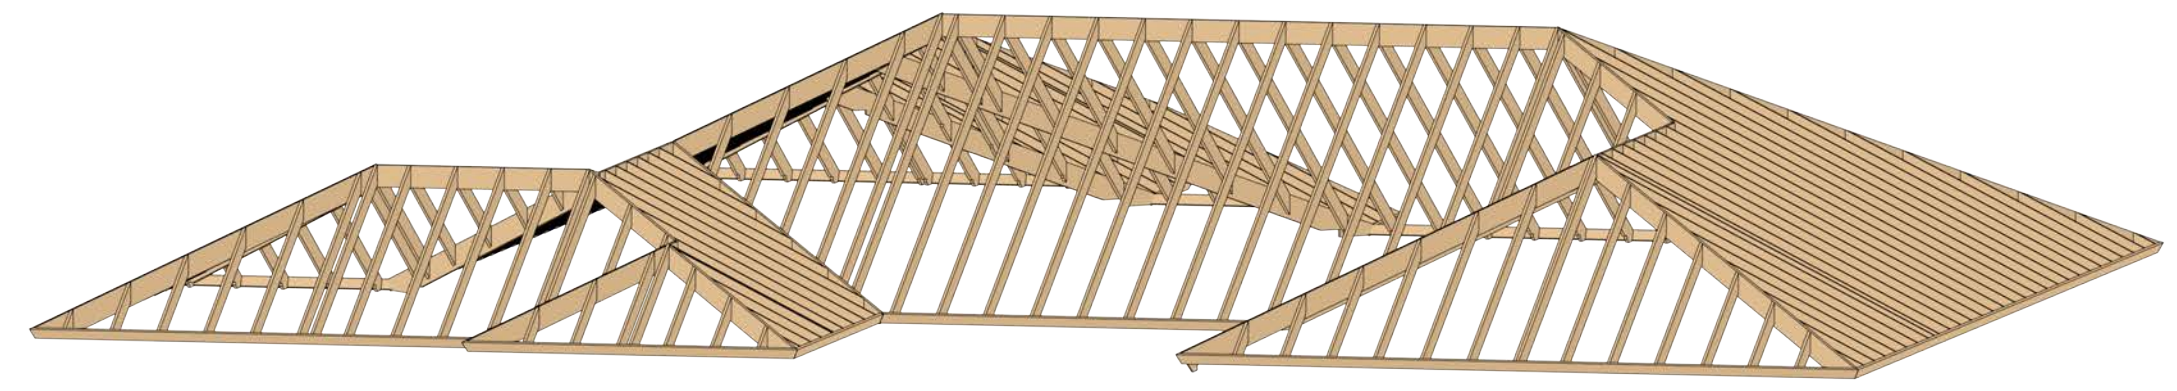

Roof ISO  
NTS

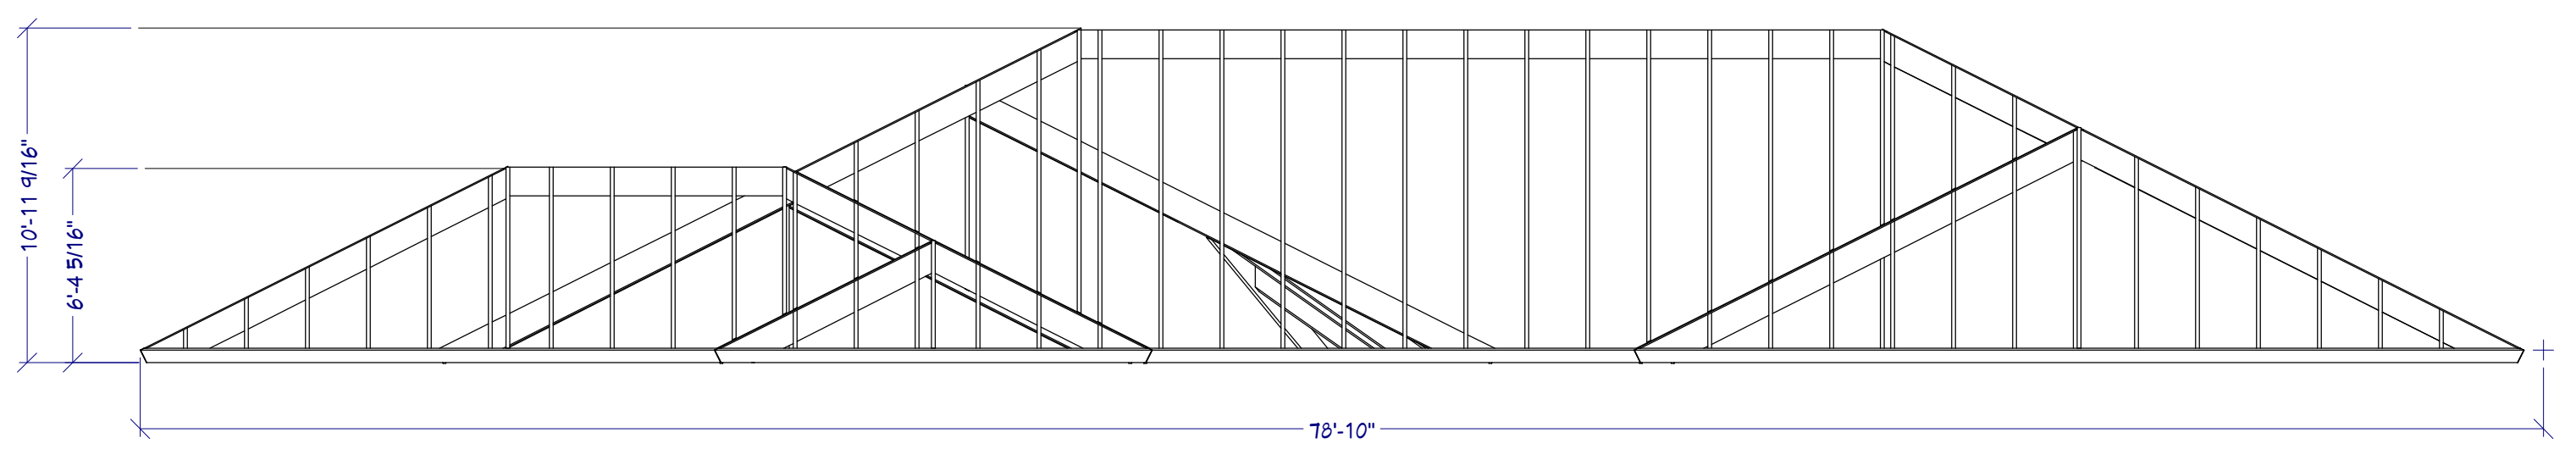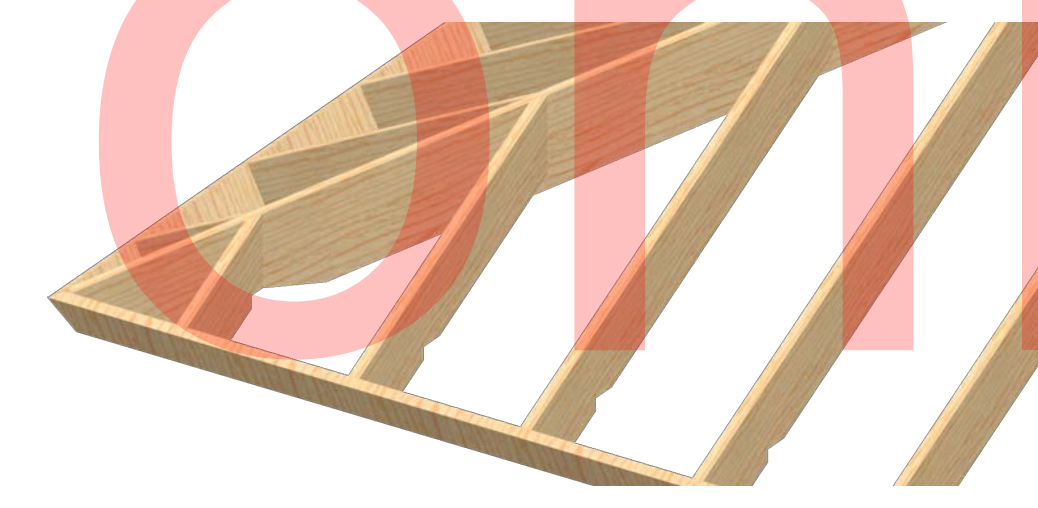

Front View  
3/16" = 1'-0"

Sample only

REVISION TABLE	
NUMBER	DATE

Roof Plan


DRAWINGS PROVIDED BY:  
Bill Cullum

DATE:  
5/25/2026

SCALE:  
as  
shown

SHEET:

A5

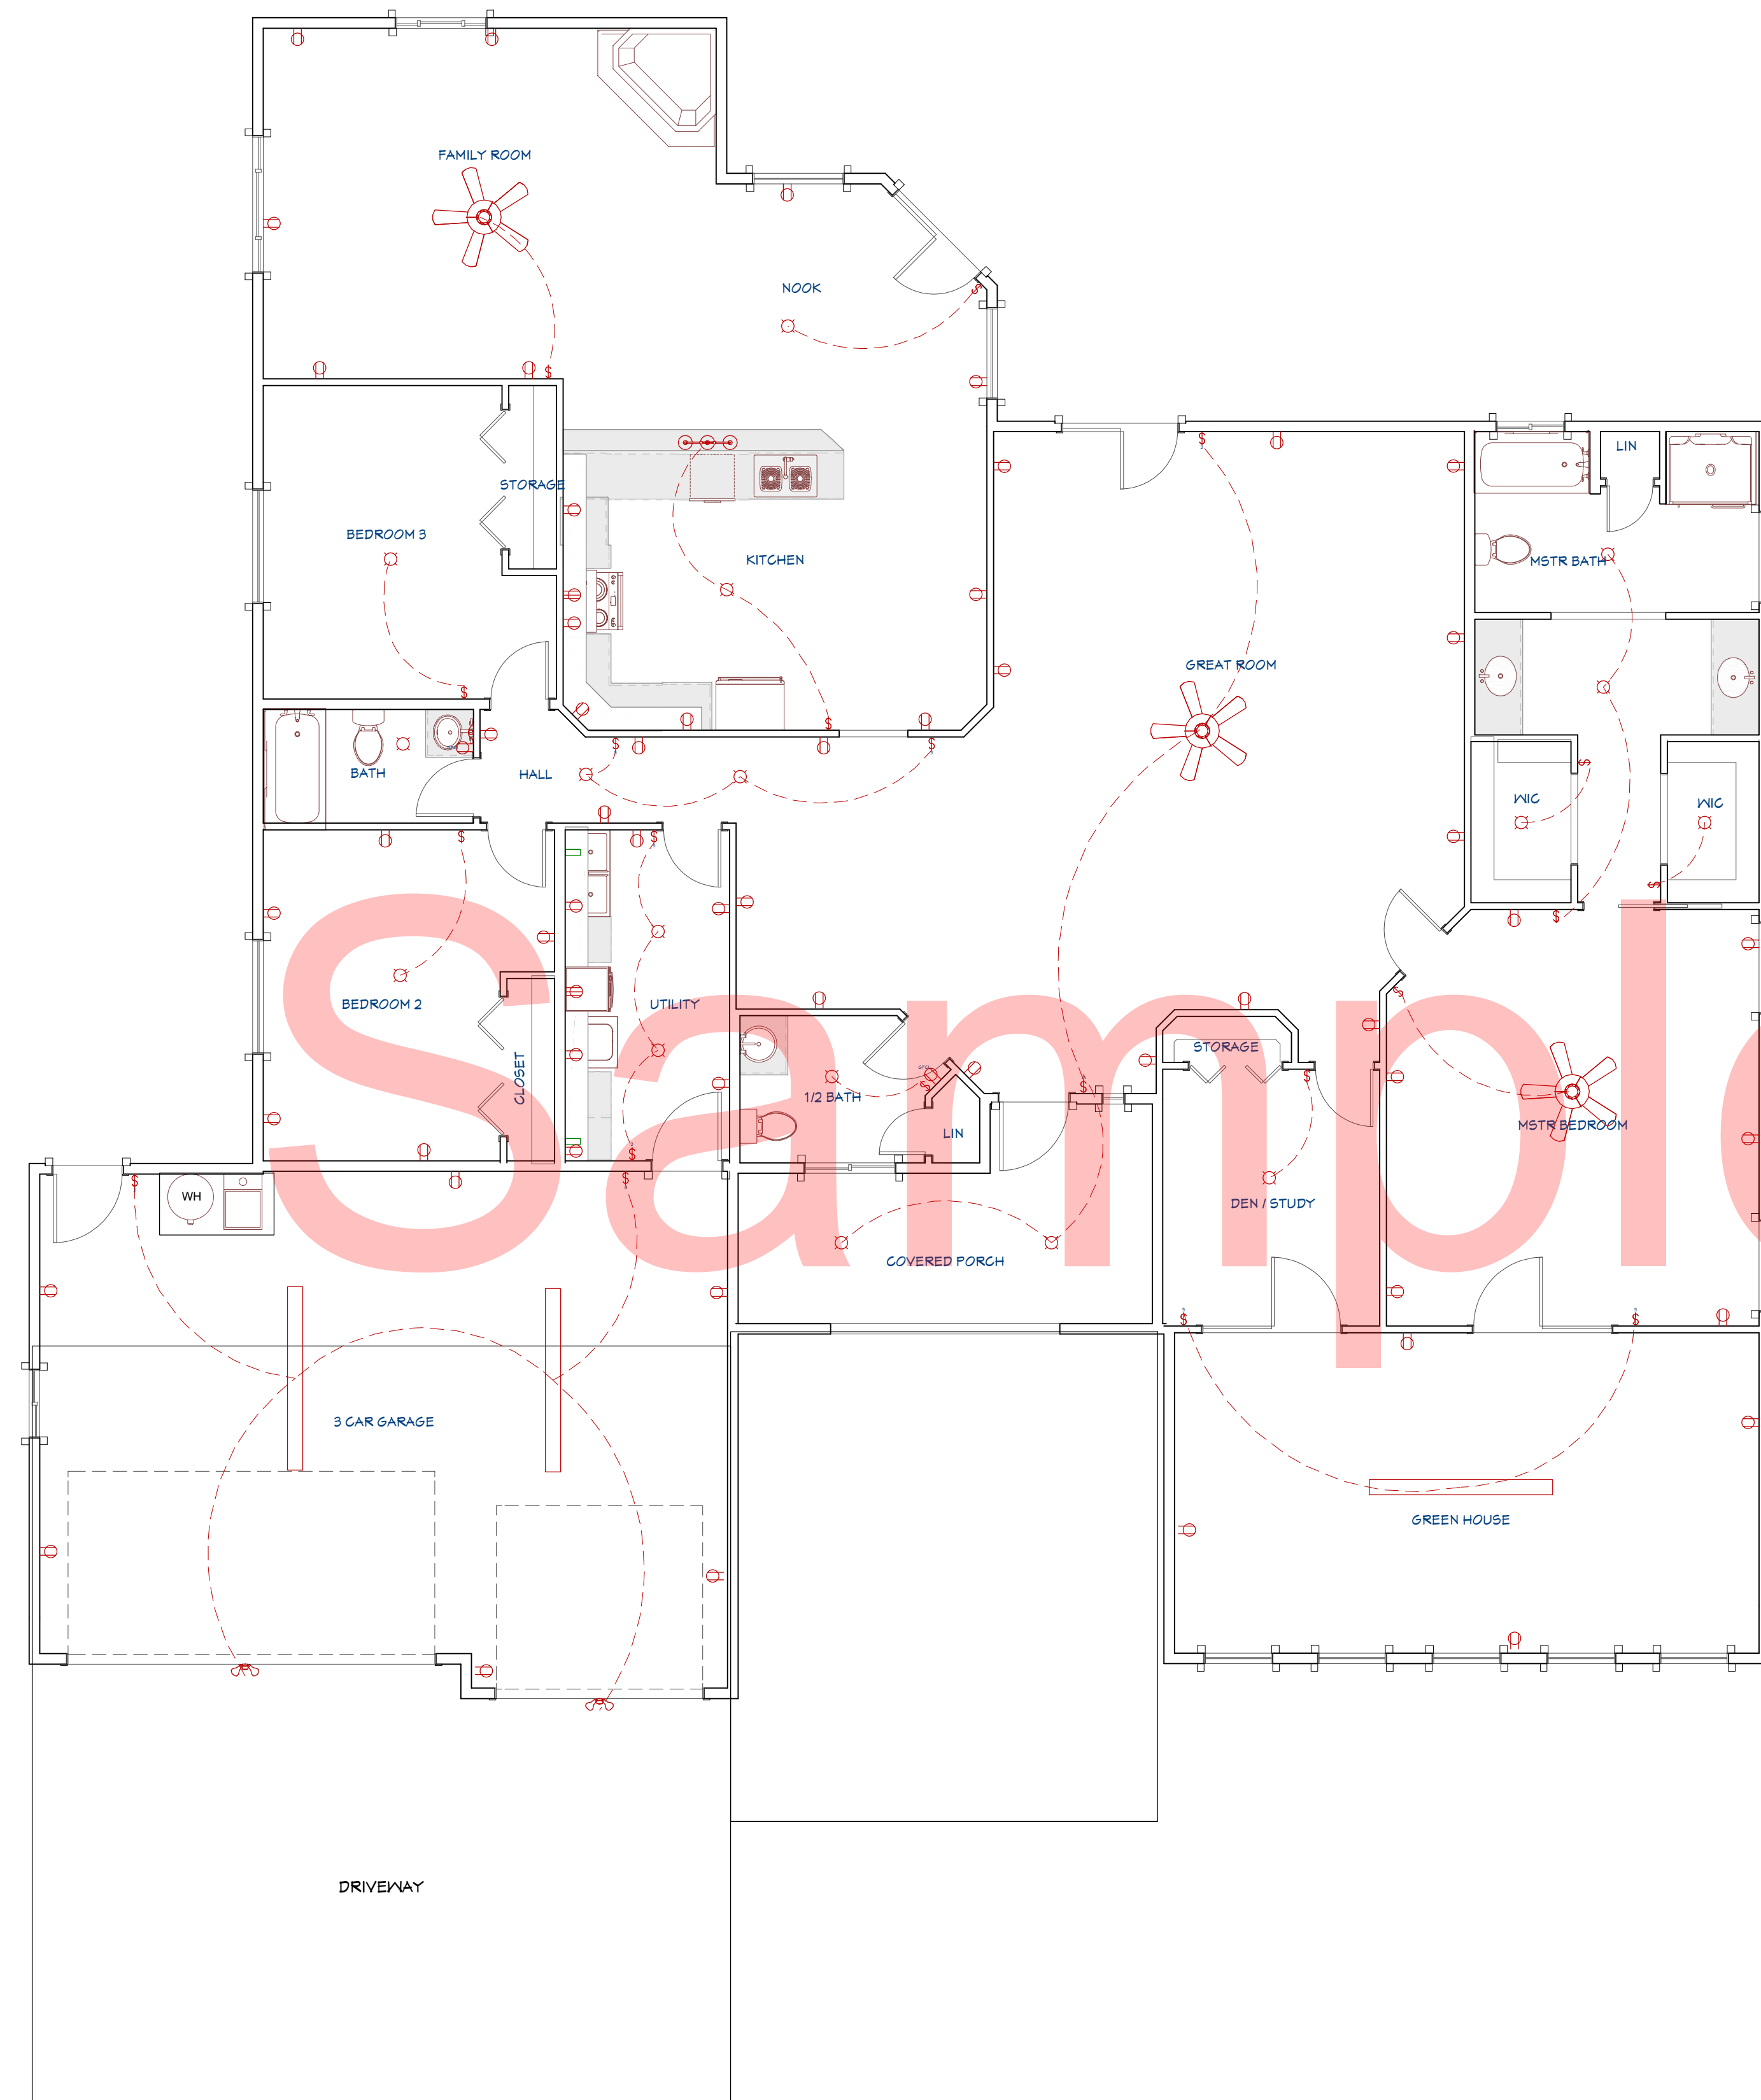

Electrical Plan View  
3/16"=1'=0"

ELECTRICAL SCHEDULE				
2D SYMBOL	NUMBER	QTY	DESCRIPTION	COMMENTS
⊕	E01	2	220V	
⊥	E02	10	3-WAY SWITCH	
⊕	E03	3	CLASSIC CEILING FAN LIGHT FIXTURE	
⊕	E04	17	COMMON FLUSH MOUNT	
⊕	E05	56	DUPLEX	
⊕	E06	2	GFCI	
⊕	E07	1	GRAN TENOS	
⊕	E08	3	LONG SURFACE MOUNTED TUBE LIGHT (96x49D)	
⊥	E09	11	SINGLE POLE SWITCH	
⊕	E10	2	SPOTLIGHT 2 MOTION SENSOR	
⊕	E11	1	TRIPLE CLASSIC	



NTS

REVISION TABLE	
NUMBER	DATE

REVISION TABLE	REVISION BY	DESCRIPTION

Electrical Plan View

DRAWINGS PROVIDED BY:  
Bill Cullum

DATE:

5/25/2026

SCALE:

as  
shown

SHEET:

A-6



Kitchen View



Front Entry View

Sample only



Master Bath View



3 Car Garage View

REVISION TABLE	
NUMBER	DATE

REVISION TABLE  
 NUMBER DATE  
 REVISION BY DESCRIPTION

Interior Details

DRAWINGS PROVIDED BY:  
 Bill Cullum

DATE:

5/25/2026

SCALE:

as shown

SHEET:

A-7