


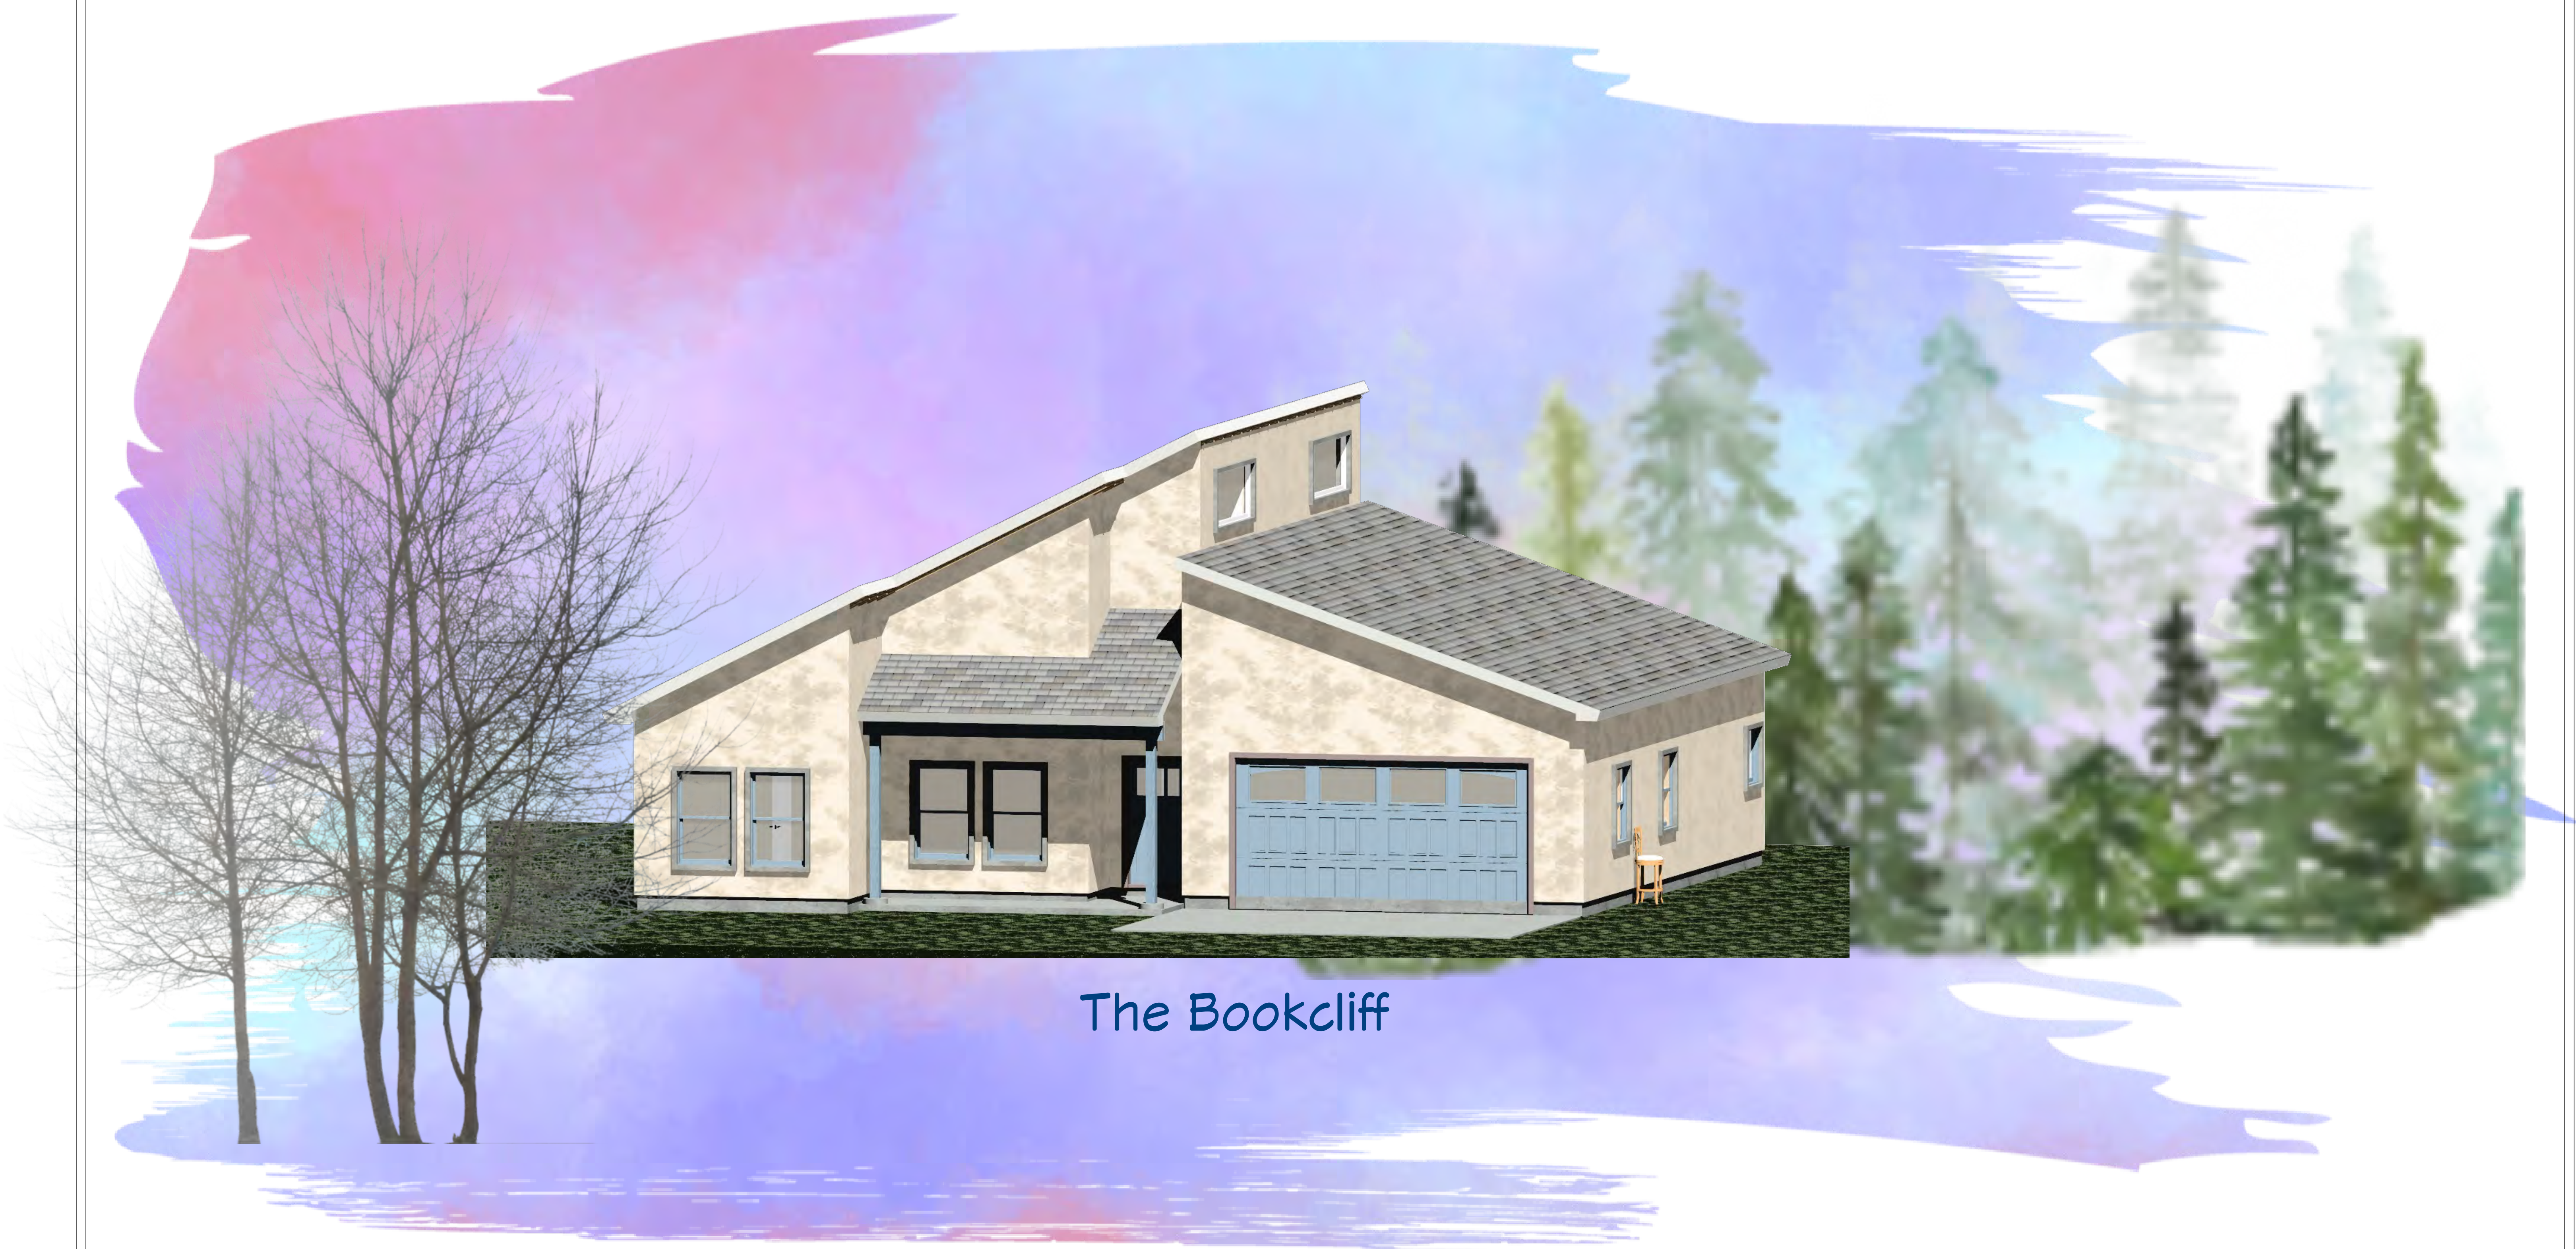

The Bookcliff

Sample

--

REVISION TABLE		REVISION BY	DESCRIPTION
NUMBER	DATE		

--

Project Overview

DRAWINGS PROVIDED BY:
TDS

DATE:


7/6/2025

SCALE:

as shown

SHEET:


P-1

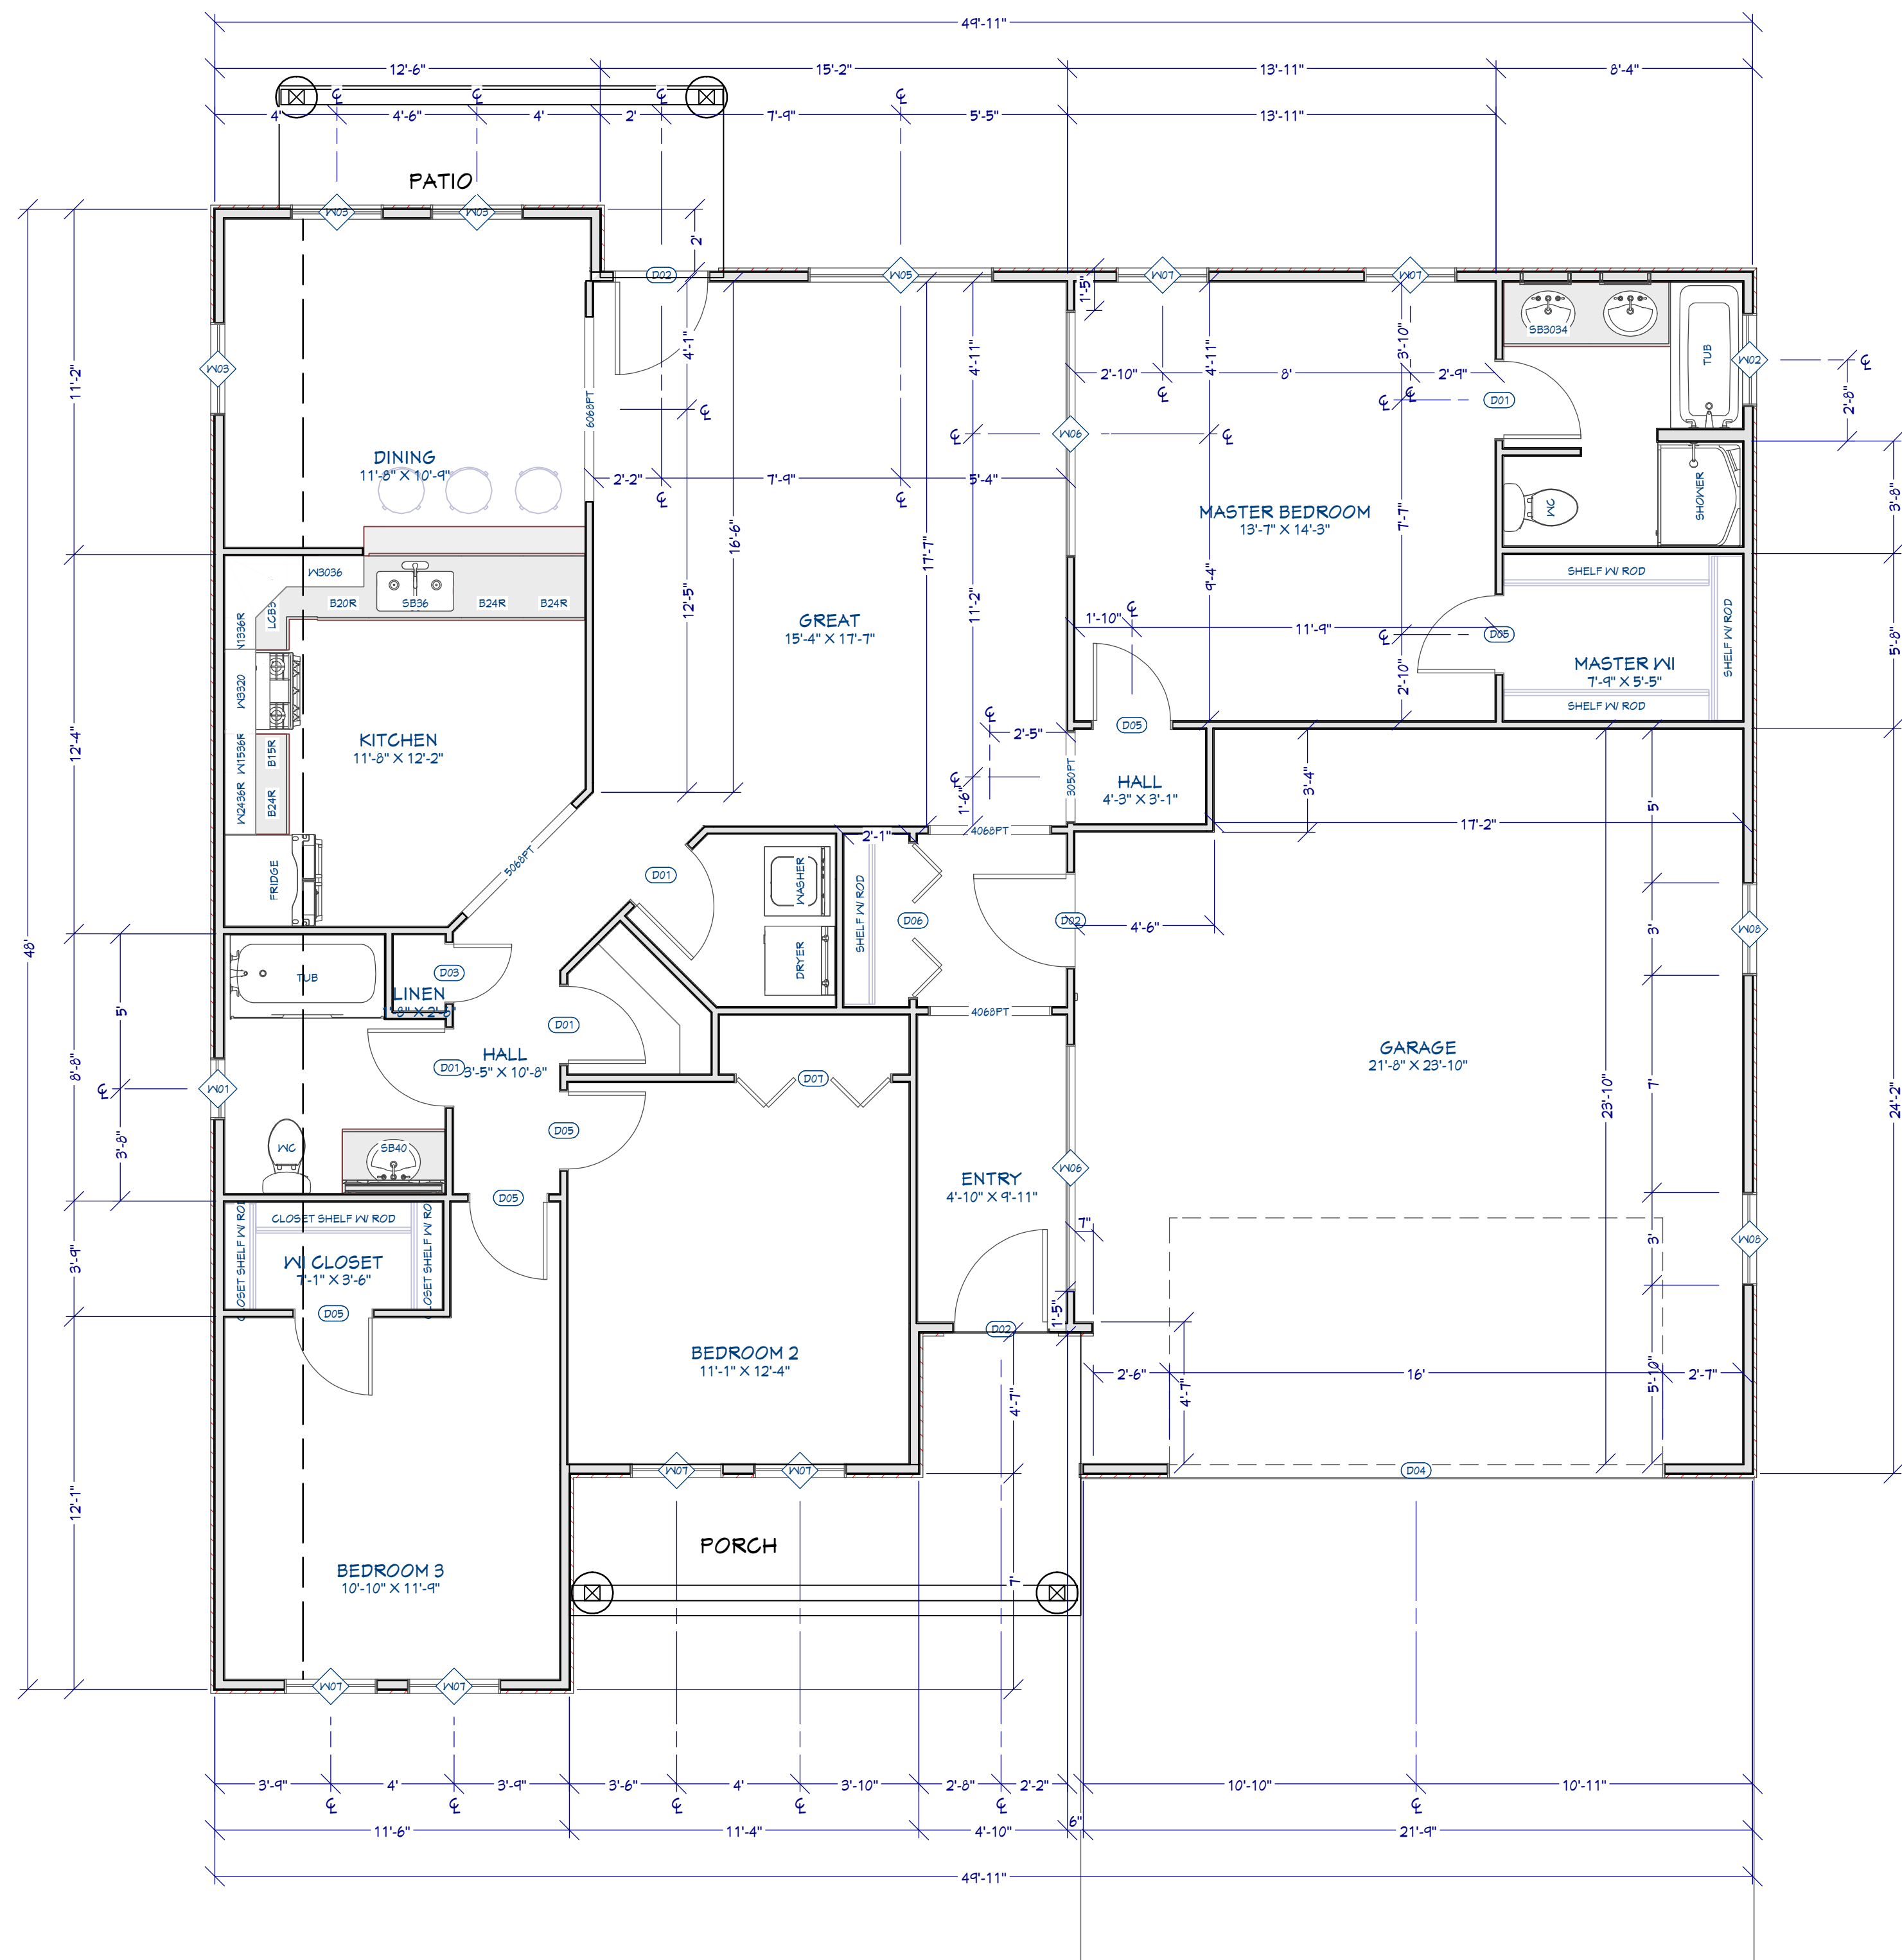


Floor Plan View Dimensioned
Scale: 1/4"=1'-0"

DOOR SCHEDULE						
NUMBER	LABEL	QTY	TYPE	SIZE	R/O	HEADE
D01	2668	4	HINGED	2668 R IN	32"X82 1/2"	2X6X35
D02	3068	3	HINGED	3068 R EX	38"X83"	4X5 1/2
D03	11168	1	HINGED	11168 L IN	24 1/2"X82 1/2"	2X6X27
D04	16080	1	GARAGE	16080	194"X99"	2X12X2
D05	2668	5	HINGED	2668 L IN	32"X82 1/2"	2X6X35
D06	5068	1	4 DR. BIFOLD	5068 L/R	61 7/8"X82 1/2"	2X6X64
D07	5068	1	4 DR. BIFOLD	5068 L/R	62"X82 1/2"	2X6X65

WINDOW SCHEDULE							
NUMBER	LABEL	QTY	TYPE	SIZE	R/O	EGRESS	HEAI
W01	2030RS	1	RIGHT SLIDING	2030RS	25"X37"		2X6X
W02	3030RS	1	RIGHT SLIDING	3030RS	37"X37"		2X6X
W03	3040DH	3	DOUBLE HUNG	3040DH	37"X49"		2X6X
W05	6040DH	1	DOUBLE HUNG	6040DH	73"X49"	YES	2X10
W06	8030FX	2	FIXED GLASS	8030FX	97"X37"		2X12
W07	3050DH	6	DOUBLE HUNG	3050DH	37"X61"	YES	2X6X
W08	3040DH	2	DOUBLE HUNG	3040DH	37"X49"	YES	2X6X

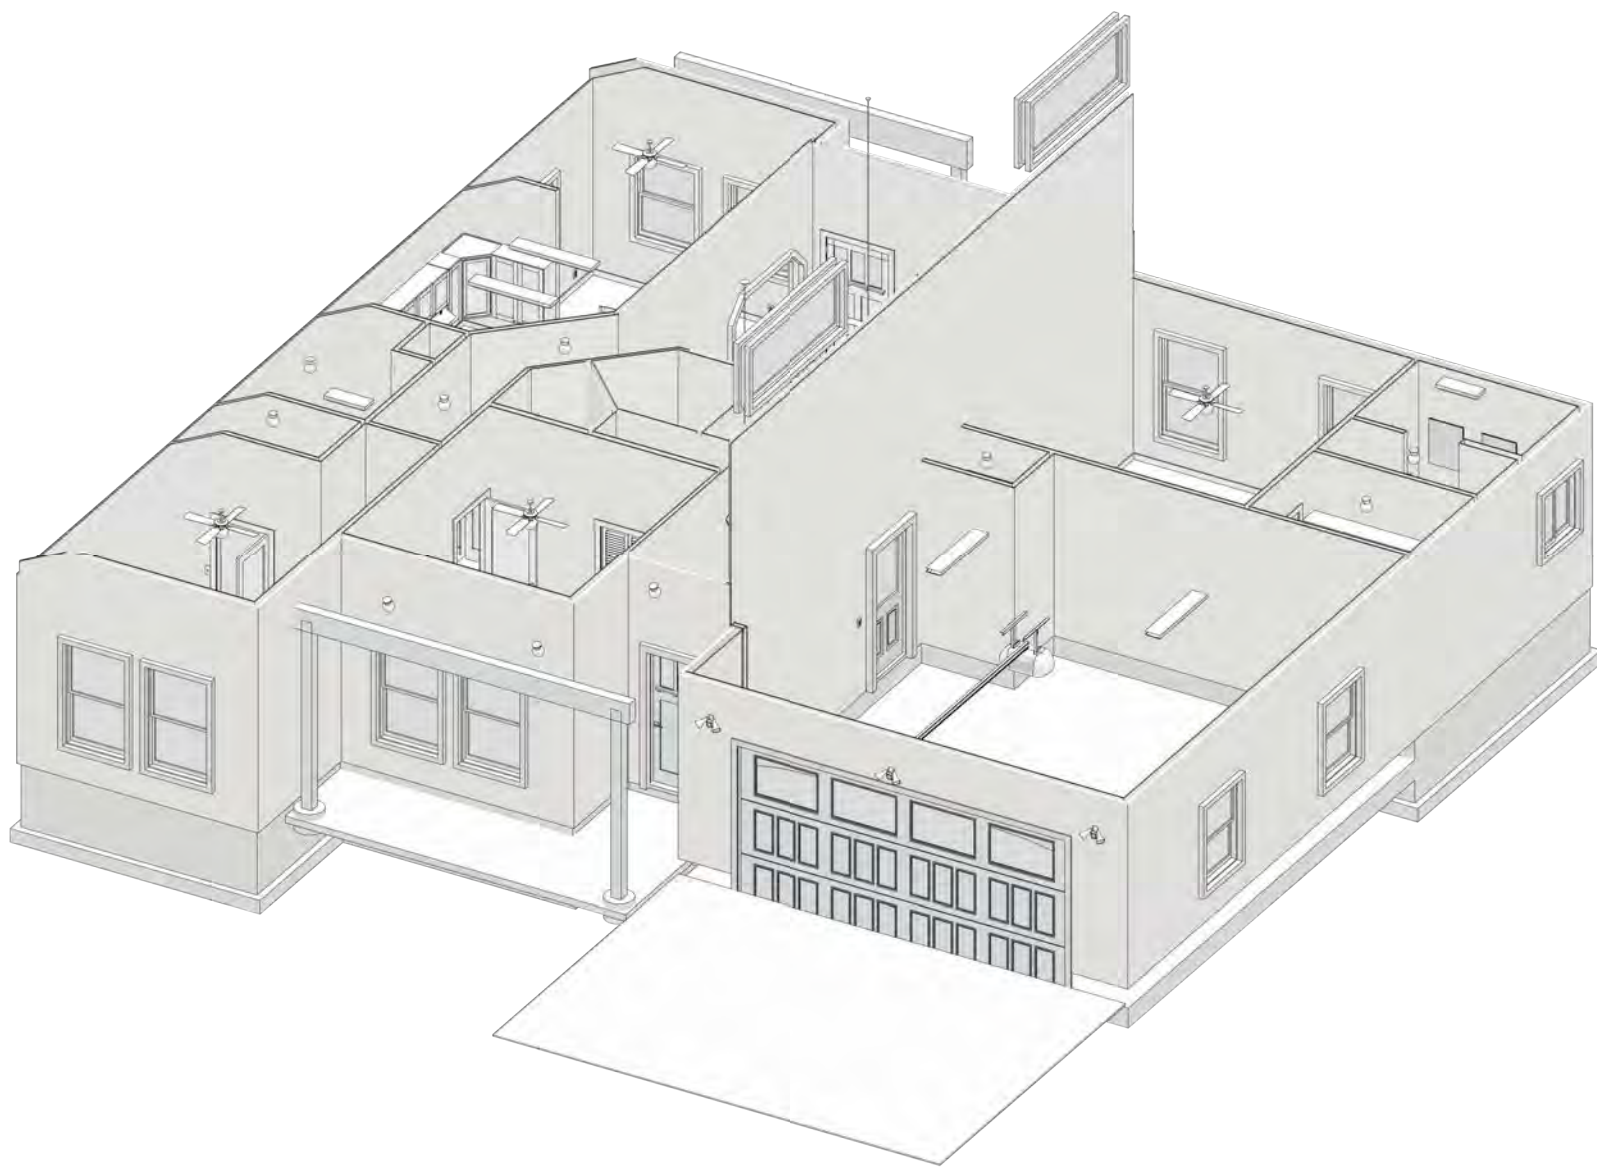

REVISION TABLE		DESCRIPTION
NUMBER	DATE	

 

Floor Plan View
Dimensioned

DRAWINGS PROVIDED BY:
TDS

DATE:

7/6/2025


SCALE:

as shown


SHEET:

P-2

Sample

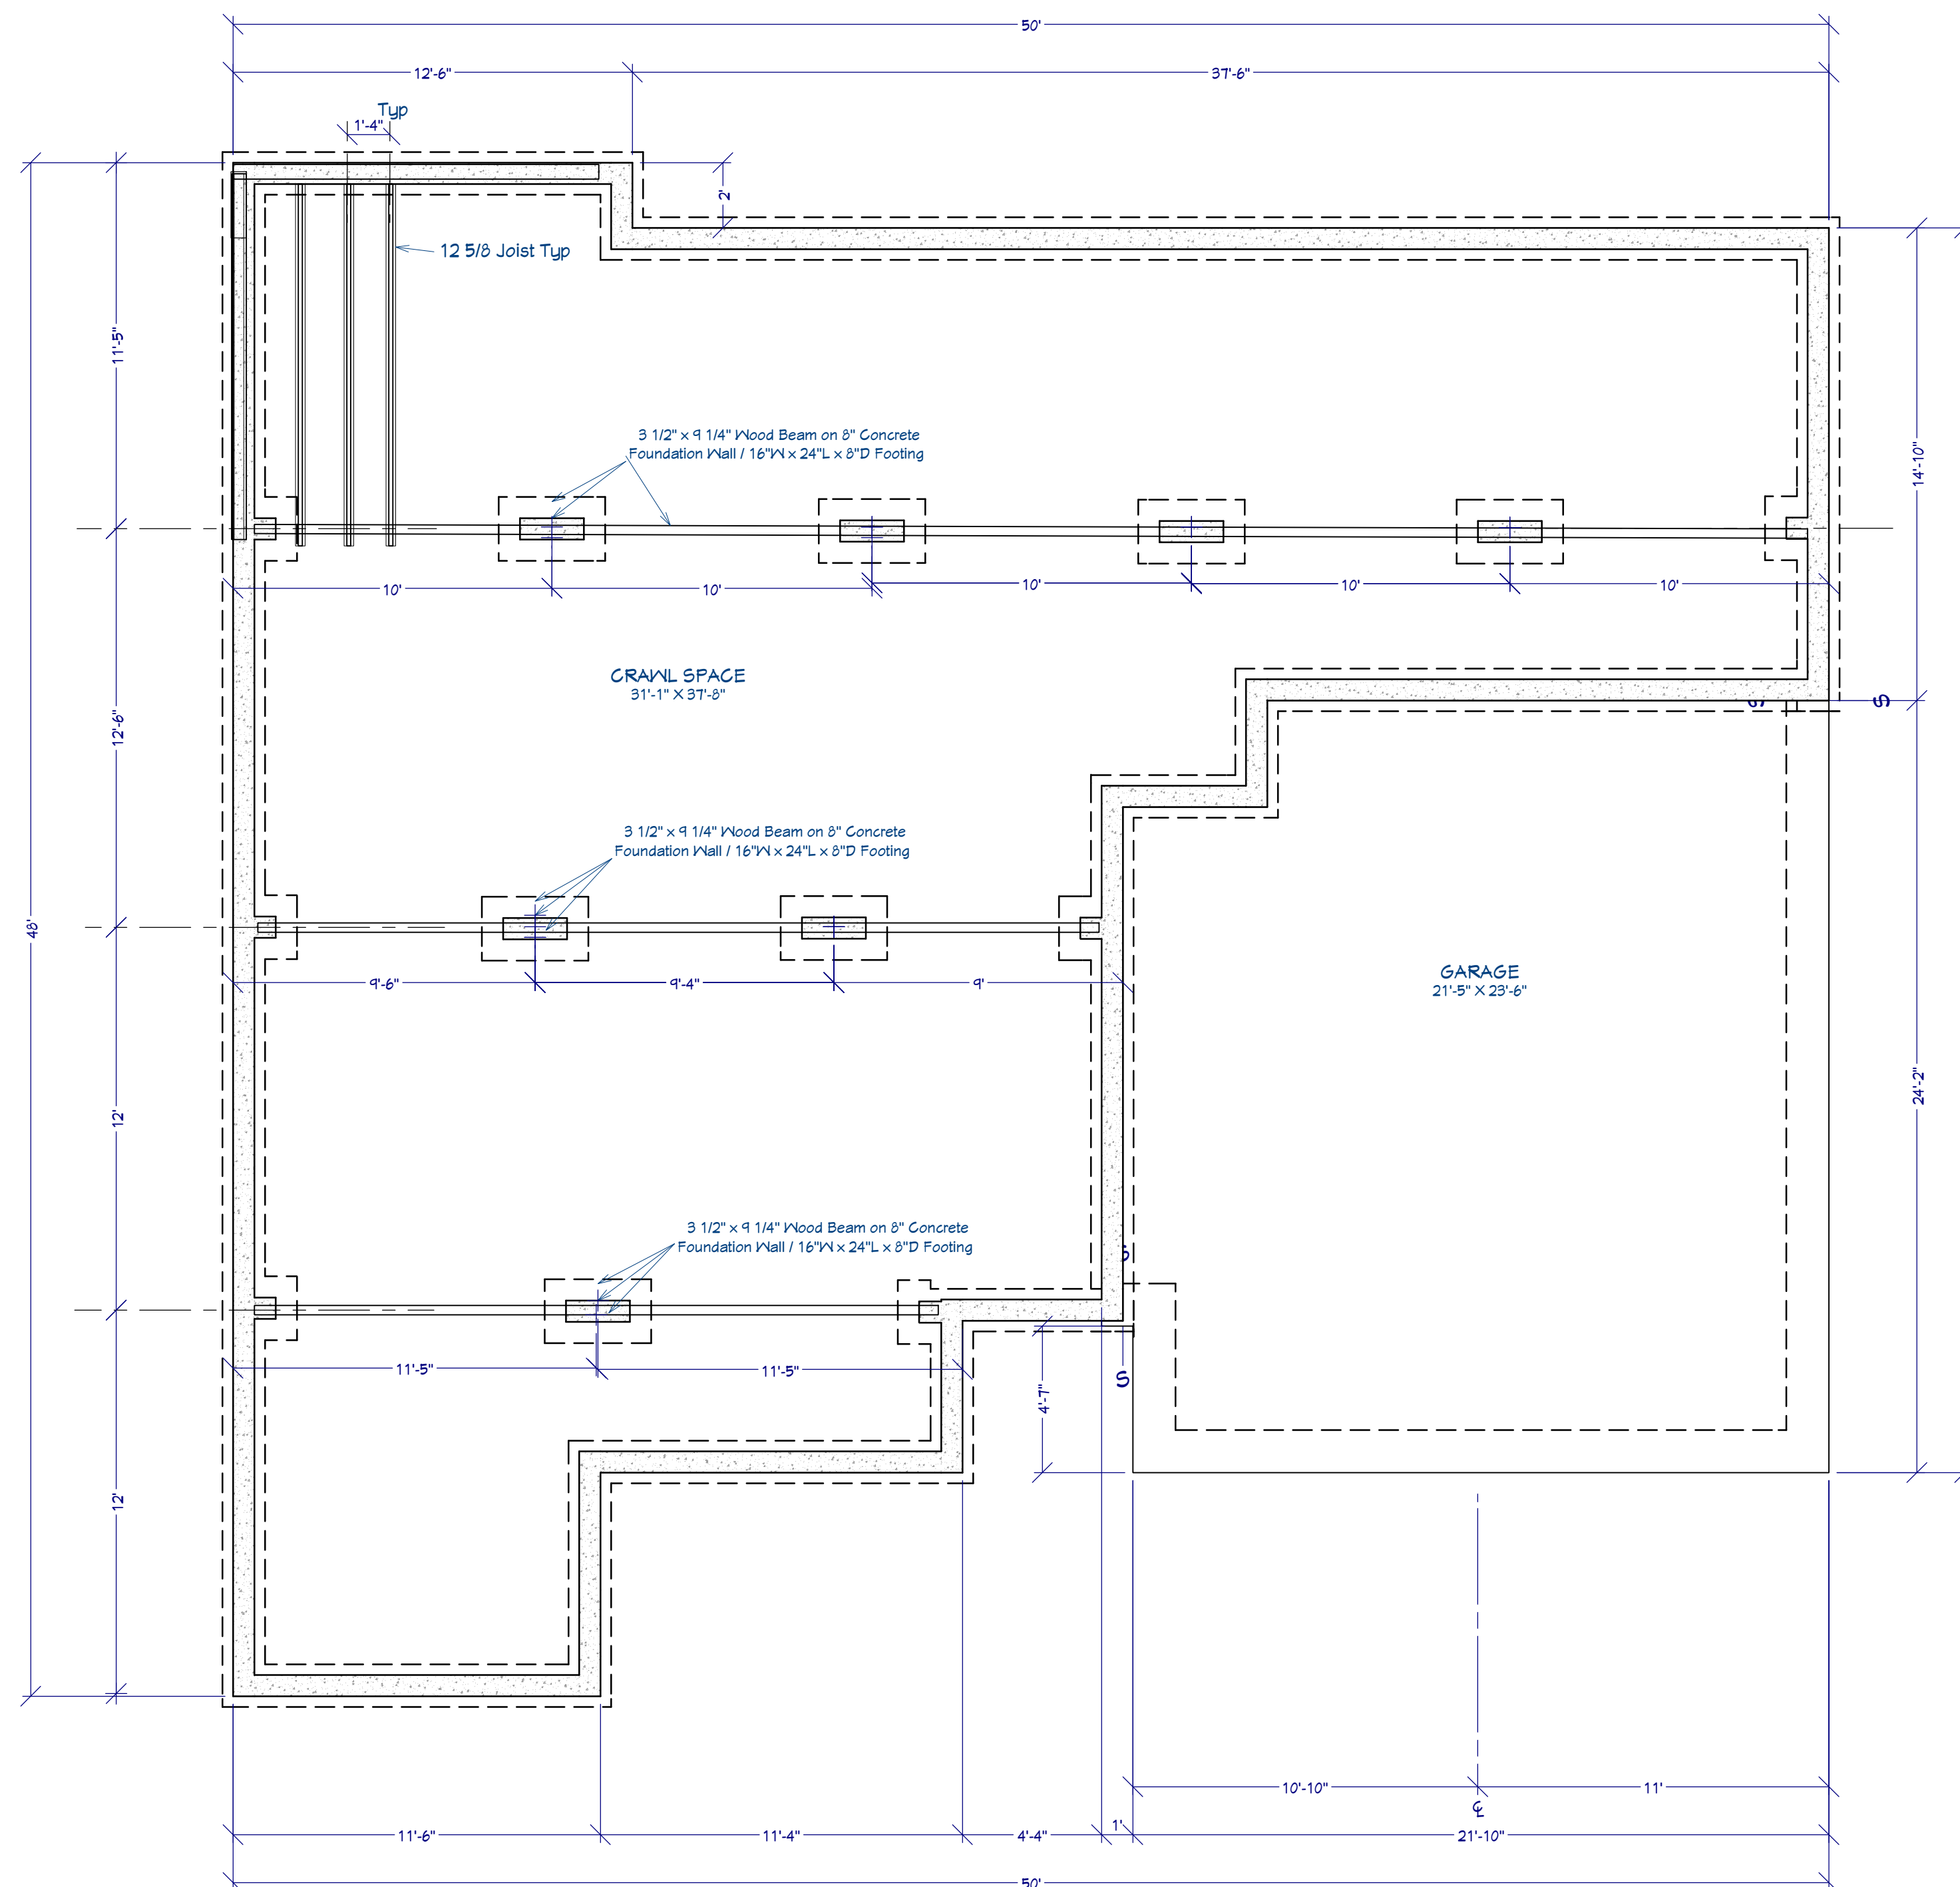


Foundation Plan View Dimensioned
Scale: 1/4"=1'-0"

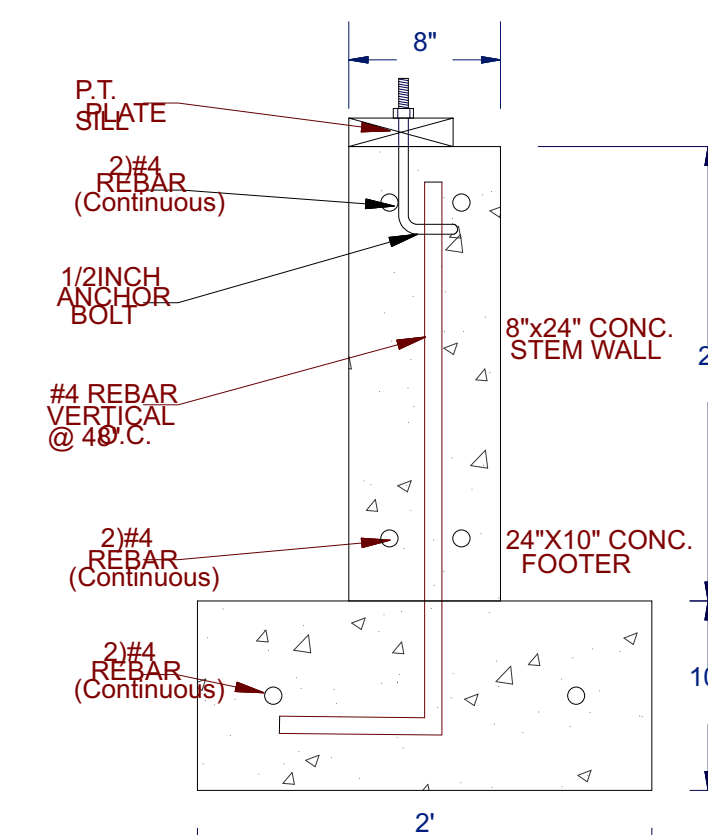


Typical Application around
Perimeter Stem Walls

NOTE:
ALL REBAR PER LOCAL CODE
AND /OR ENGINEER'S DESIGN

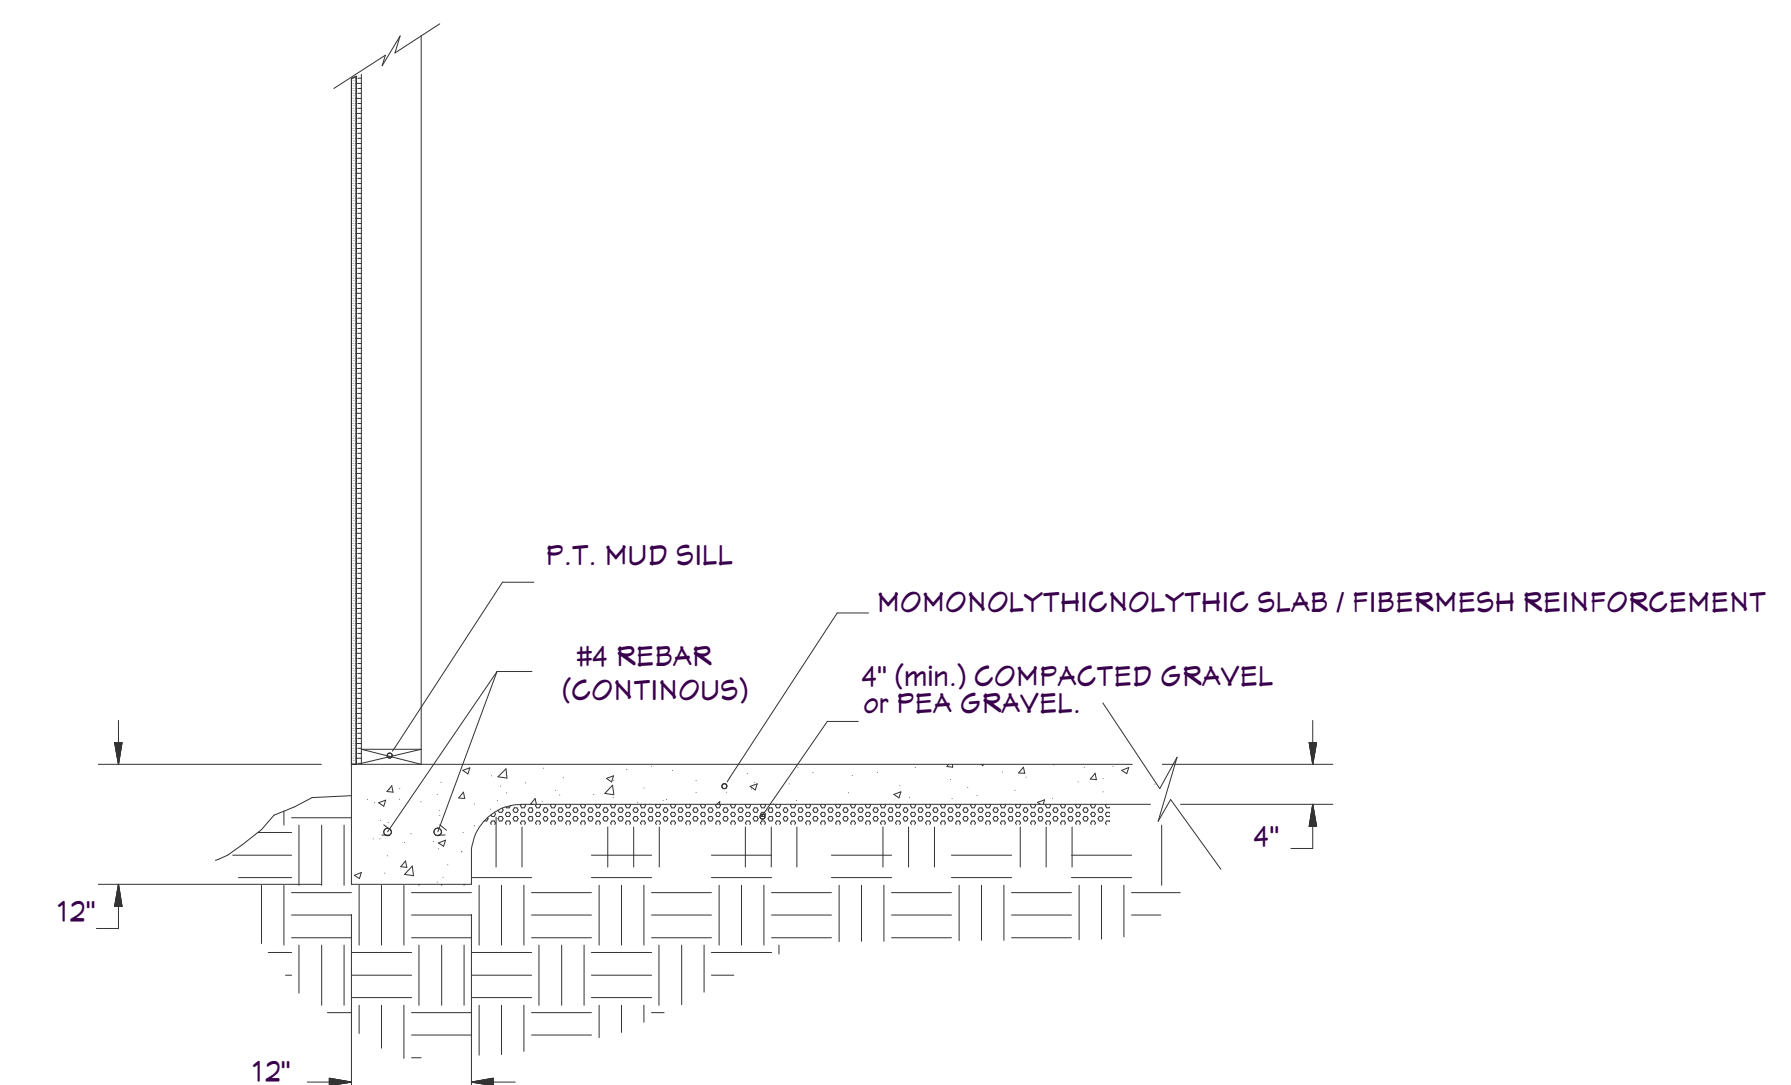


Garage Floor Section

NOTE:
ALL REBAR PER LOCAL CODE
AND /OR ENGINEER'S DESIGN

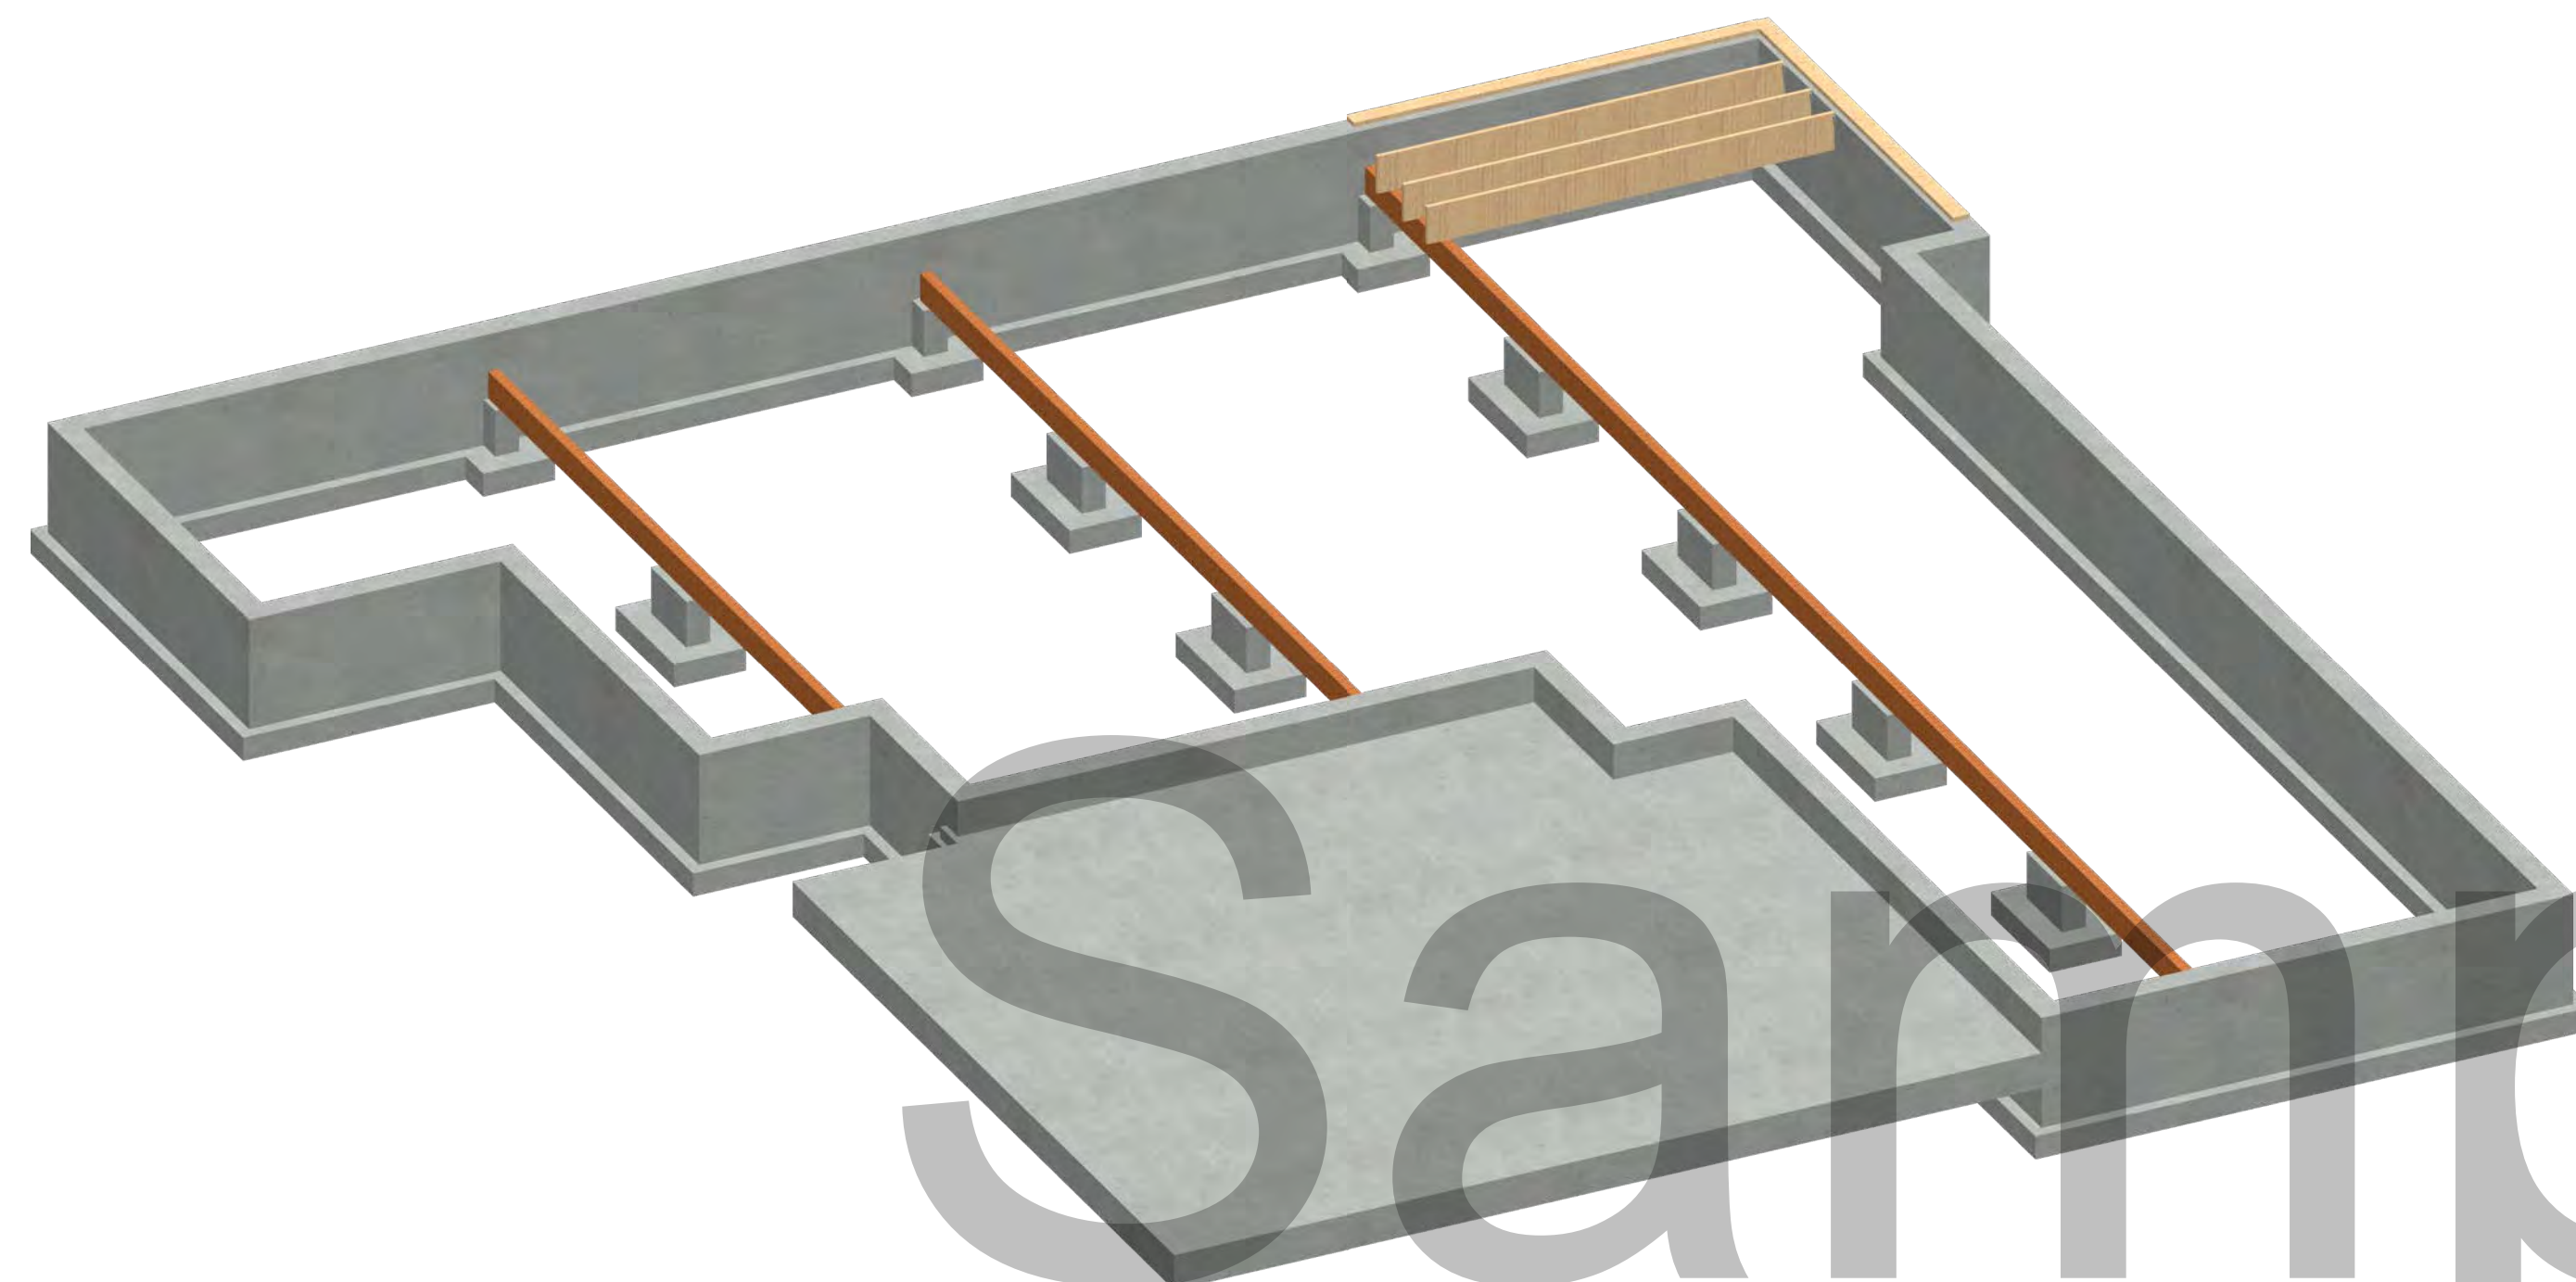




Exterior Elevation Front
Scale 3/16"=1'-0"

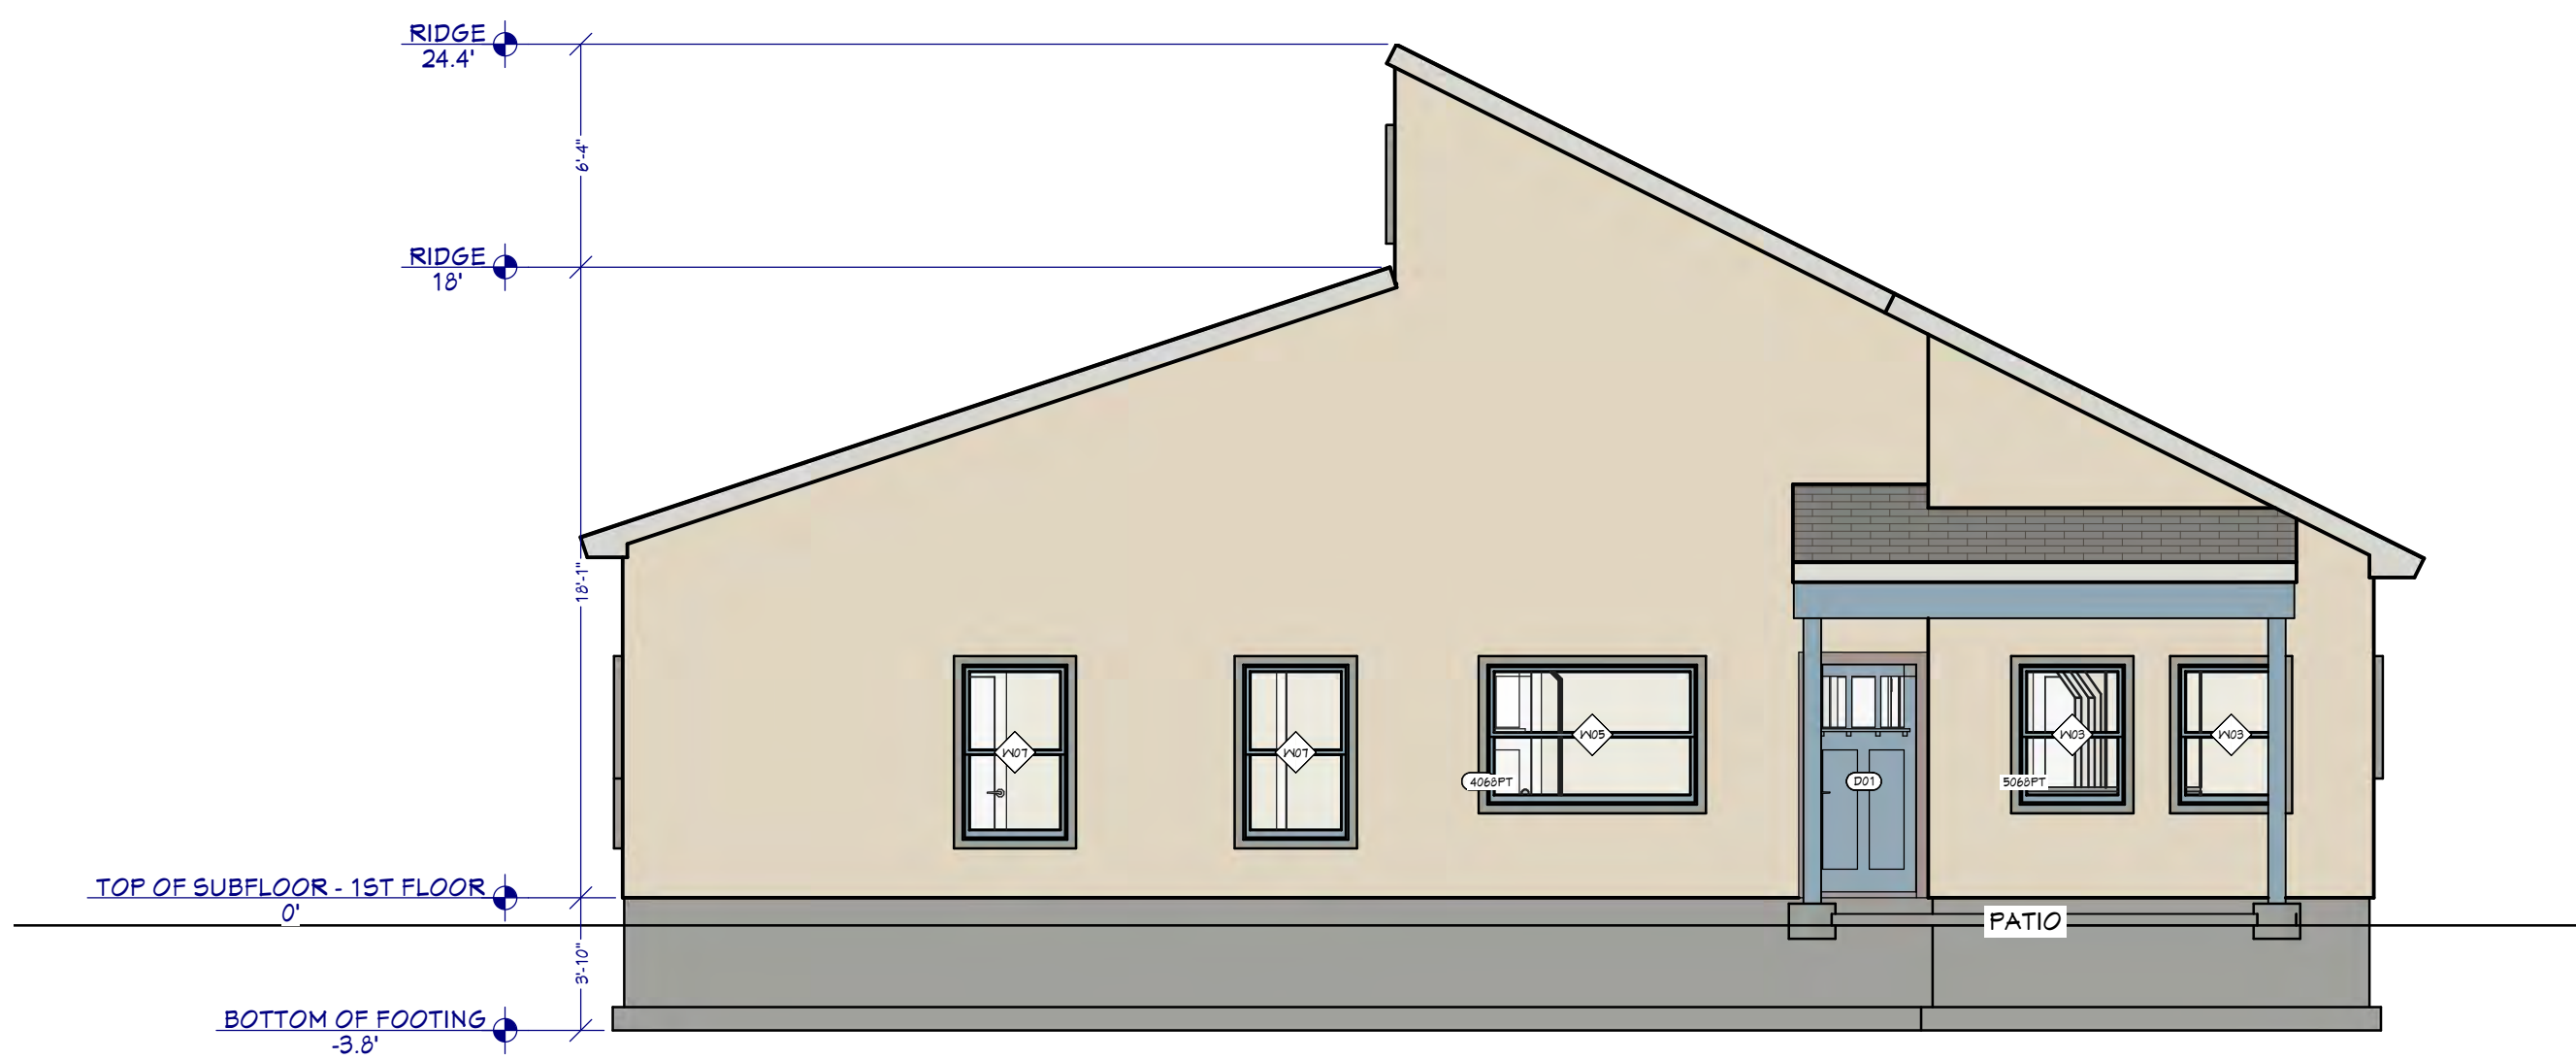


Exterior Elevation Back
Scale 3/16"=1'-0"

DOOR SCHEDULE						
NUMBER	LABEL	QTY	TYPE	SIZE	R/O	HEADER
D01	2668	4	HINGED	2668 R IN	32"X82 1/2"	2X6X35" (2)
D02	3068	3	HINGED	3068 R EX	38"X83"	4X5 1/2X41" (2)
D03	11168	1	HINGED	11168 L IN	24 1/2"X82 1/2"	2X6X27 1/2" (2)
D04	16080	1	GARAGE	16080	194"X99"	2X12X200" (2)
D05	2668	5	HINGED	2668 L IN	32"X82 1/2"	2X6X35" (2)
D06	5068	1	4 DR. BIFOLD	5068 L/R	61 7/8"X82 1/2"	2X6X64 7/8" (2)
D07	5068	1	4 DR. BIFOLD	5068 L/R	62"X82 1/2"	2X6X65" (2)

WINDOW SCHEDULE						
NUMBER	LABEL	QTY	TYPE	SIZE	R/O	EGRESS
W01	2030RS	1	RIGHT SLIDING	2030RS	25"X37"	2X6X28" (2)
W02	3030RS	1	RIGHT SLIDING	3030RS	37"X37"	2X6X40" (2)
W03	3040DH	3	DOUBLE HUNG	3040DH	37"X49"	2X6X40" (2)
W05	6040DH	1	DOUBLE HUNG	6040DH	73"X49"	2X10X76" (2)
W06	8030FX	2	FIXED GLASS	8030FX	47"X37"	2X12X100" (2)
W07	3050DH	6	DOUBLE HUNG	3050DH	37"X61"	2X6X40" (2)
W08	3040DH	2	DOUBLE HUNG	3040DH	37"X49"	2X6X40" (2)

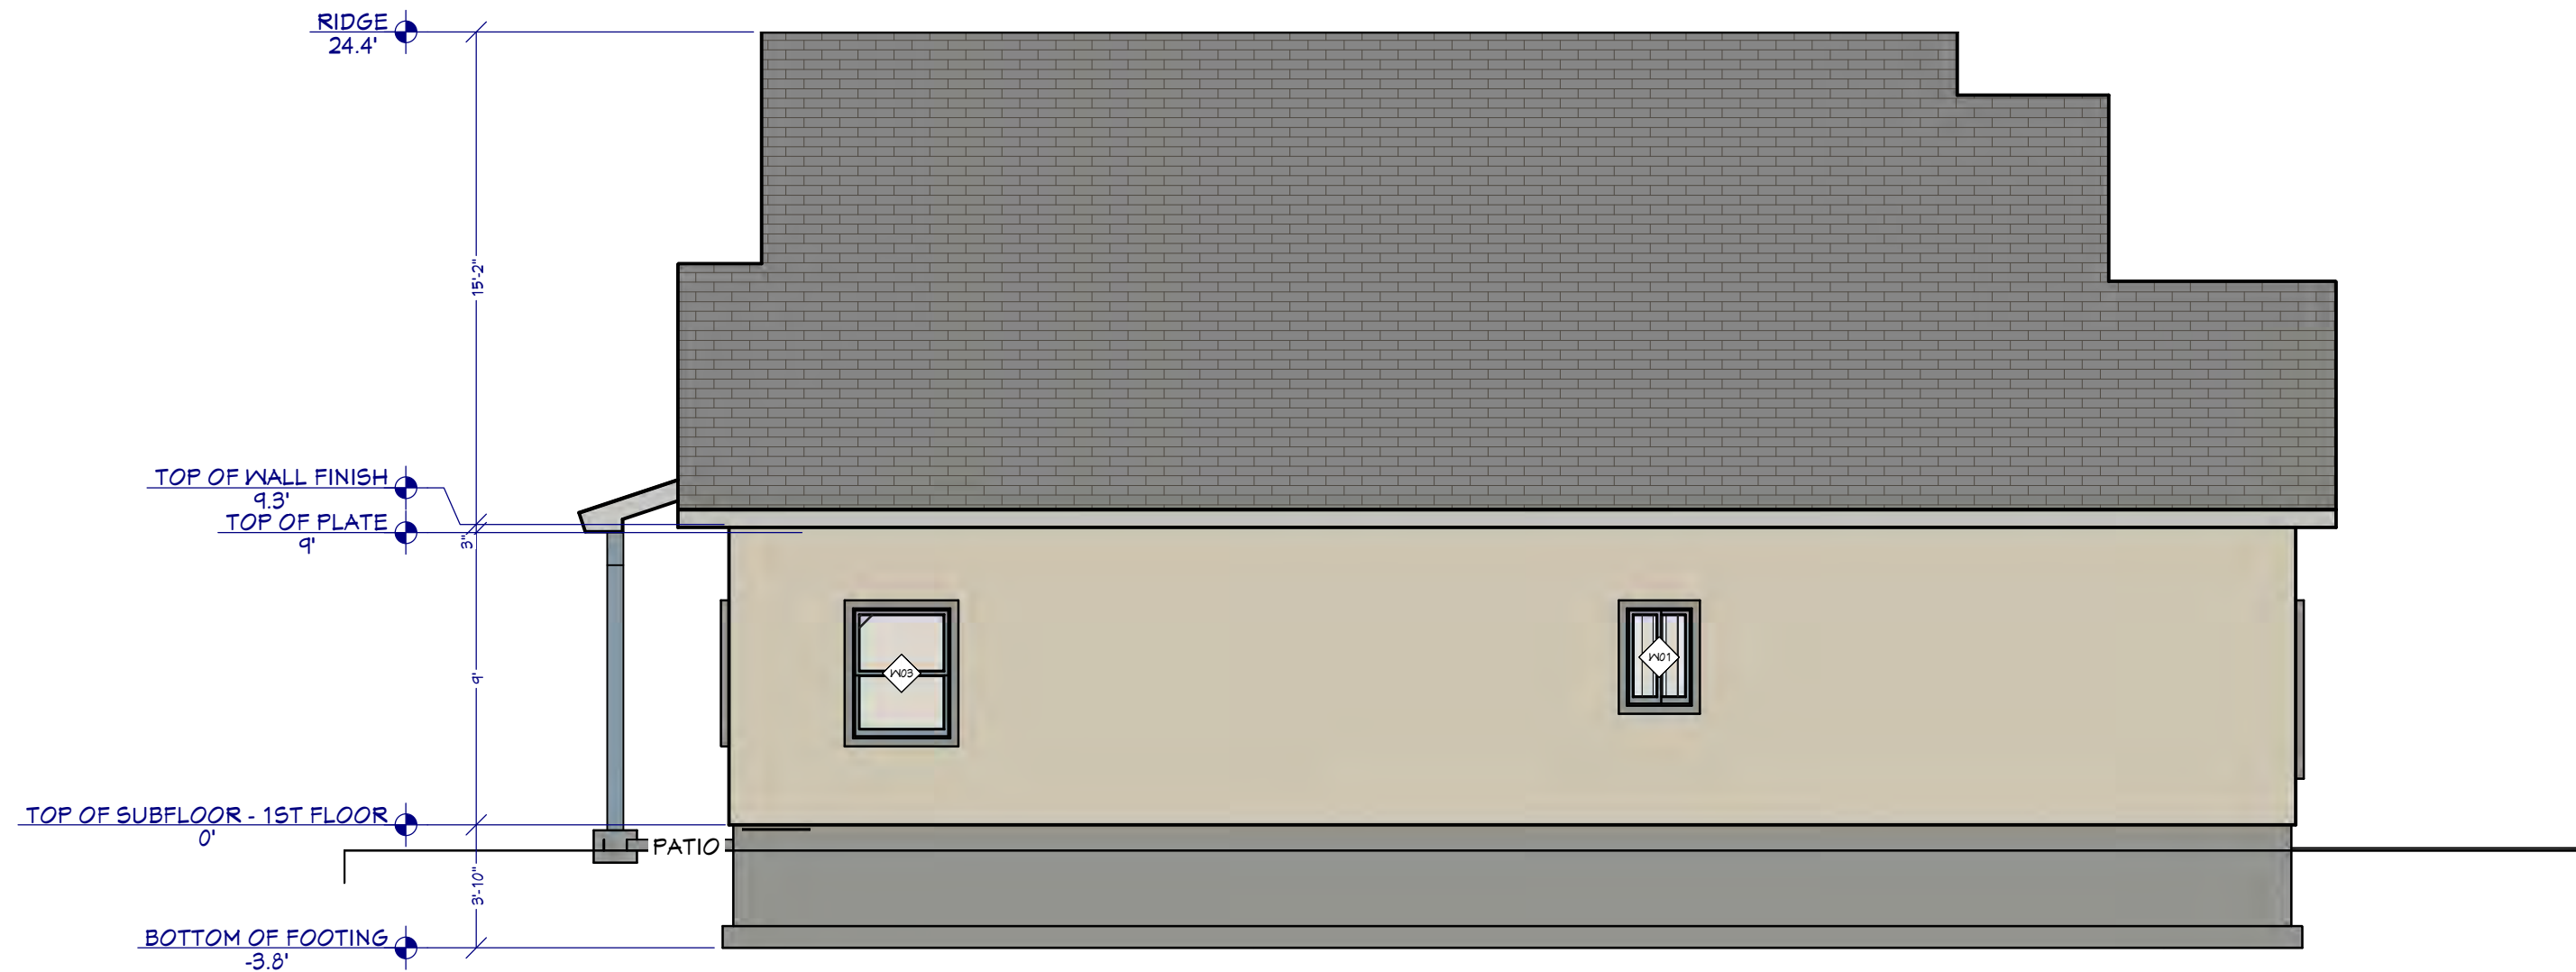

Exterior Elevation Left
Scale 3/16"=1'-0"

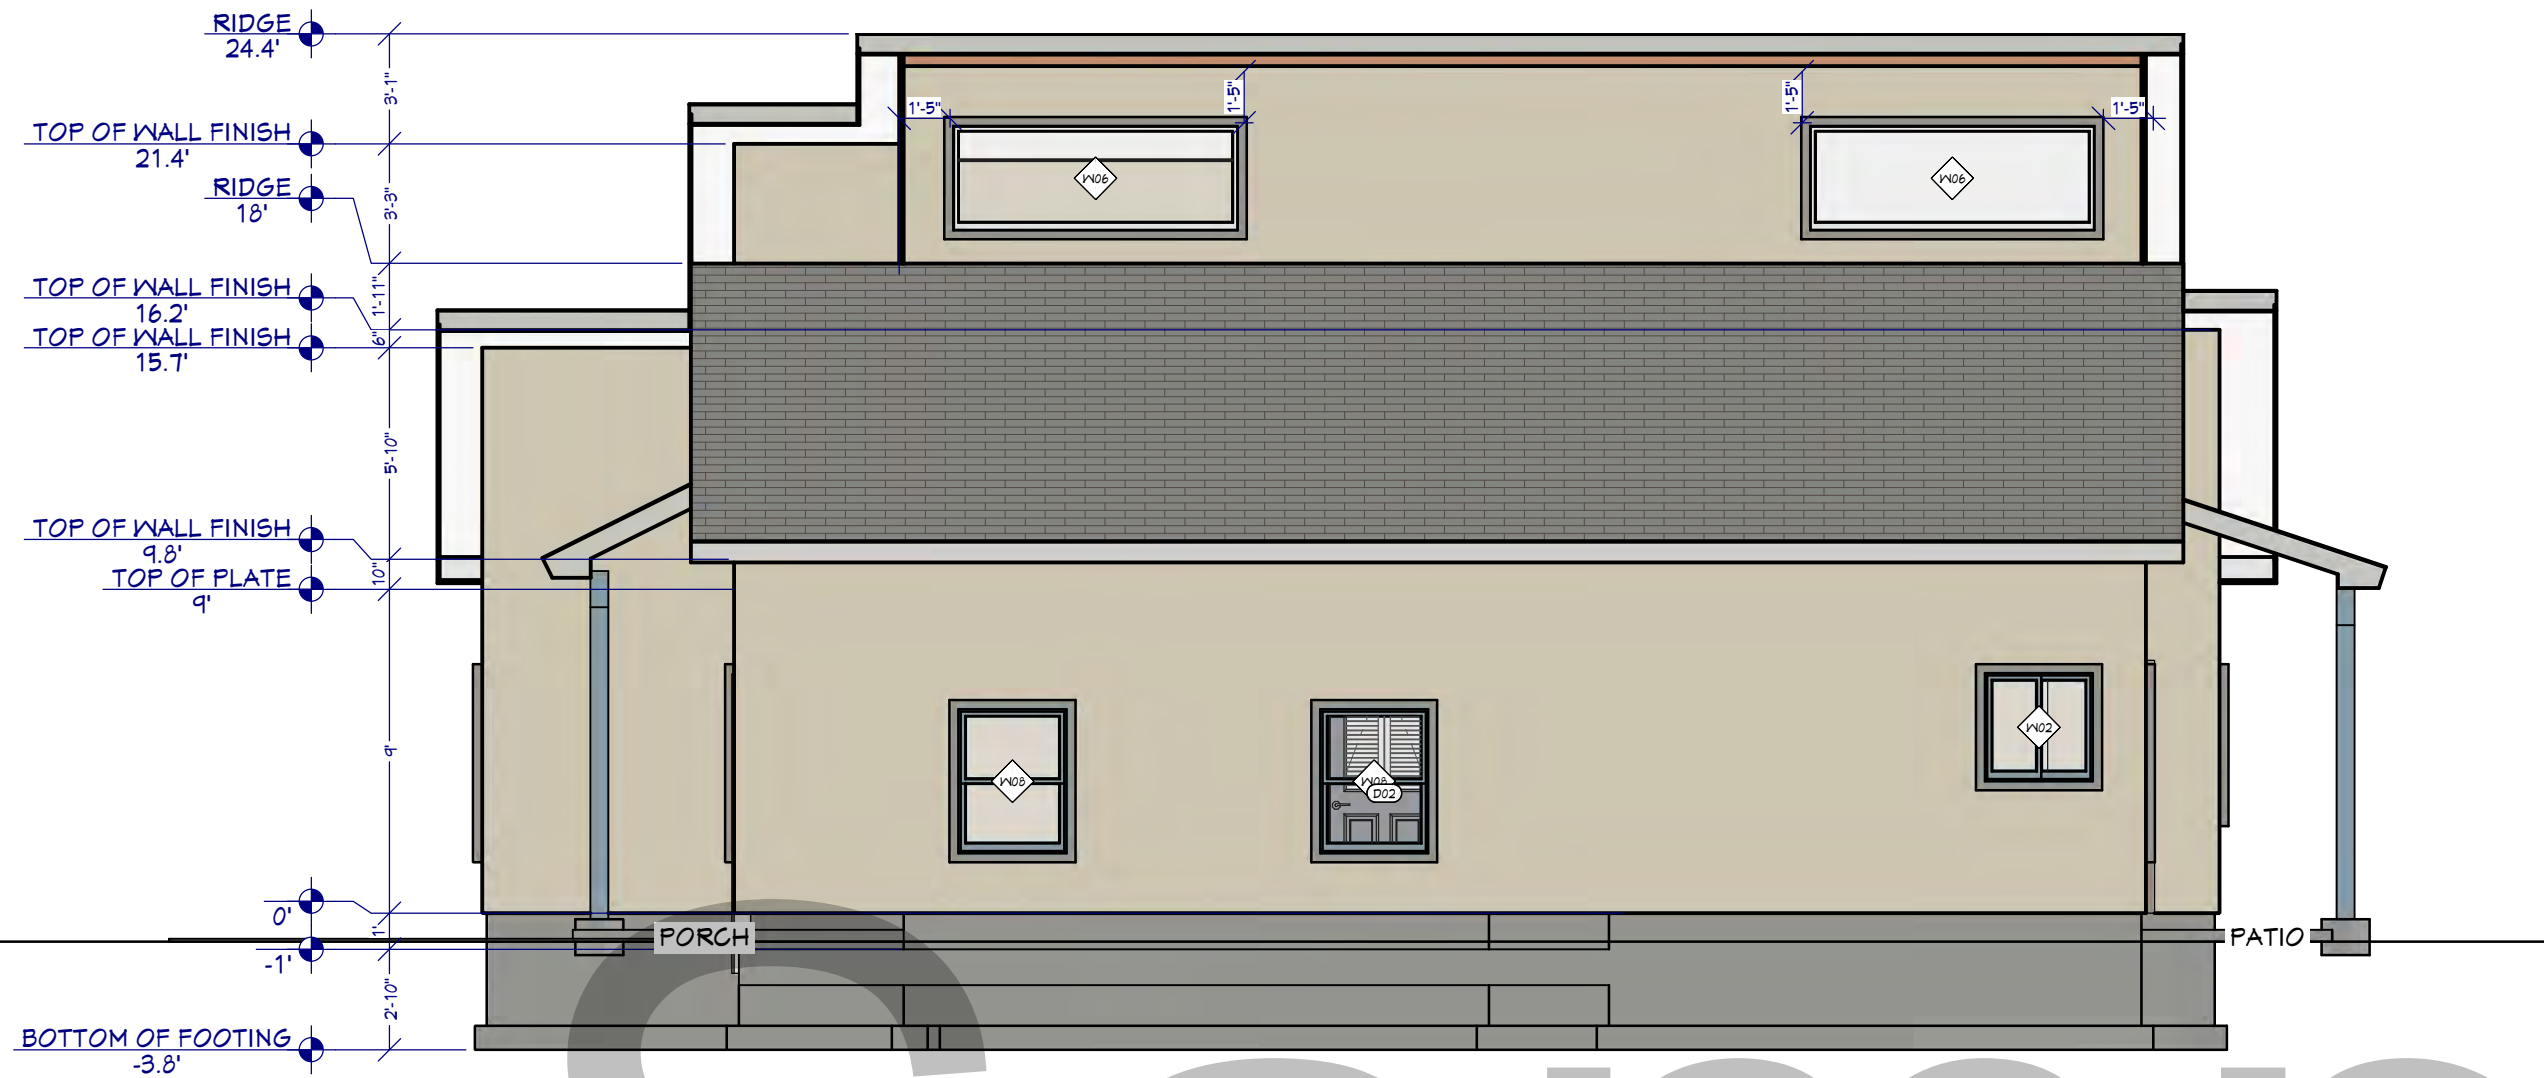

Exterior Elevation Right
Scale 3/16"=1'-0"

REVISION TABLE		DESCRIPTION
NUMBER	DATE	REVISION BY

Exterior Elevations

DRAWINGS PROVIDED BY:
TDS

DATE:


7/6/2025

SCALE:

as shown

SHEET:

P-4

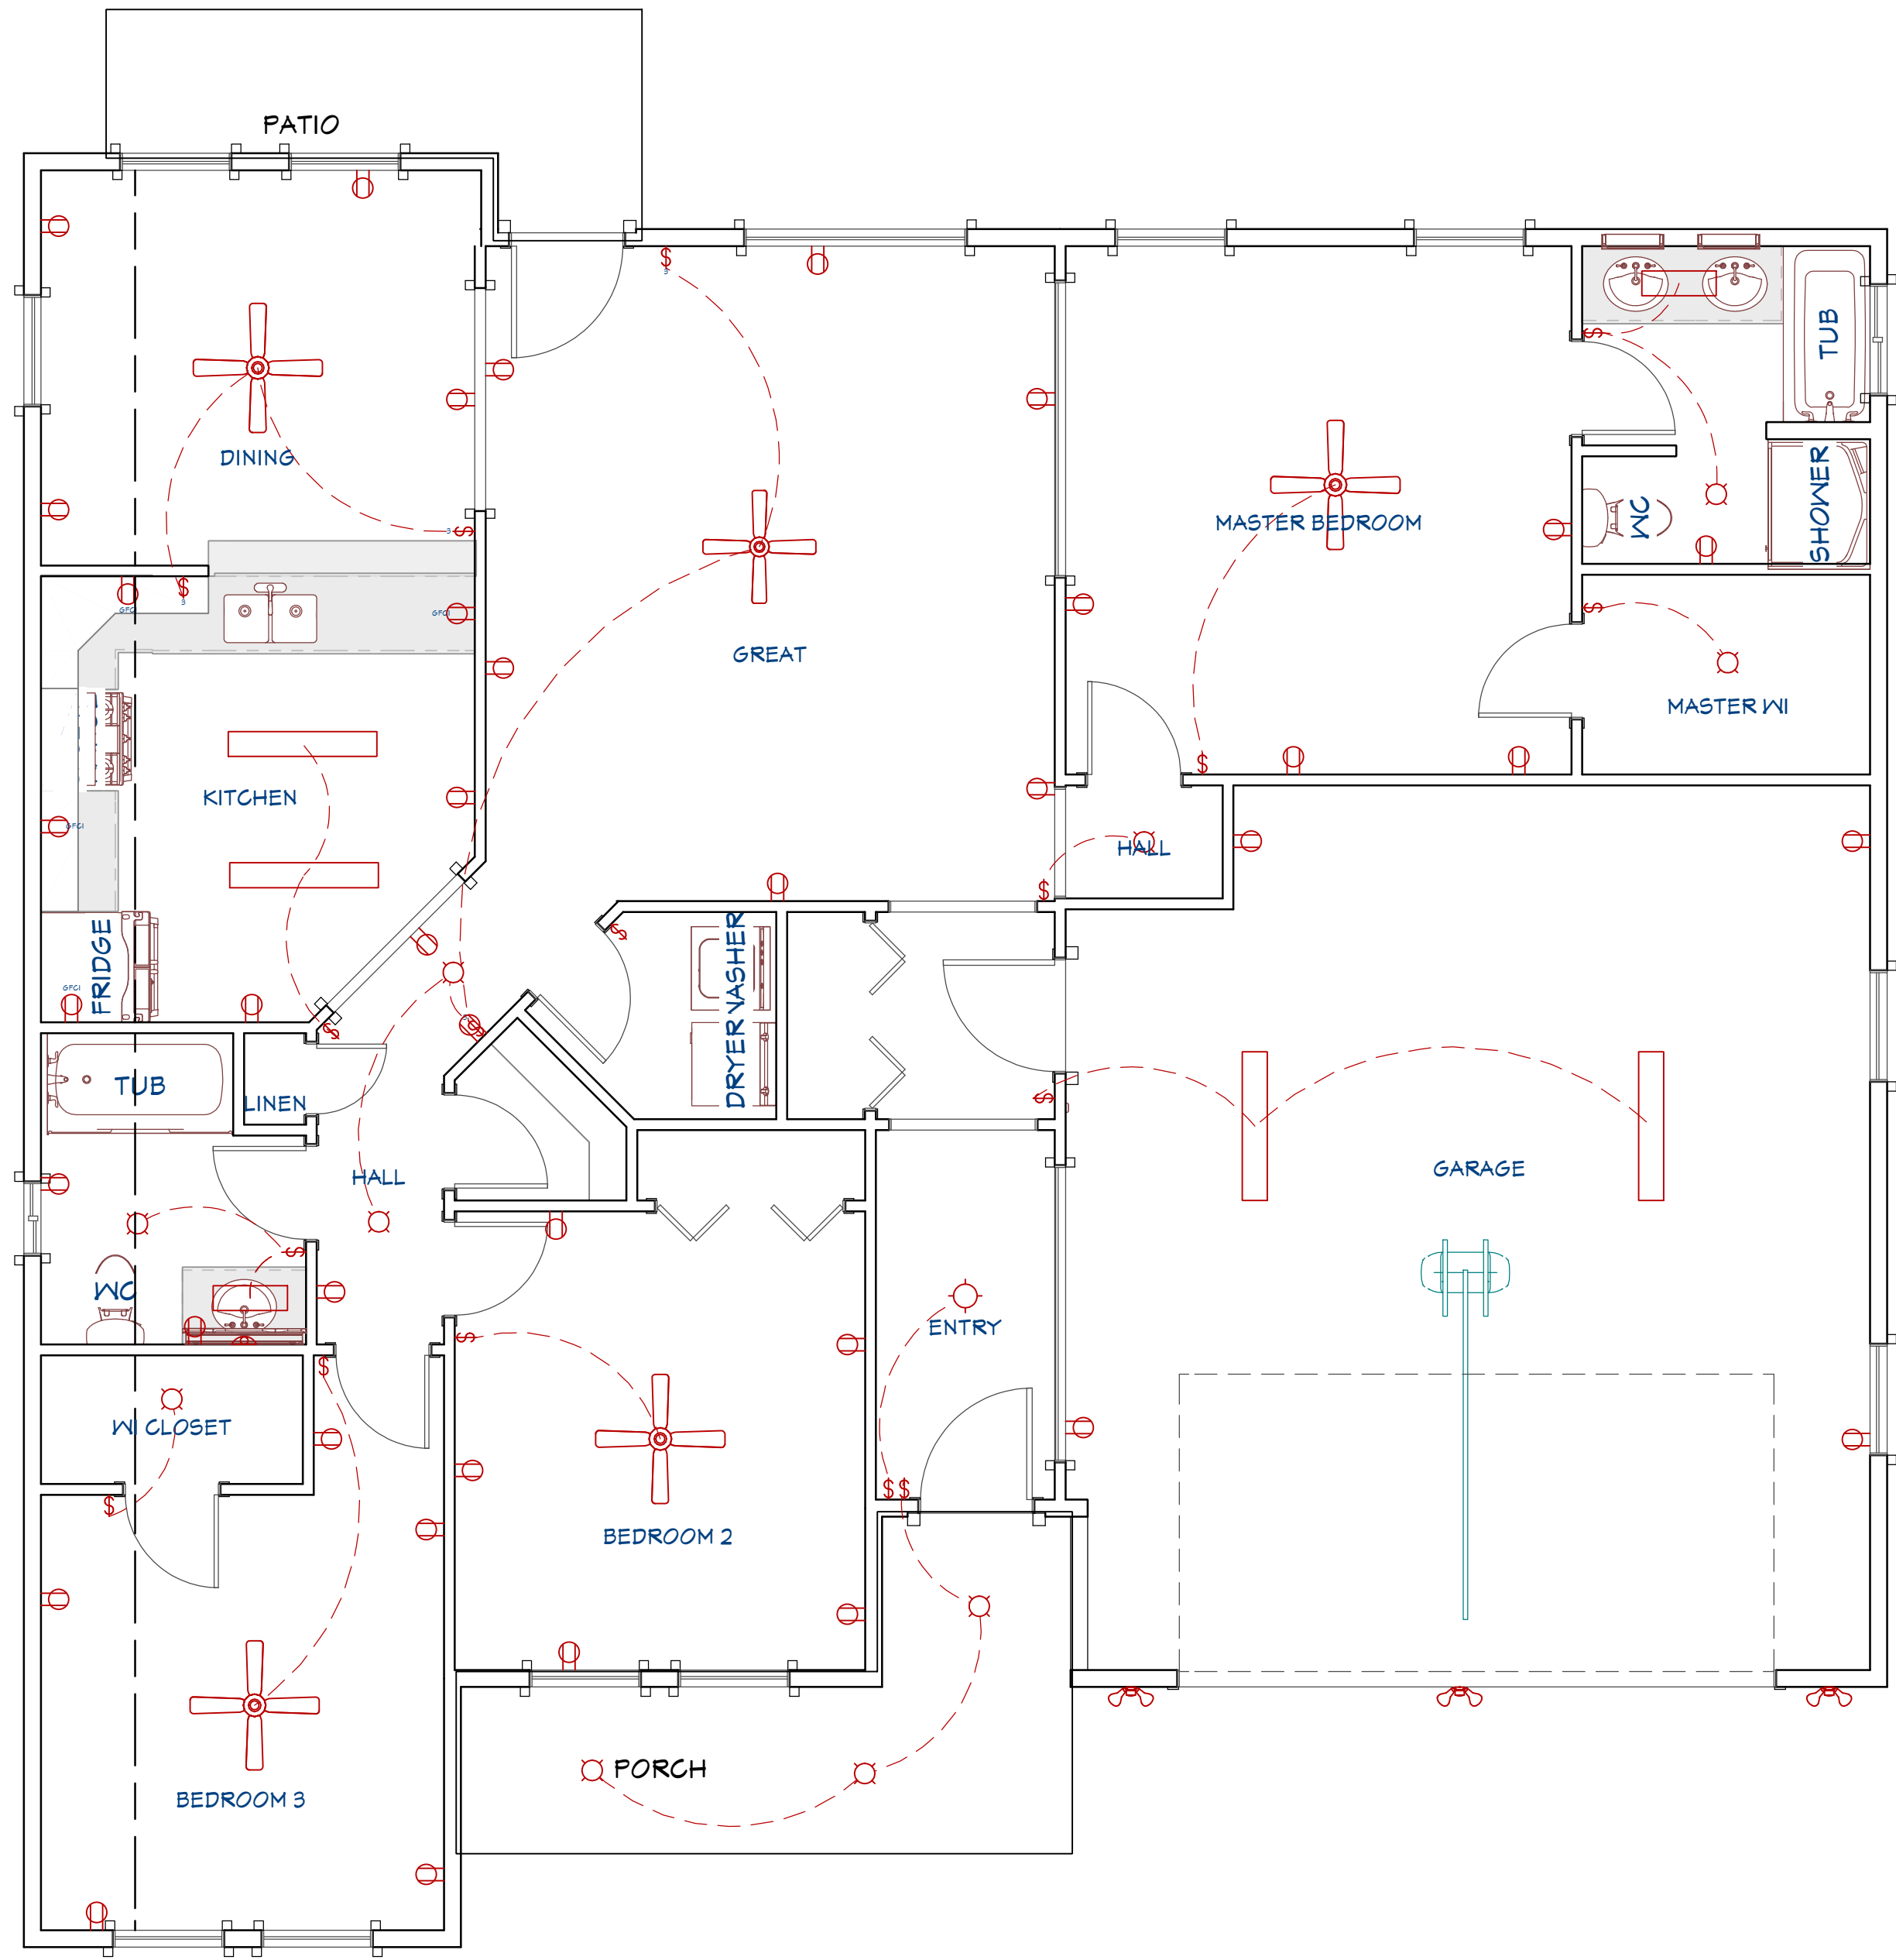

Electrical Plan View
Scale: 1/4"=1'-0"

ELECTRICAL SCHEDULE			
2D SYMBOL	QTY	LABEL	DIMENSIONS
⚡	4	3-WAY SWITCH	3X3/4X5"
⌚	36	DUPLEX	3X5/16X5"
⌚	4	GFCI	3X5/16X5"
⬡	10	GLOBE	6X6X1 11/16"
⊕	4	GLOBE LIGHT CEILING FAN	41 11/16X41 11/16X11 1/2
⌚	1	GRAN TENOS	7 3/4X6 1/4X13"
▭	4	MEDIUM SURFACE MOUNTED TUBE LIGHT (48X48D)	48X9X3"
▭	2	SHORT SURFACE MOUNTED TUBE LIGHT (24X48D)	24X9X3"
⚡	13	SINGLE POLE SWITCH	3X3/4X5"
🔦	3	SPOTLIGHT 2 MOTION SENSOR	14 7/16X6 3/16X1 1/4
⬠	1	MAJORCA PENDANT	13 11/16X13 11/16X1 1/4



REVISION TABLE		DESCRIPTION
NUMBER	DATE	



Electrical Plan View

DRAWINGS PROVIDED BY:
TDS

DATE:



7/6/2025

SCALE:

as shown

SHEET:

P-5

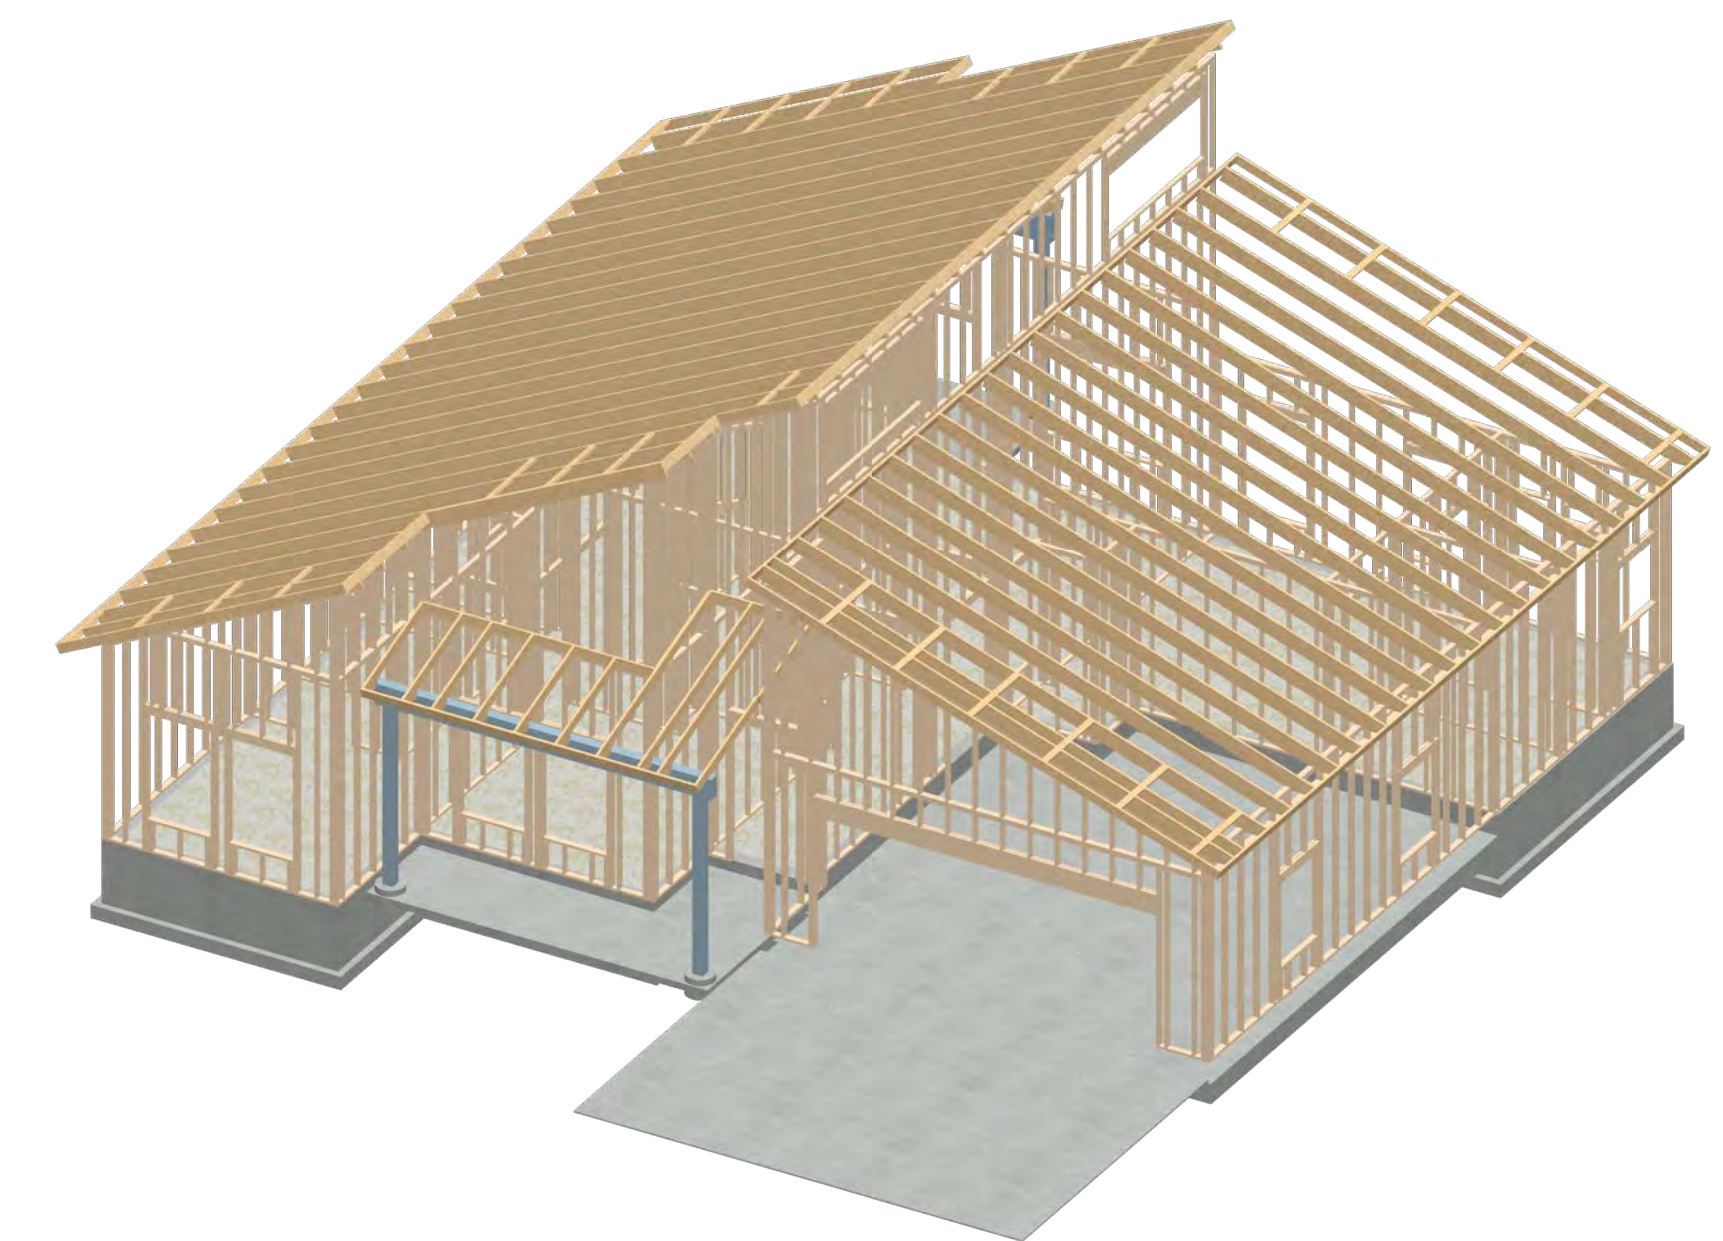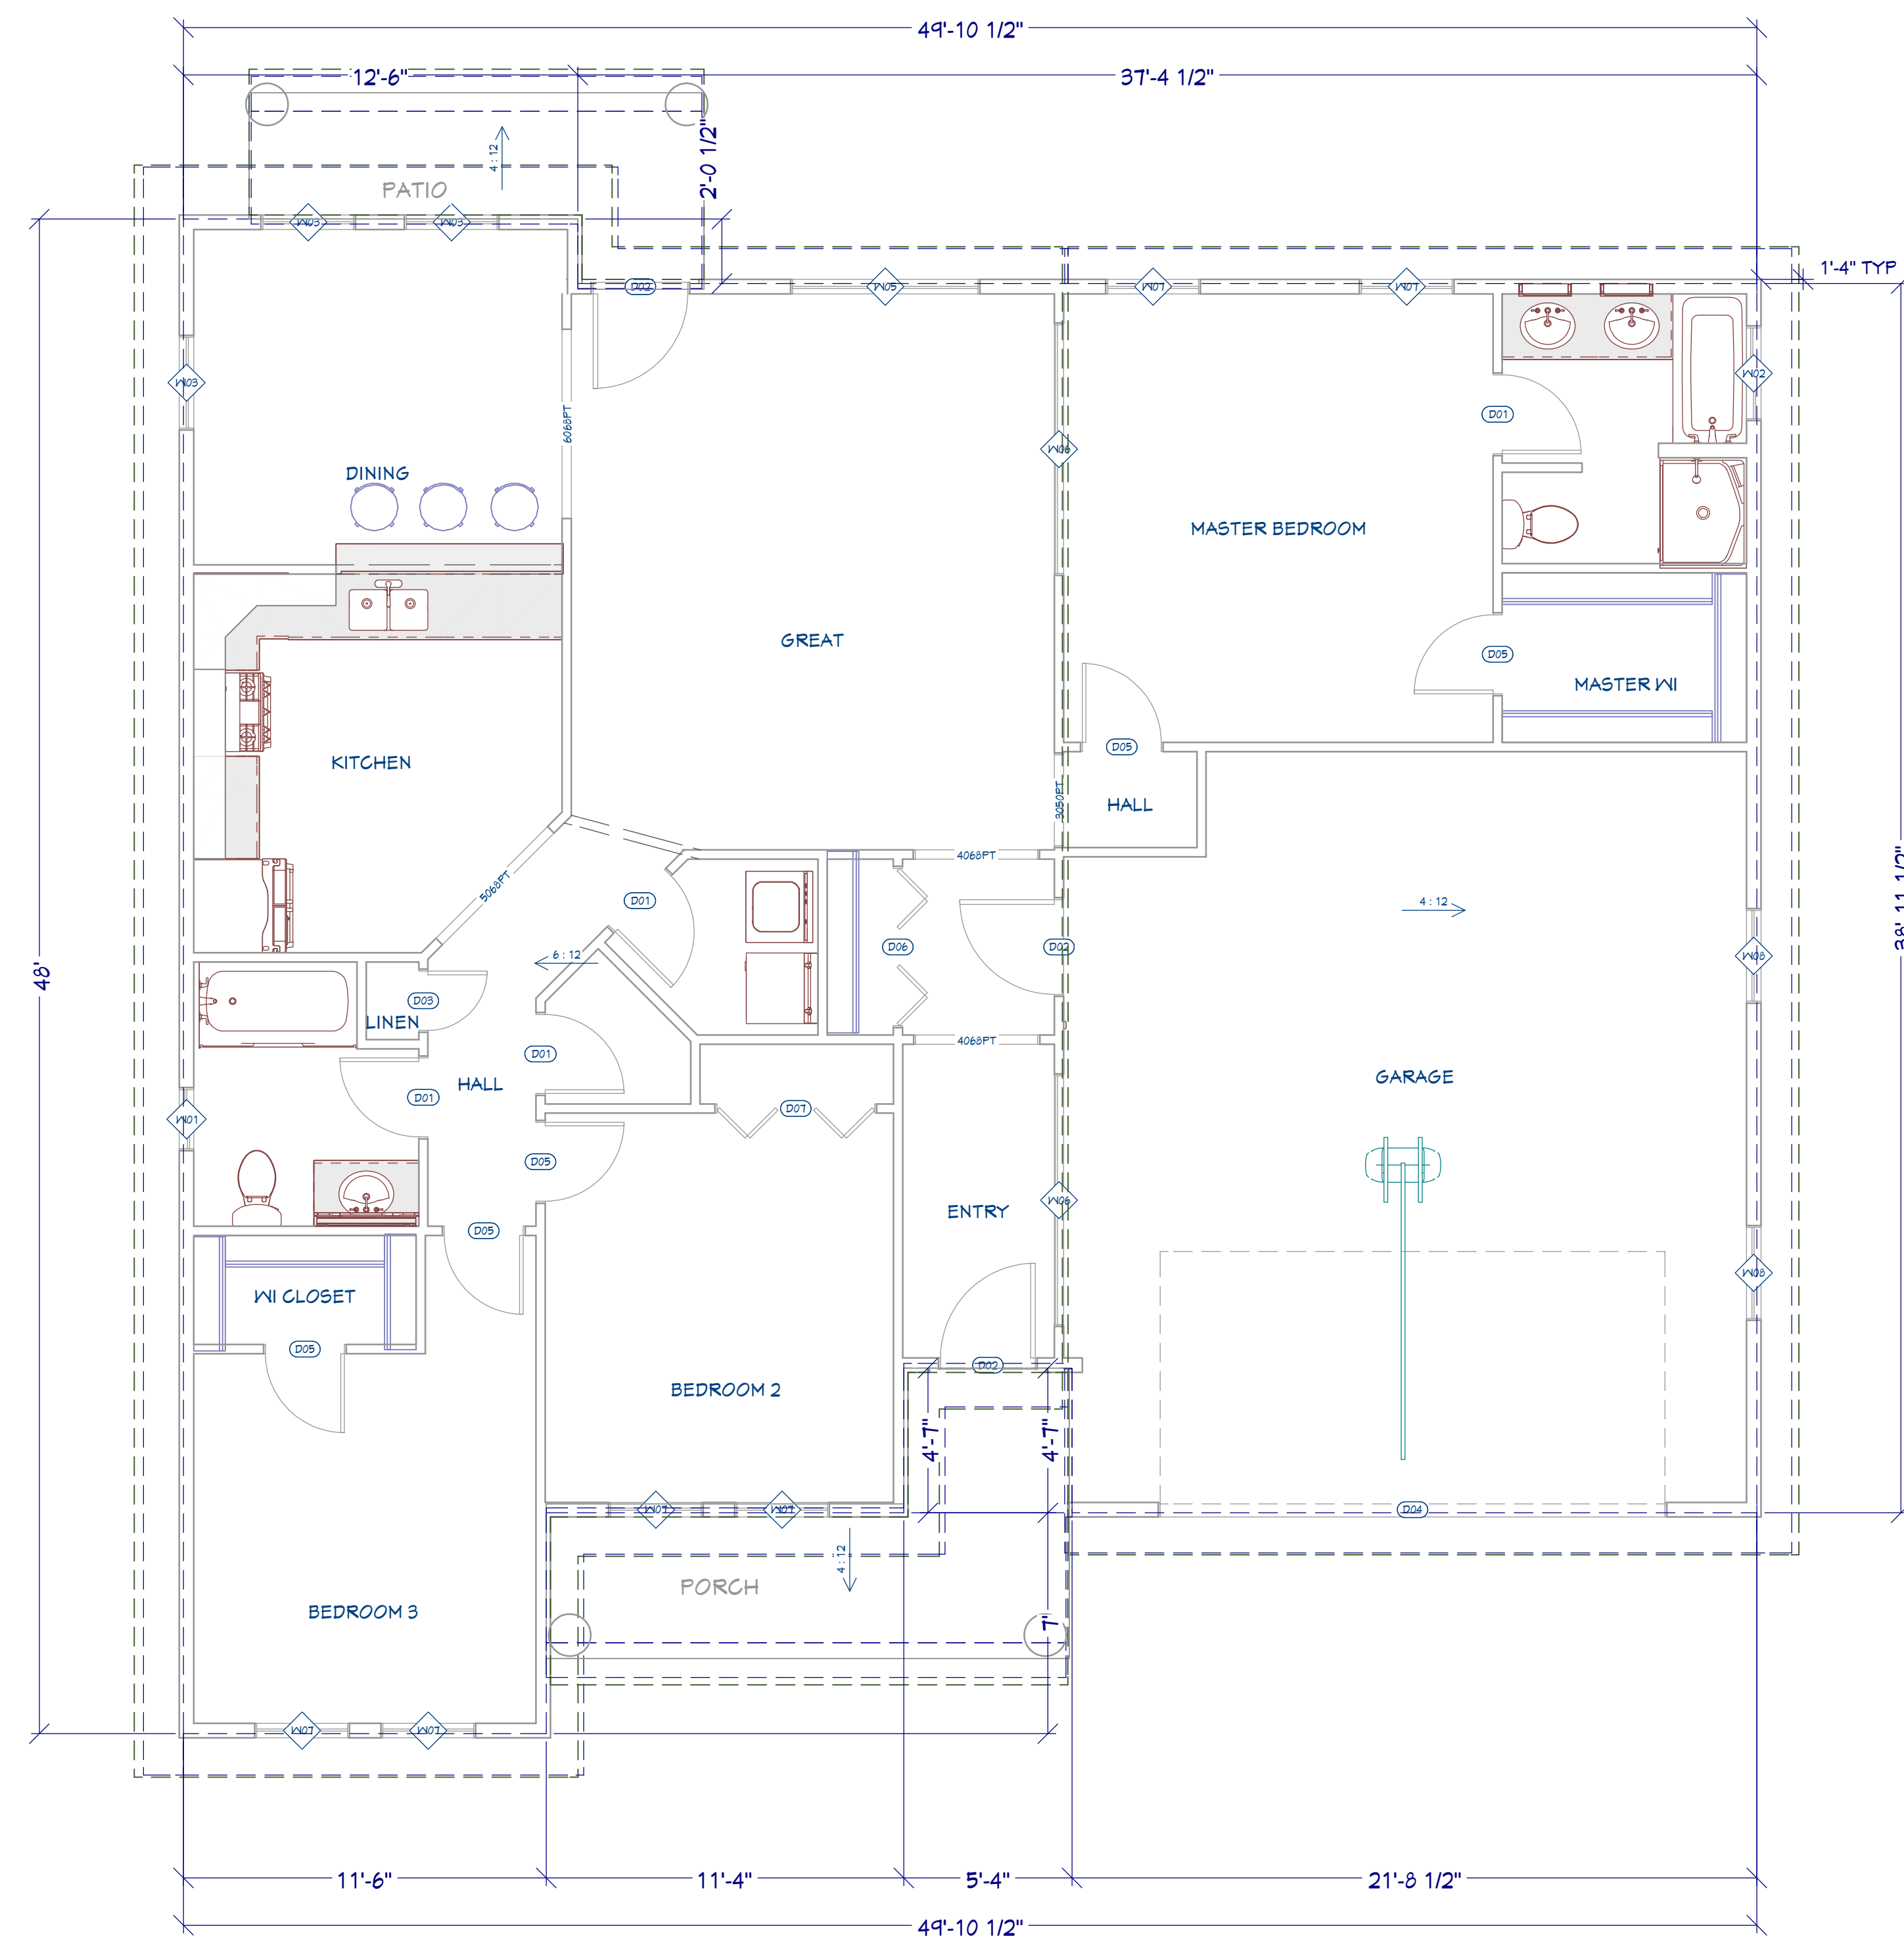

Roof Plan View
Scale: 1/4"=1'-0"

Scale: 1/4"=1'-0"

[illegible]

Root Plan View

TDS

1

DATE:

/6/2025

SCALE:

as shown

SHEET:

5-6



Kitchen View



Master Bath View



Garage View



Entry View

REVISION TABLE		REVISION	DATE	DESCRIPTION
1				
2				
3				
4				
5				
6				
7				
8				
9				
10				

Interior Views

DRAWINGS PROVIDED BY:
TDS

DATE:

7/6/2025

SCALE:

as shown

SHEET:

P-7