



The David Home Rendering
Scale None
2790 Sq. Ft.

REVISION TABLE	
NUMBER	DATE

Project Overview

DRAWINGS PROVIDED BY:
Bill Cullum

DATE:

4/25/2025


SCALE:

as shown

SHEET:

P-1

Sample

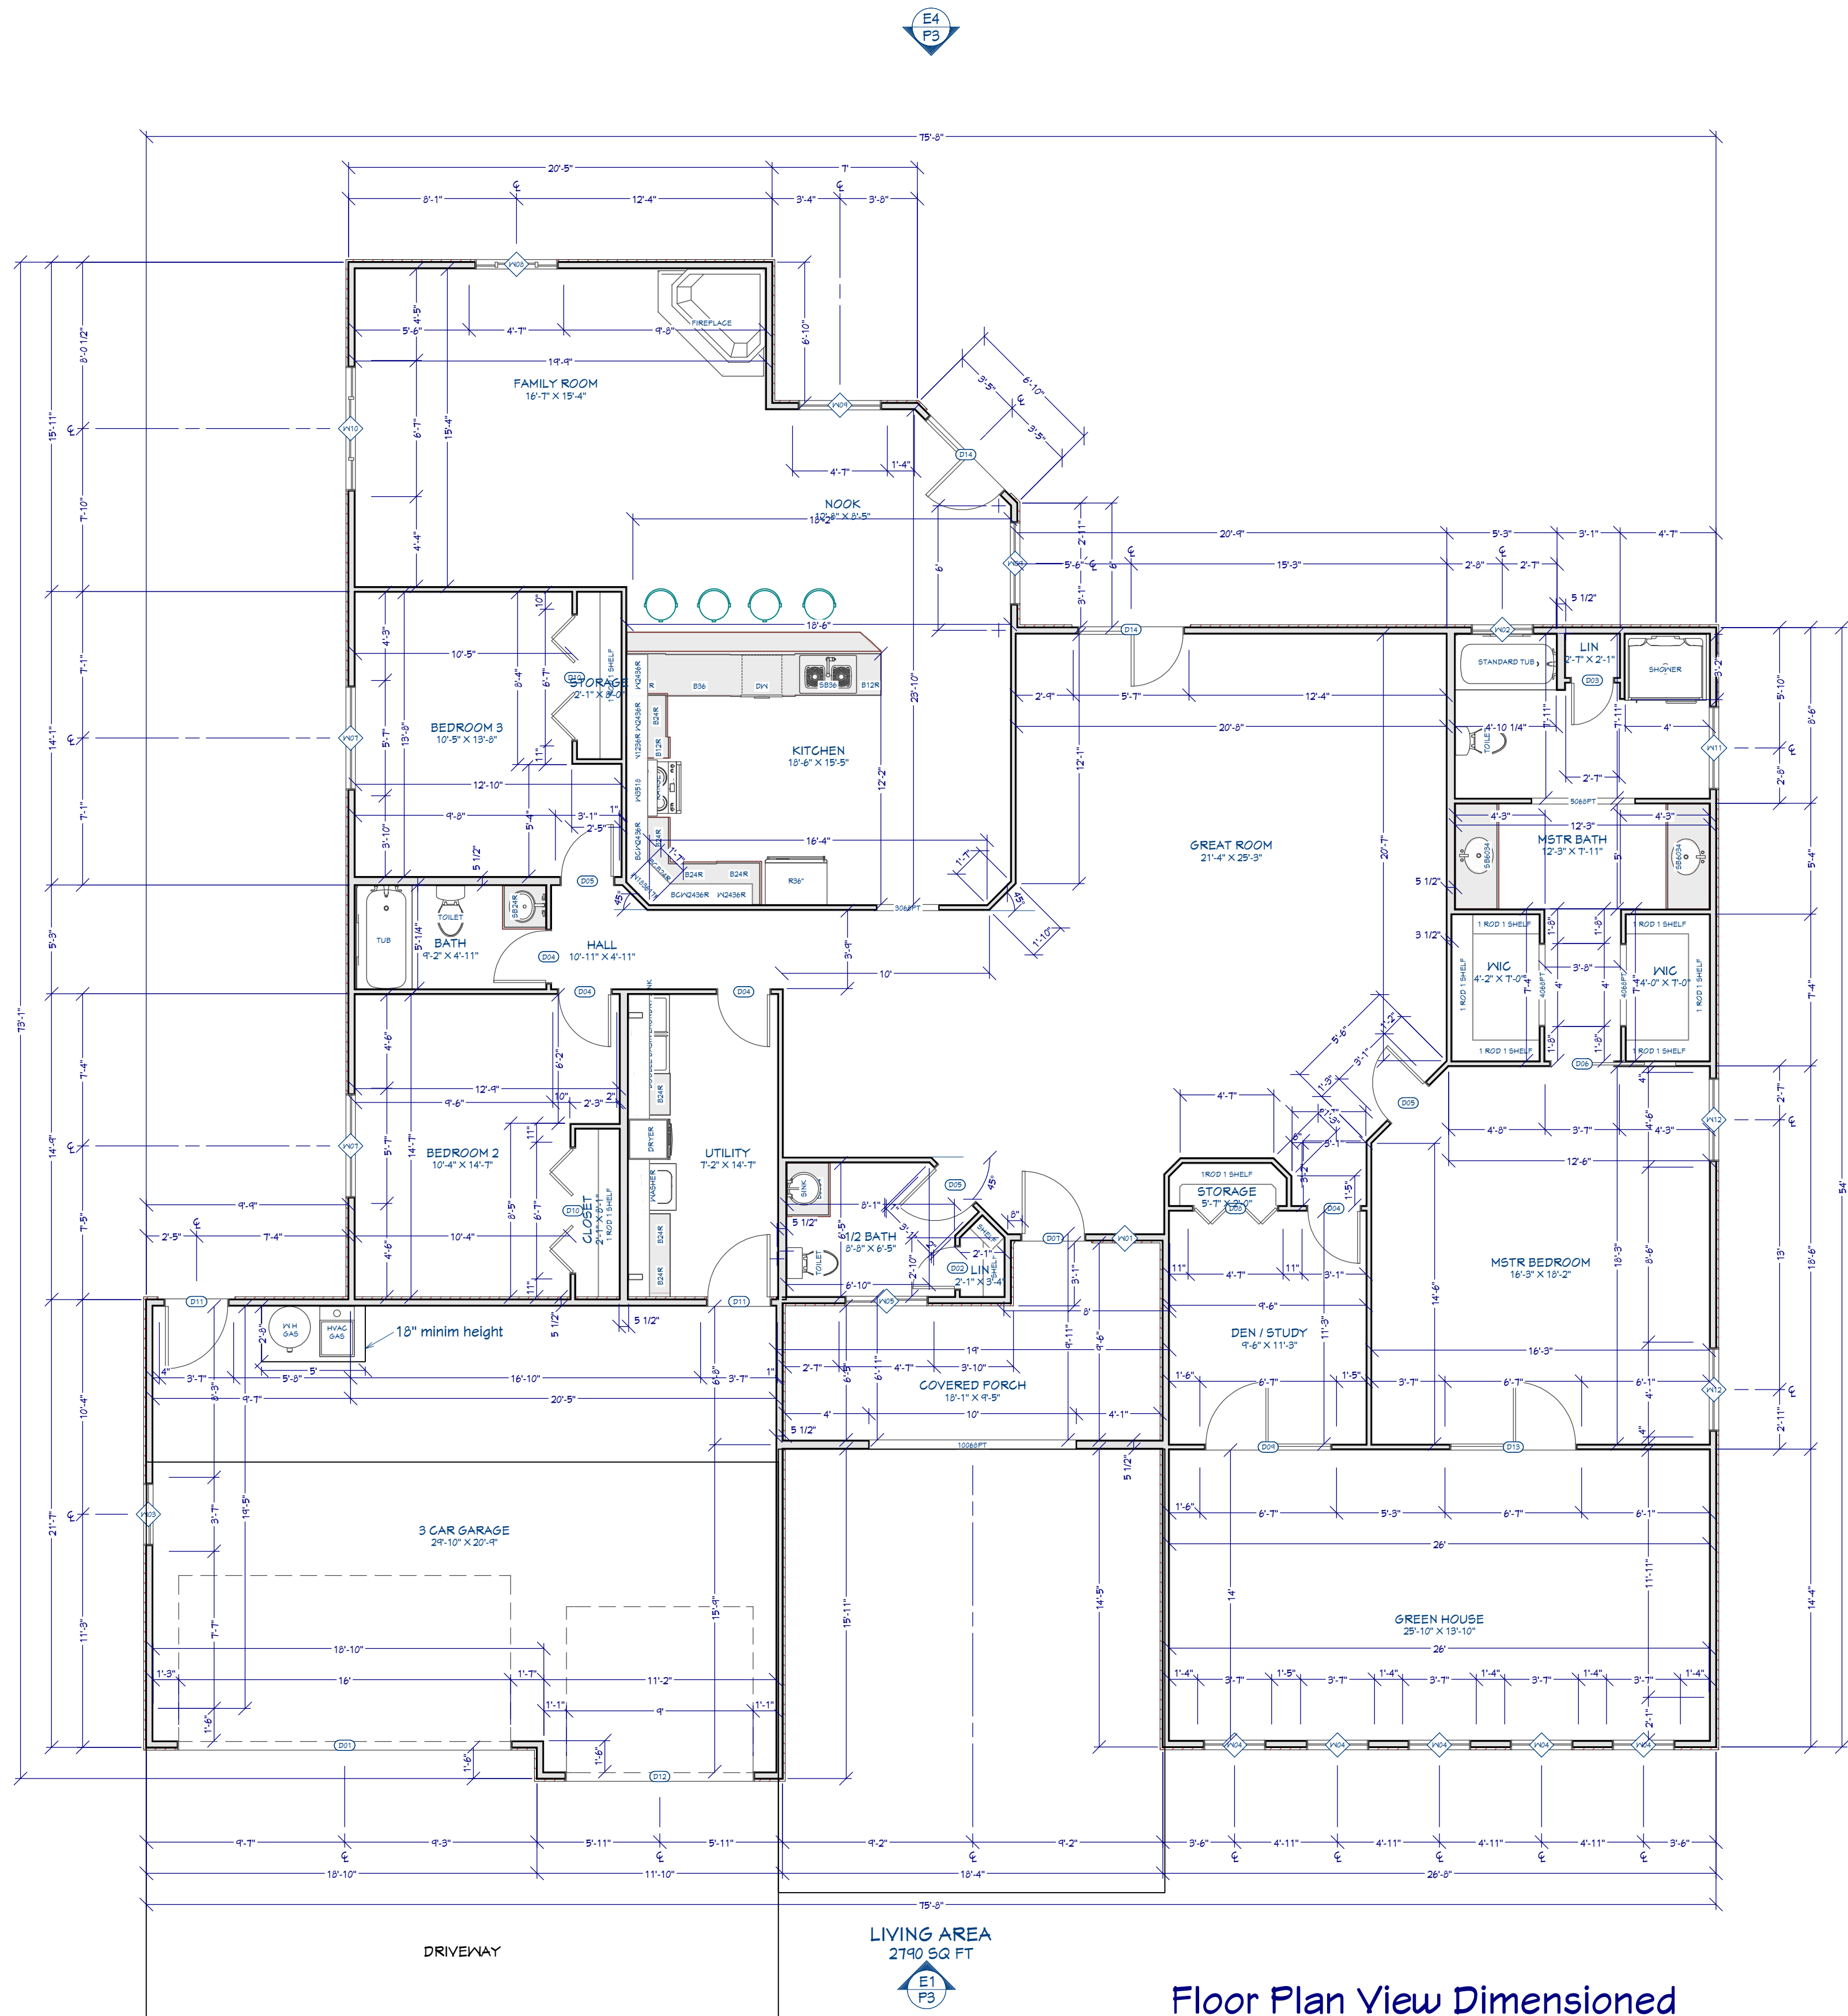

Floor Plan View Dimensioned
3/16"= 1 ' 0 "

DOOR SCHEDULE							
NUMBER	LABEL	QTY	FLOOR	SIZE	R/O	DESCRIPTION	HEADER
D01	16080	1	1	16080	134"x44"	GARAGE-ERP STOCKTON II 8'	2X12X200' (2)
D02	2068	1	1	2068	L IN	28"x82 1/2"	HINGED-PANEL
D03	2068	1	1	2068	R IN	28"x82 1/2"	HINGED-PANEL
D04	2668	4	1	2668	L IN	32"x82 1/2"	HINGED-PANEL
D05	2668	3	1	2668	R IN	32"x82 1/2"	HINGED-PANEL
D06	3068	1	1	3068	R	13 1/4"x82 1/2"	POCKET DOOR R04
D07	3068	1	1	3068	L EX	32"x88"	EXT. HINGED-DOOR E21
D08	4068	1	1	4068	L/R	50"x82 1/2"	4 DR. BIFOLD-LOUVERED
D09	6068	1	1	6068	C-R IN	14"x82 1/2"	DOUBLE HINGED- 811 TRADITIONAL SASH
D10	6068	2	1	6068	L/R	14"x82 1/2"	4 DR. BIFOLD-LOUVERED
D11	3068	2	1	3068	R EX	32"x88"	EXT. HINGED-DOOR E21
D12	4080	1	1	4080		110"x44"	GARAGE-ERP STOCKTON II 8'
D13	6068	1	1	6068	C-L IN	14"x82 1/2"	DOUBLE HINGED- 811 TRADITIONAL SASH
D14	5068	2	1	5068	C-R EX	62"x88"	EXT. DOUBLE HINGED- 508 FRENCH

WINDOW SCHEDULE							
NUMBER	LABEL	QTY	SIZE	R/O	EGRESS	DESCRIPTION	HEADER
W01	1036FX	1	1036FX	13"x43"		FIXED GLASS-CT	2X8X16' (2)
W02	3016RS	1	3016RS	31"x14"		RIGHT SLIDING	2X6X40' (2)
W03	3020RS	1	3020RS	31"x25"		RIGHT SLIDING	2X6X40' (2)
W04	3040FH	5	3040FH	31"x44"		DOUBLE HOPPER-T/B-CT	2X6X40' (2)
W05	4030RS	1	4030RS	44"x37"		RIGHT SLIDING	2X8X52' (2)
W07	5050SH	2	5050SH	61"x61"	YES	SINGLE HUNG	2X8X64' (2)
W08	4050TS	1	4050TS	44"x61"		TRIPLE SLIDING	2X8X52' (2)
W09	4050DH	2	4050DH	44"x61"	YES	DOUBLE HUNG	2X8X52' (2)
W10	6050TS	1	6050TS	73"x61"		TRIPLE SLIDING	2X10X76' (2)
W11	GLASS BLOCKS	1	4050FX	44"x61"		FIXED GLASS	2X8X52' (2)
W12	4050SH	2	4050SH	44"x61"	YES	SINGLE HUNG	2X8X52' (2)

Note:
Interior walls 5/12" Exterior walls 5 1/2"
Plumbing walls 5 1/2" as noted

REVISION TABLE		REVISION BY		DESCRIPTION	
NUMBER	DATE				

Floor Plan

DRAWINGS PROVIDED BY:
Bill Cullum

DATE:
4/25/2025

SCALE:
as shown

SHEET:
P2



Exterior Elevation Front
3/16" = 1' 0"



Exterior Elevation Back
3/16" = 1' 0"



Exterior Elevation Left
3/16" = 1' 0"



Exterior Elevation Right
3/16" = 1' 0"

[illegible]

Elevations

DRAWINGS PROVIDED BY:

Bill Cullum

DATE:


4/25/2025

SCALE:
as shown


SHEET:
P3

Sample

as shown
SHEET:
P3

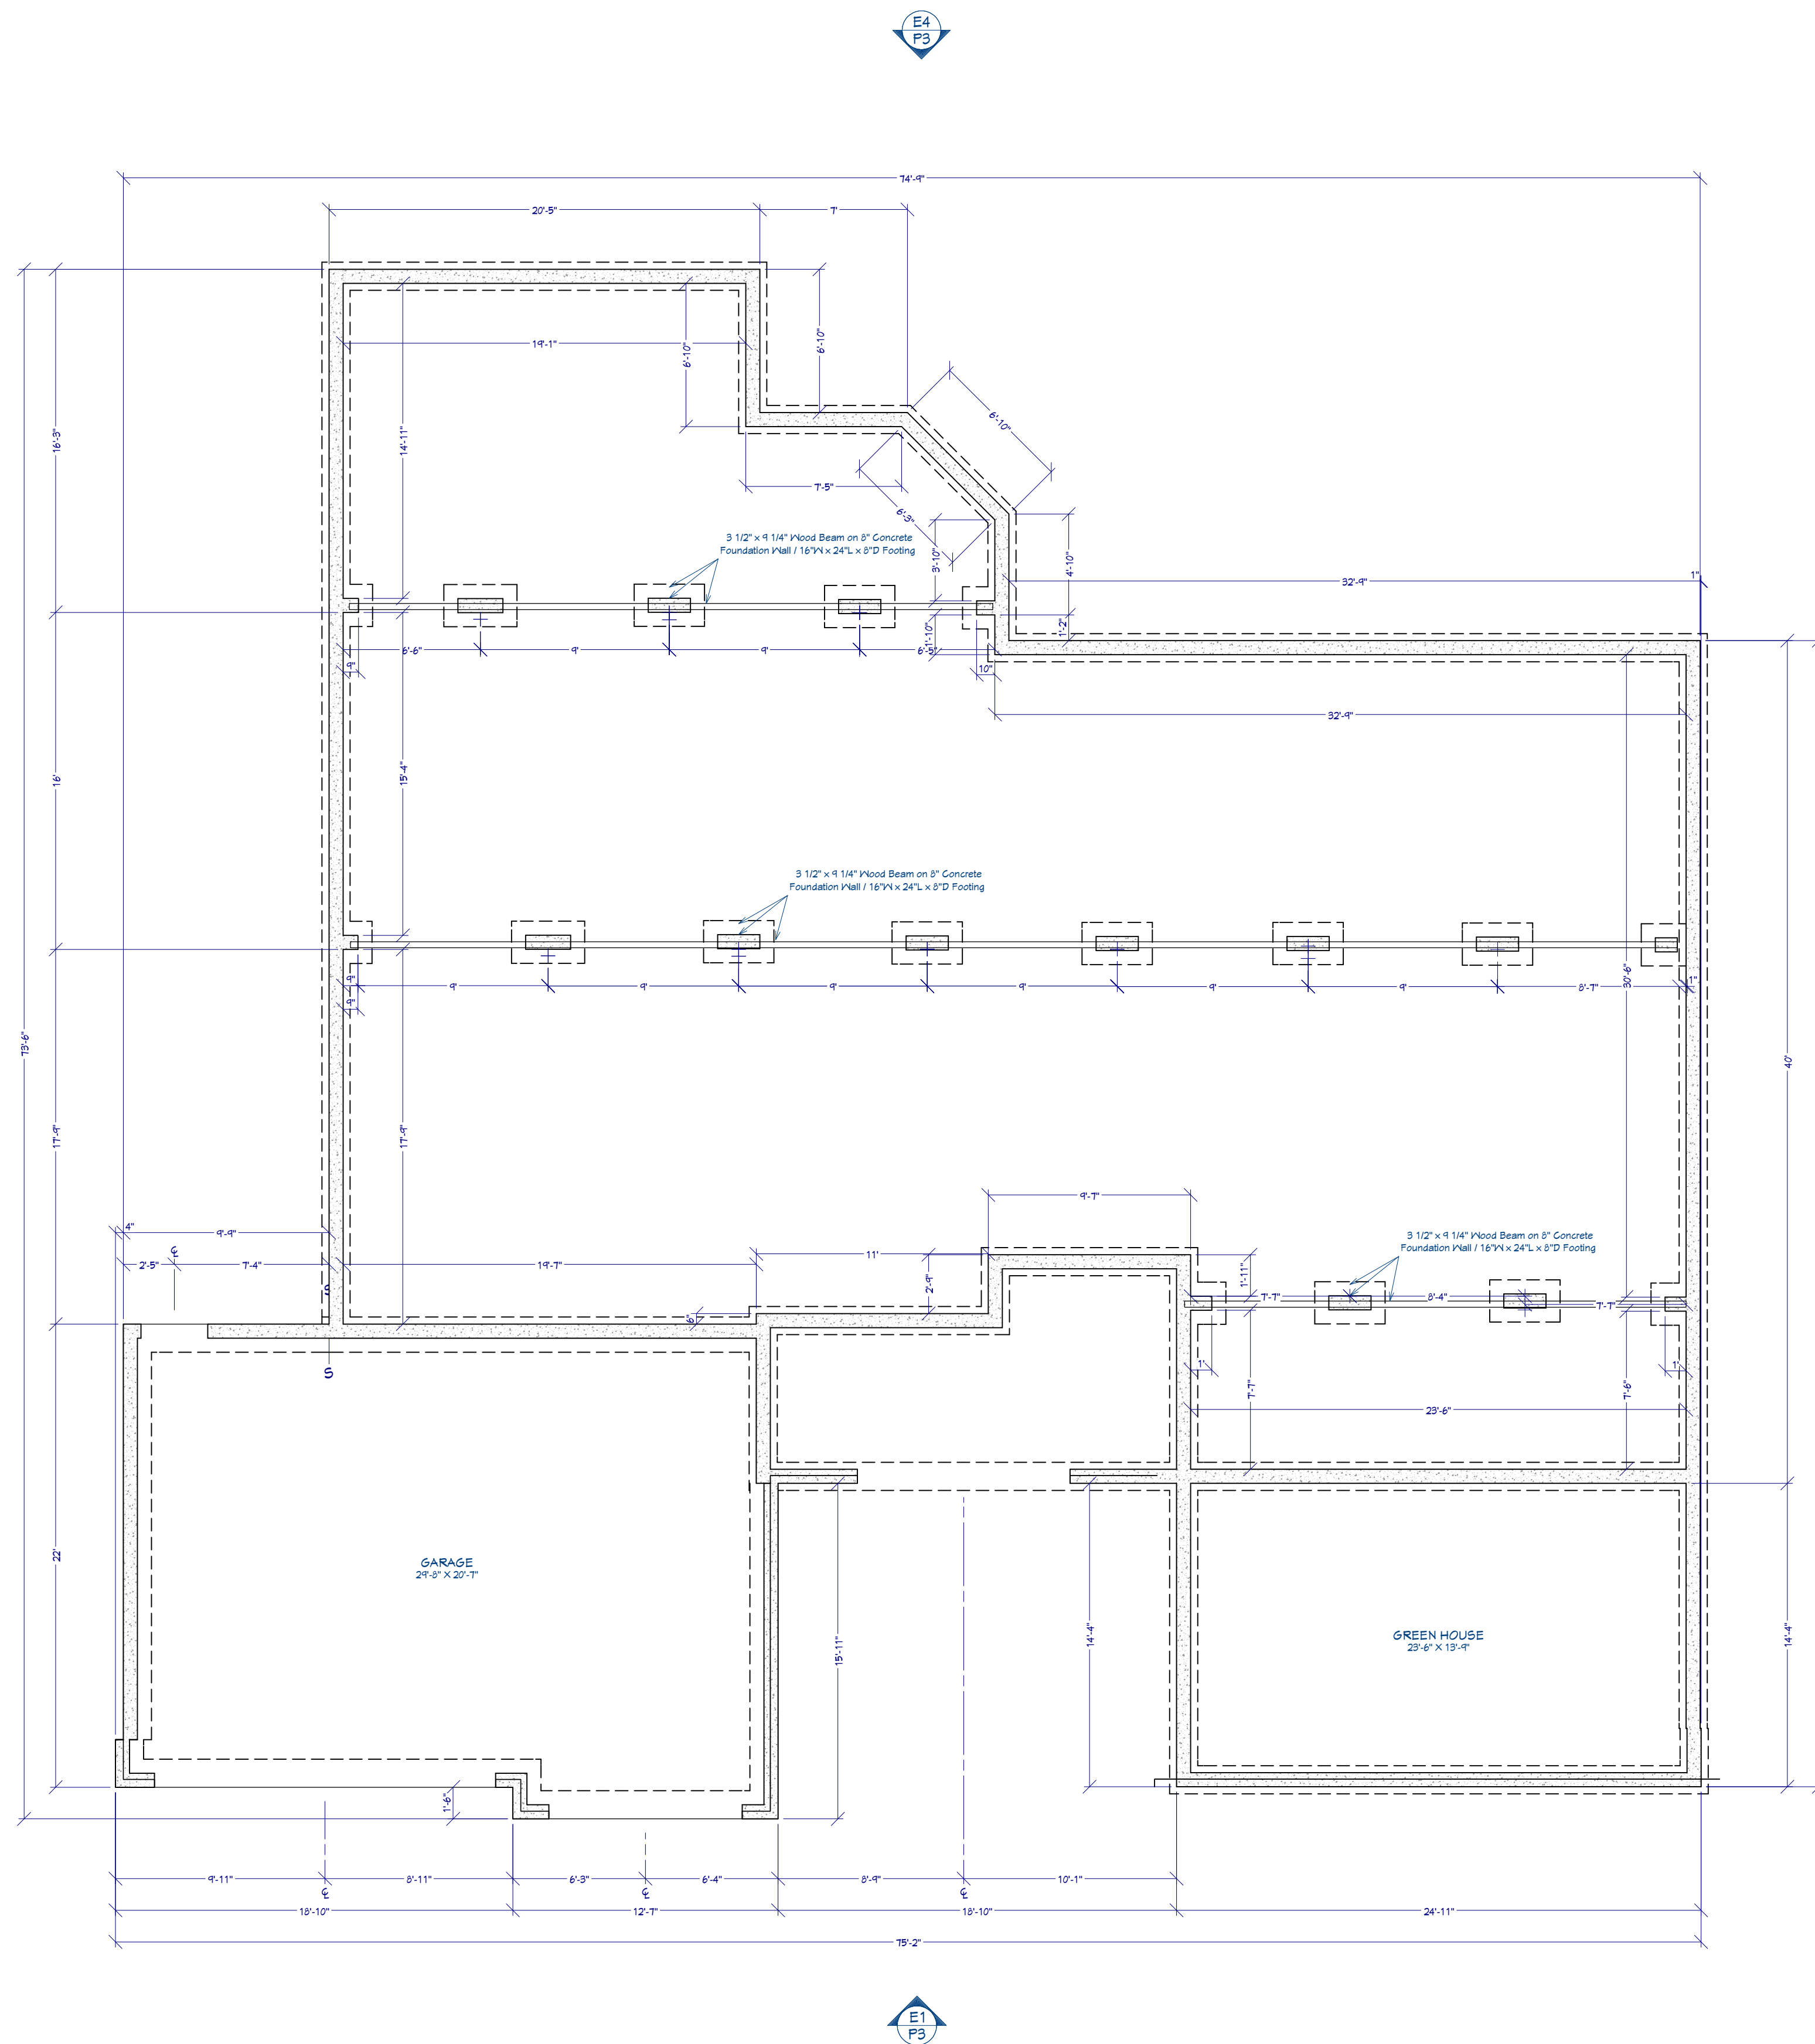


Foundation Plan
3/16" = 1'-0"

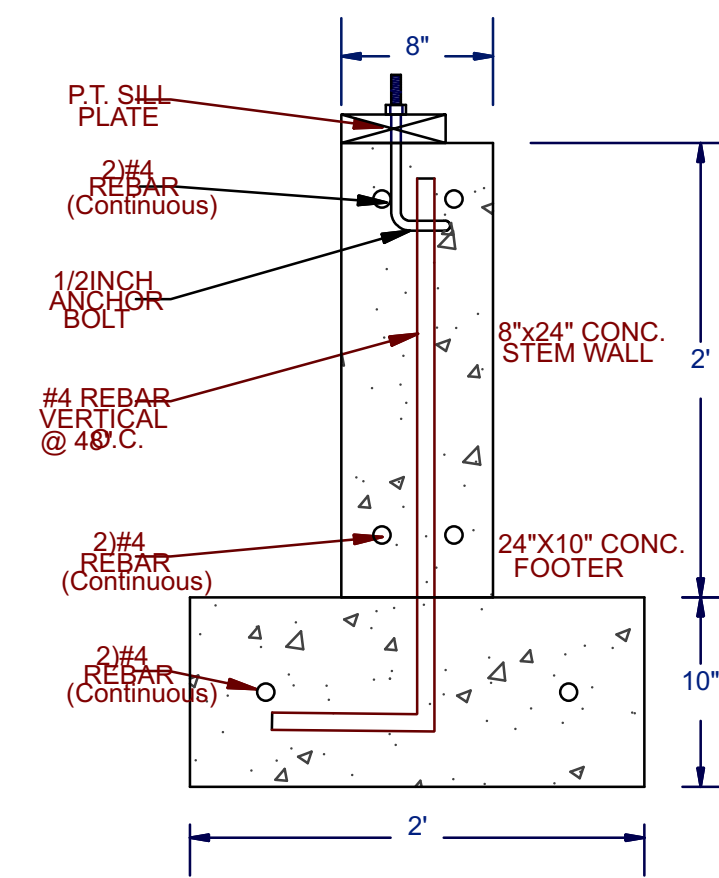

Typical Application around
Perimeter Stem Walls

NOTE:
ALL REBAR PER LOCAL CODE
AND /OR ENGINEER'S DESIGN

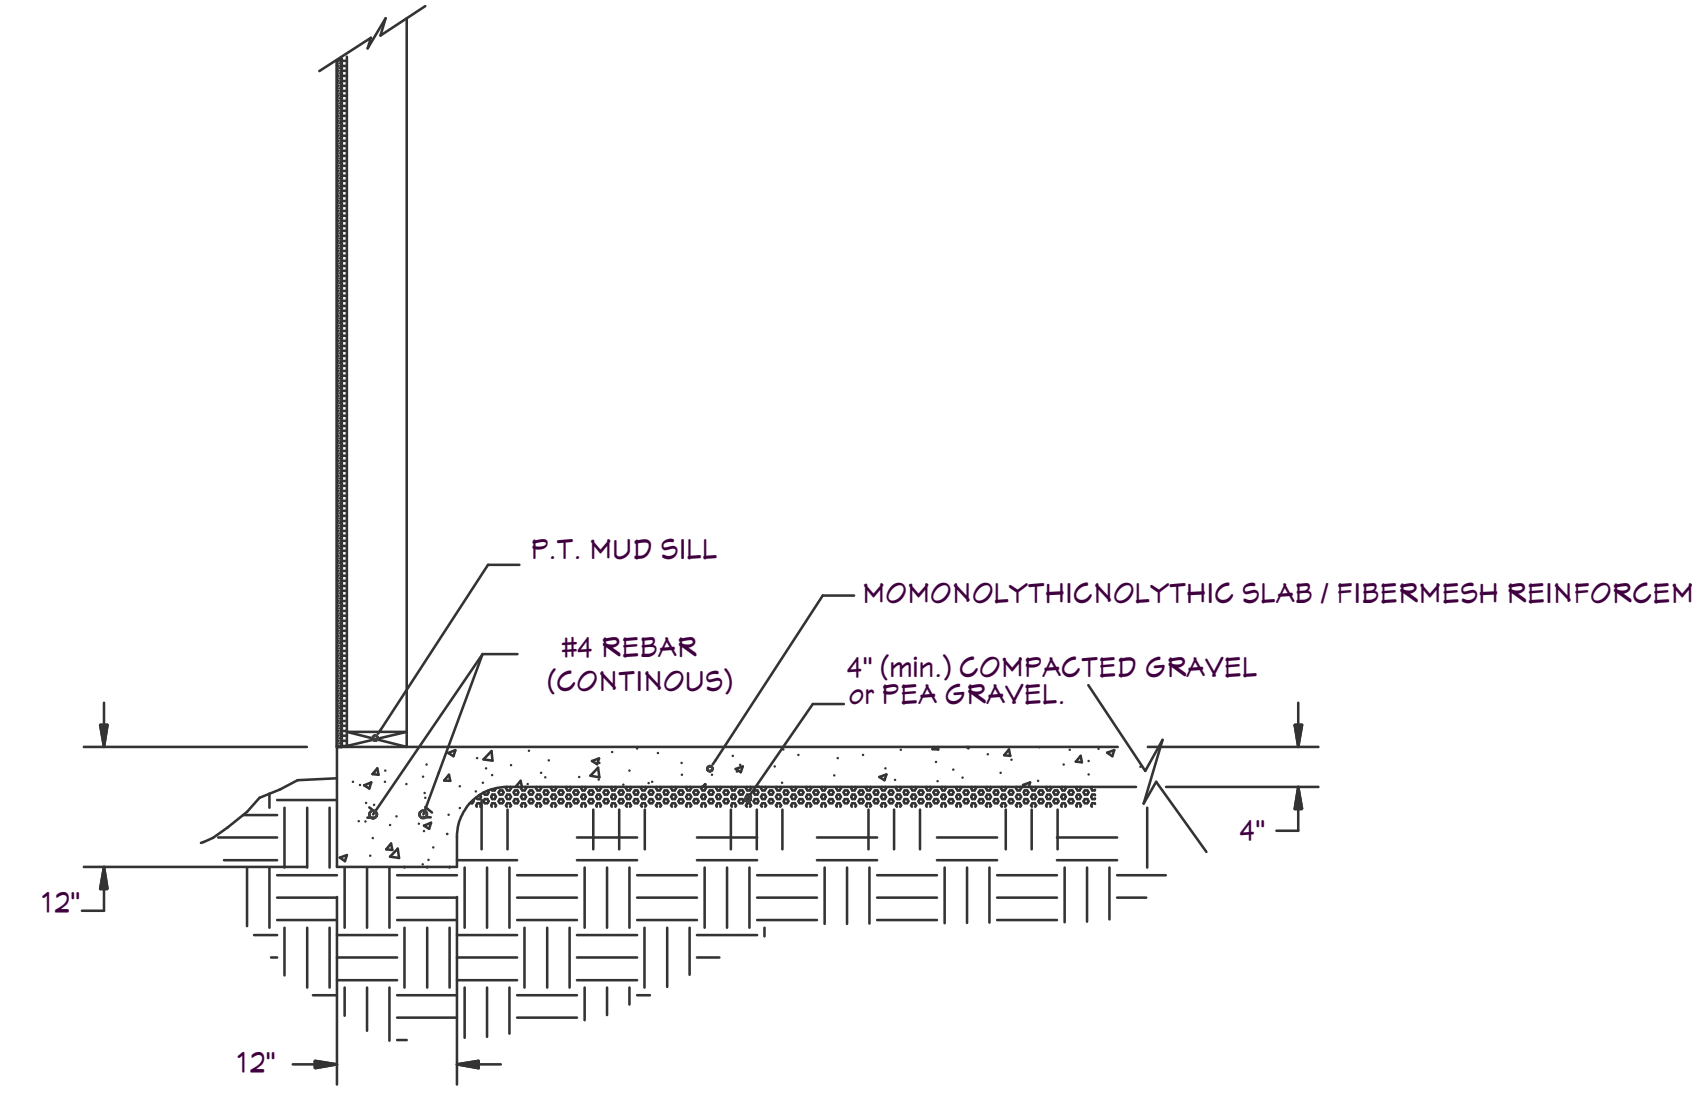

Garage Floor
& Green House
Section

NOTE:
ALL REBAR PER LOCAL CODE

Foundation

REVISION TABLE		REVISION BY		DESCRIPTION	
NUMBER	DATE				

Foundation Plan

DRAWINGS PROVIDED BY:
Bill Cullum

DATE:


4/25/2025


SCALE:

as shown

SHEET:

P4

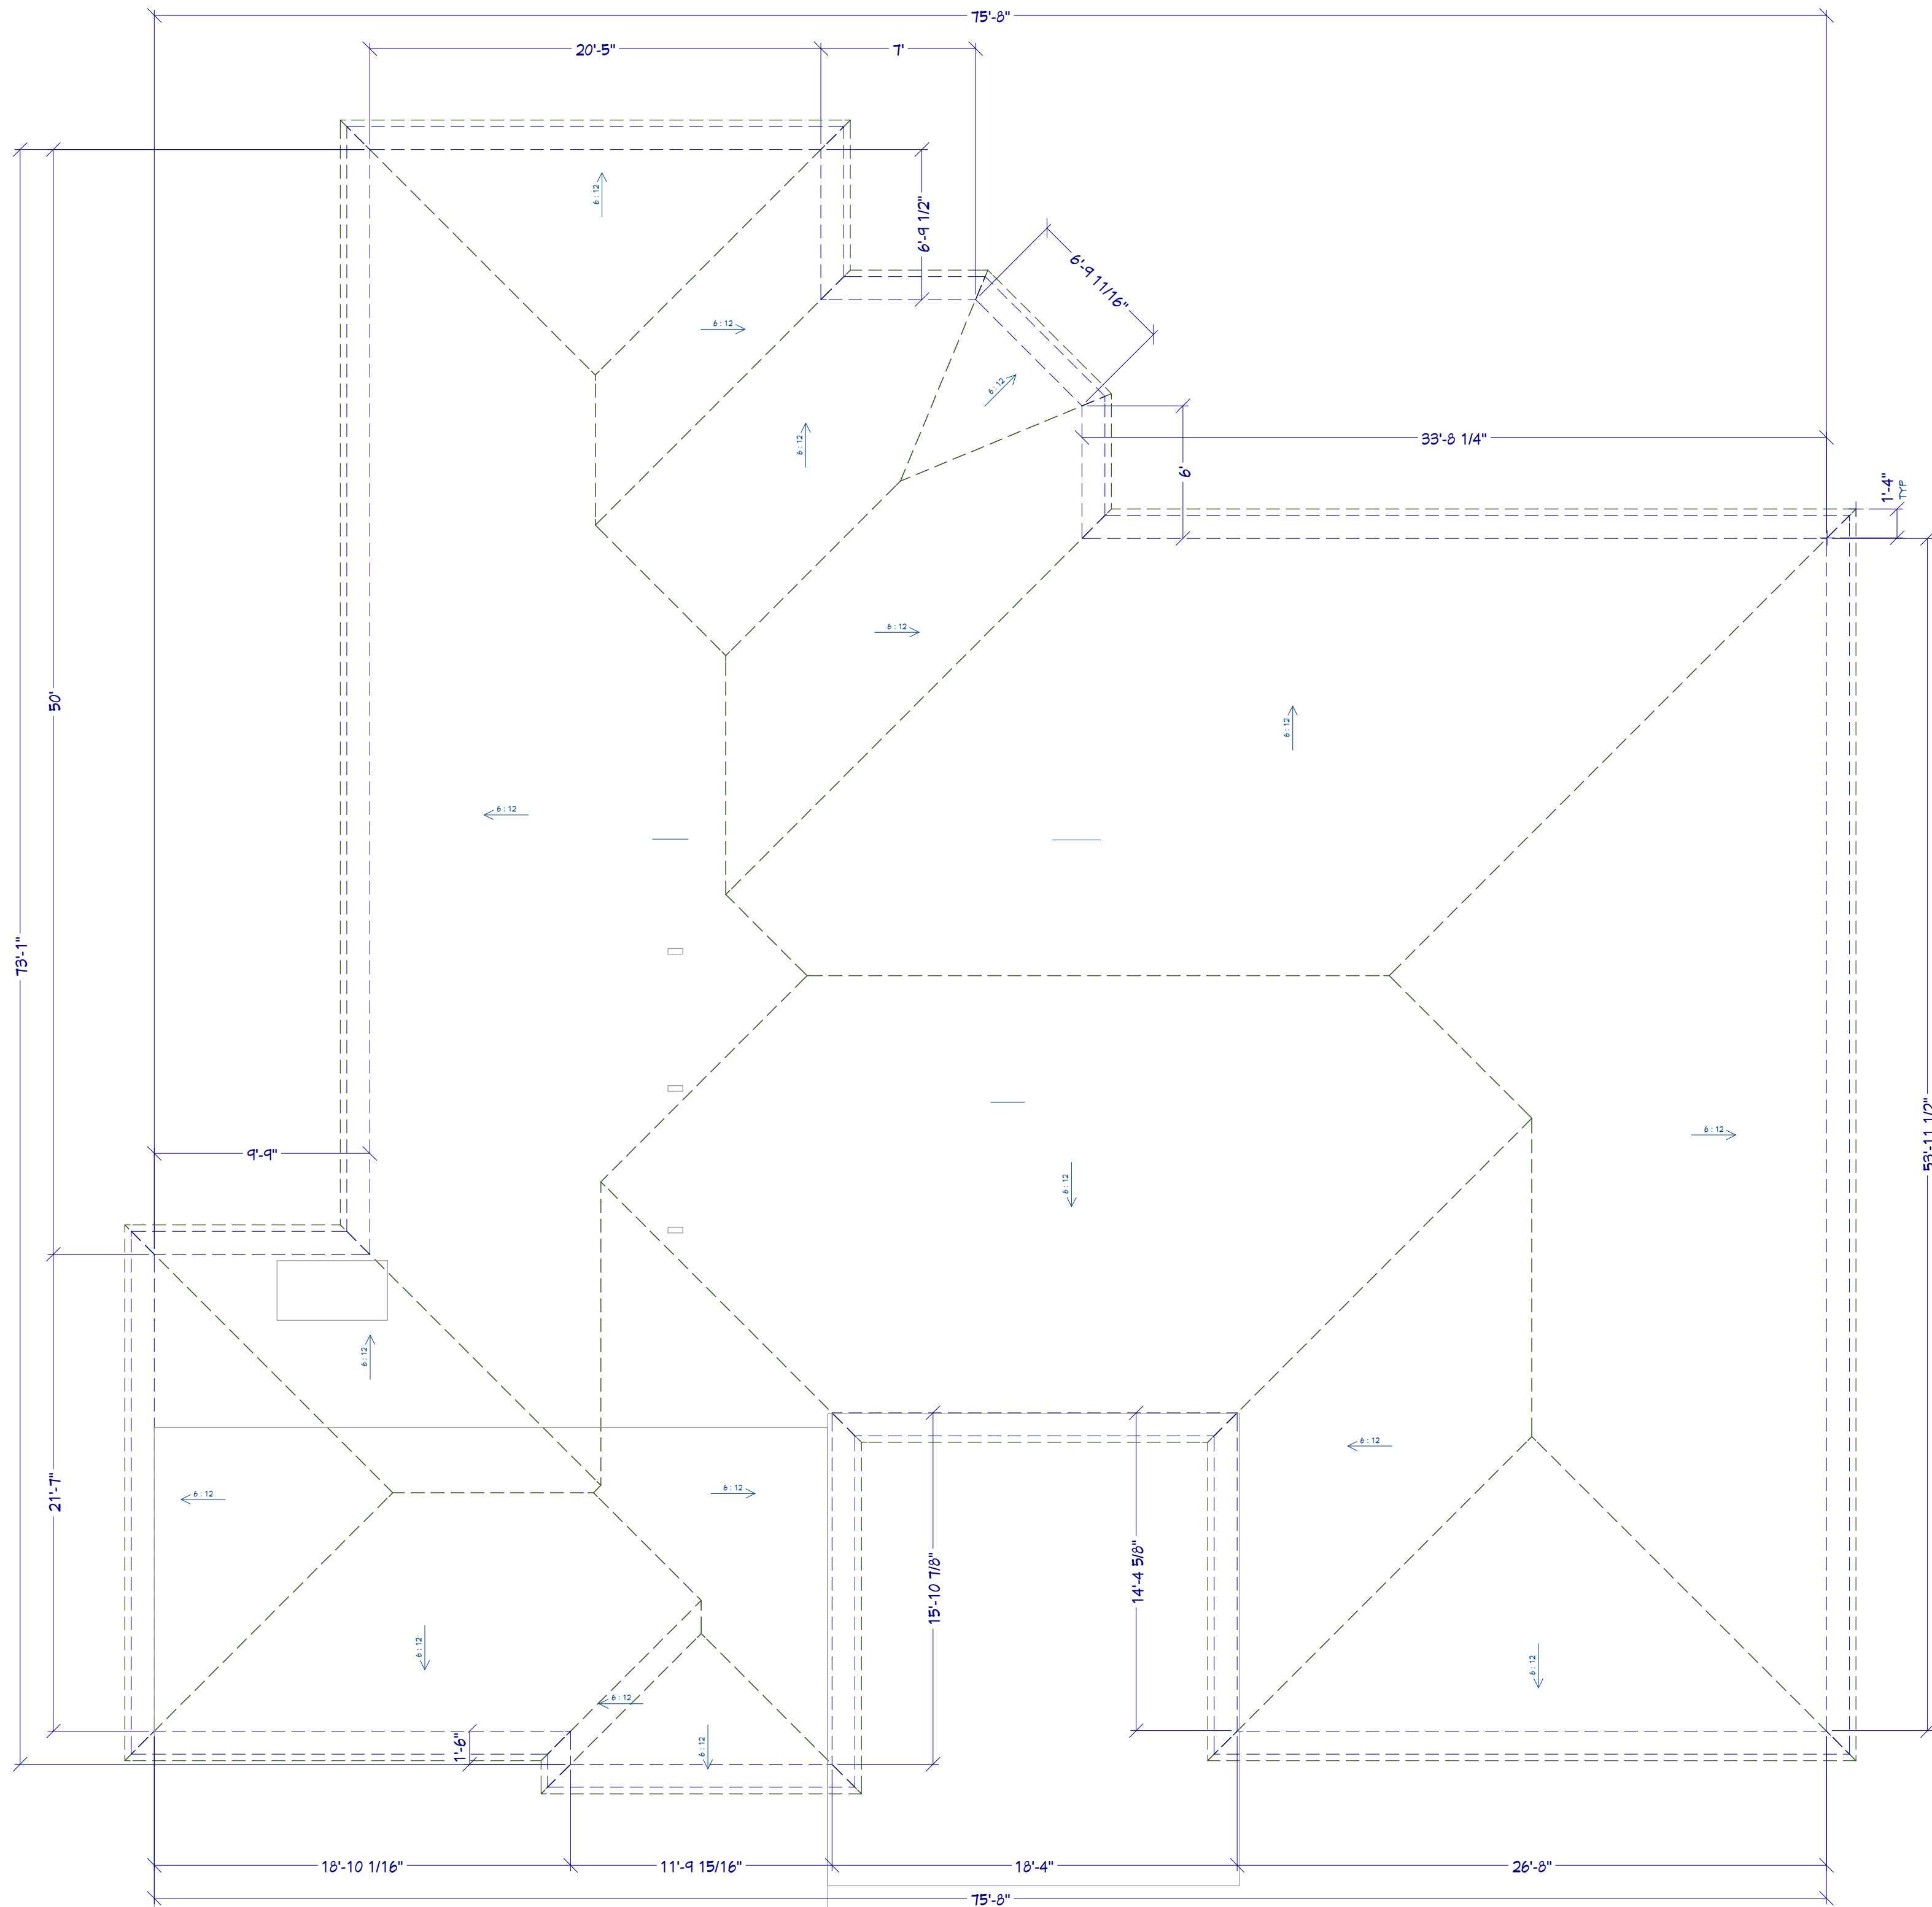

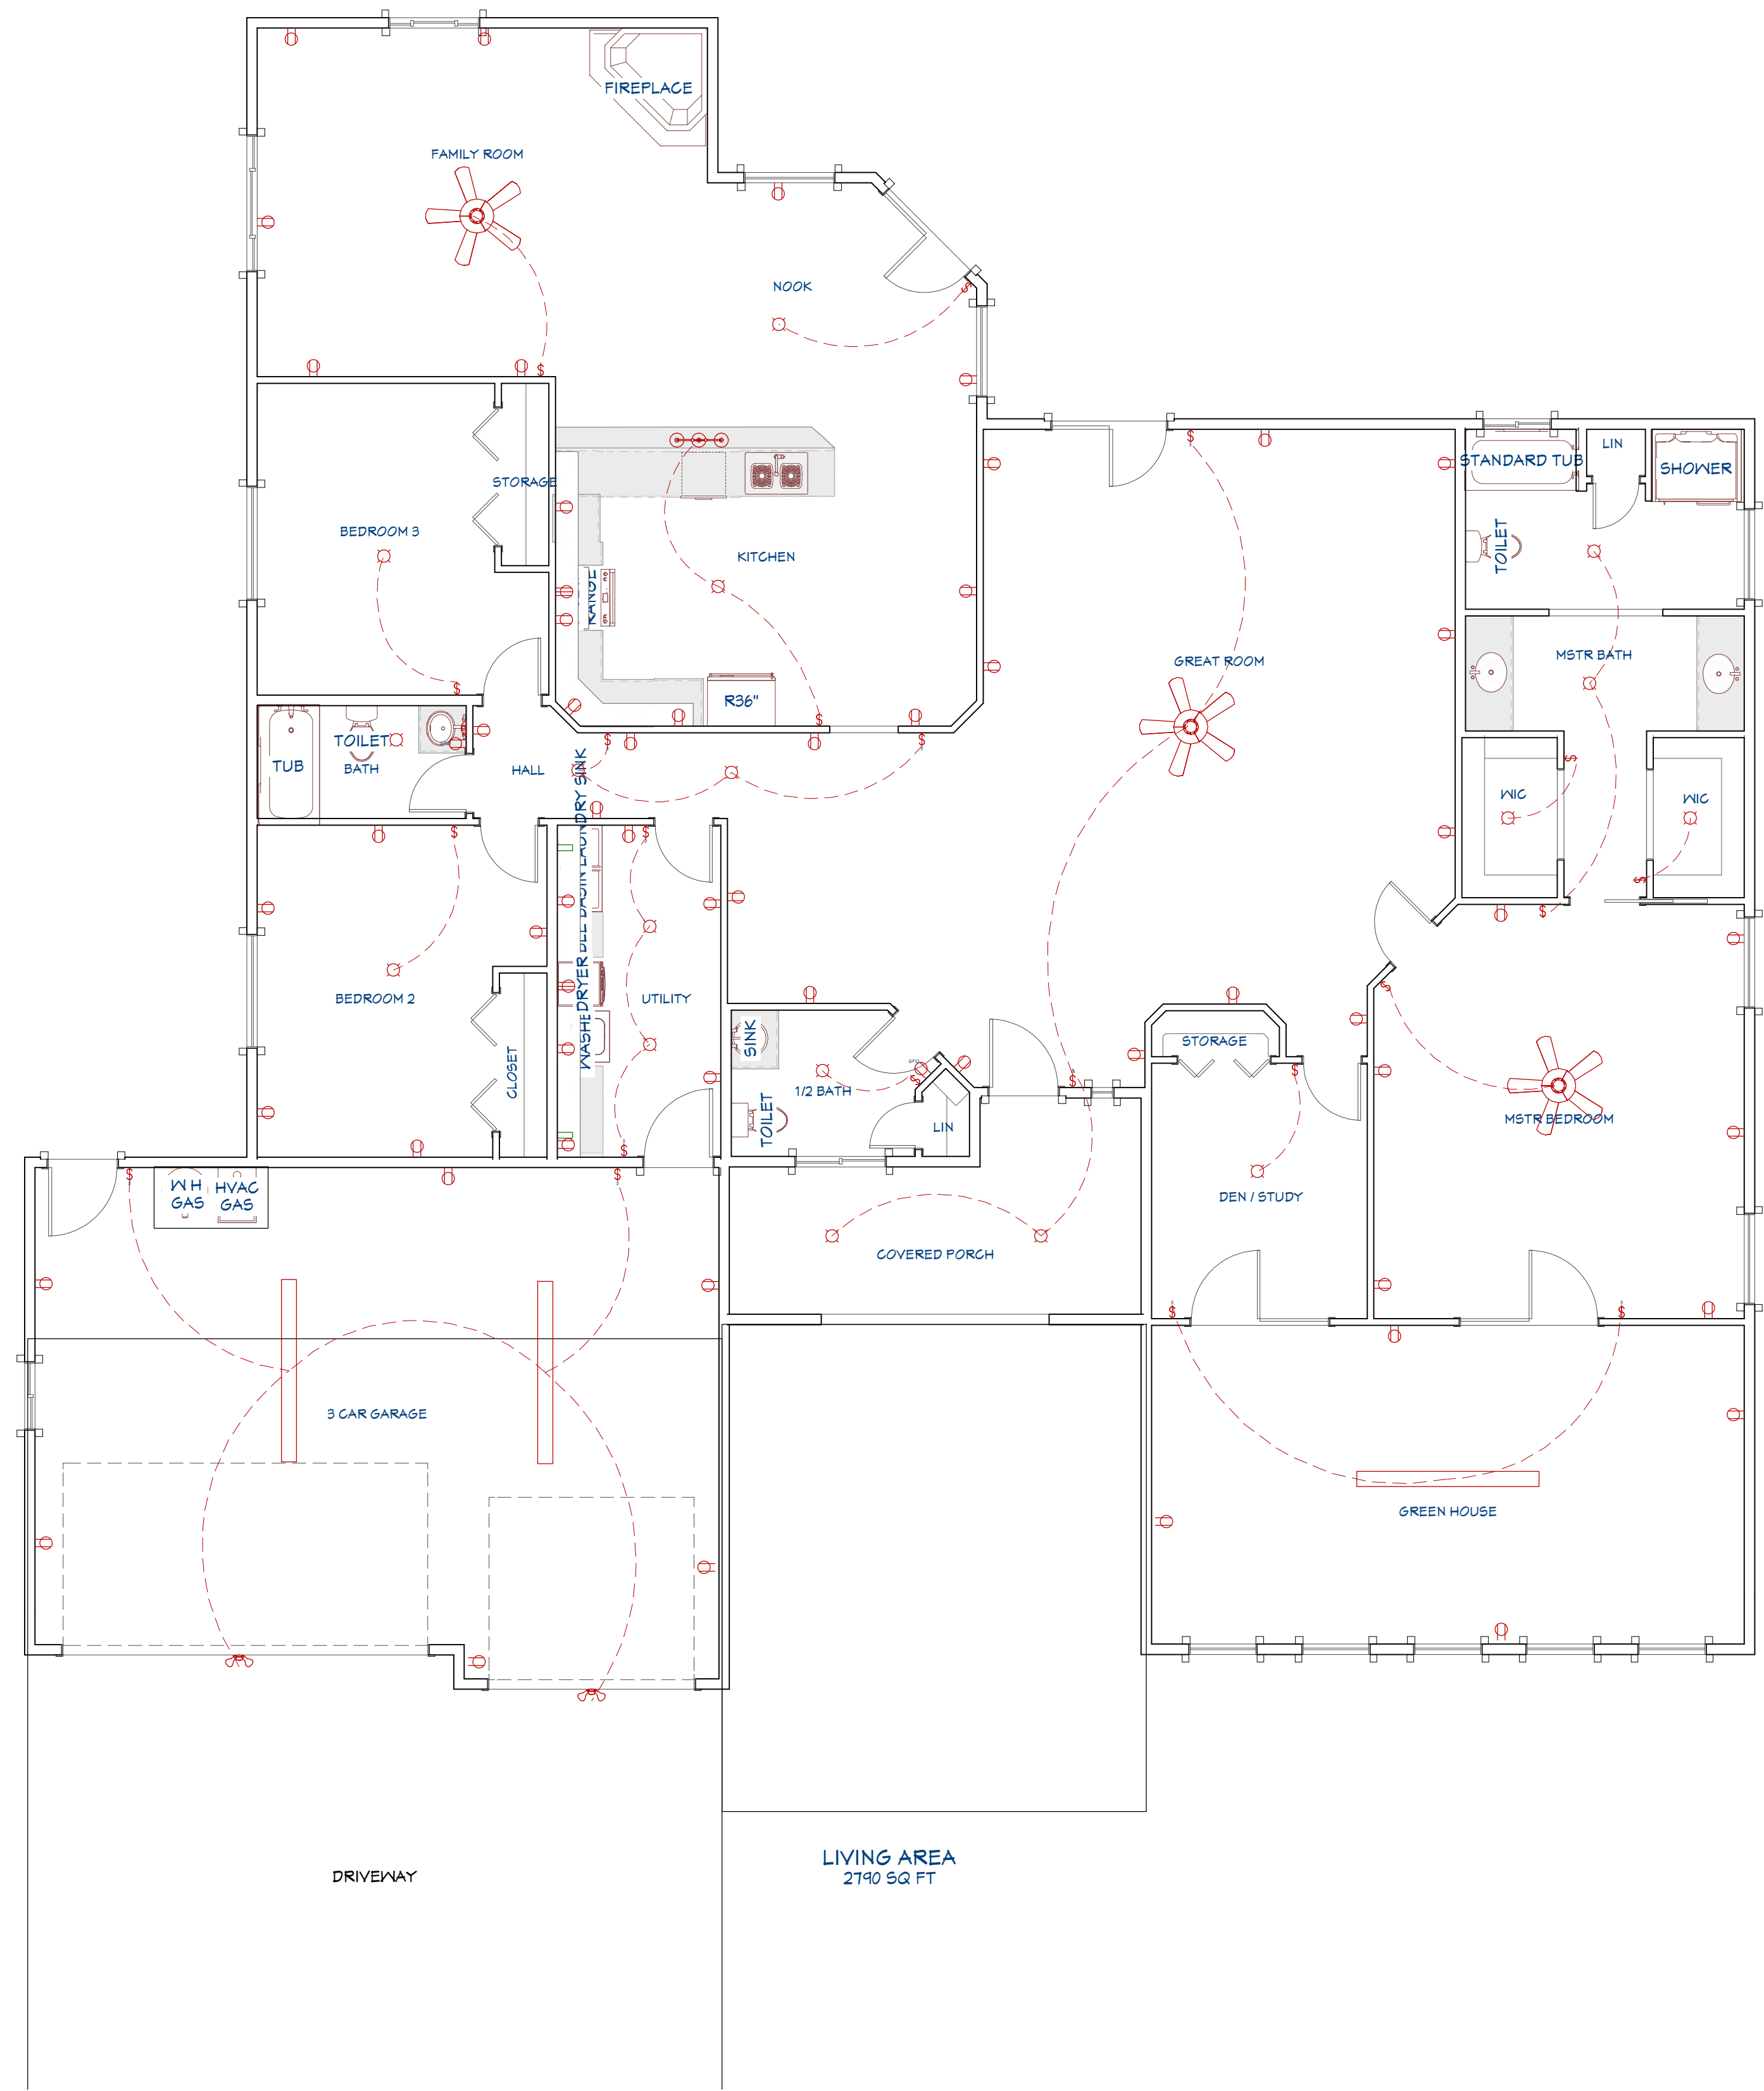

Electrical Plan View
3/16:=1'=0"

ELECTRICAL SCHEDULE				
2D SYMBOL	NUMBER	QTY	DESCRIPTION	COMMENTS
	E01	2	220V	
	E02	10	3-WAY SWITCH	
	E03	3	CLASSIC CEILING FAN LIGHT FIXTURE	
	E04	17	COMMON FLUSH MOUNT	
	E05	56	DUPLEX	
	E06	2	GFCI	
	E07	1	GRAN TENOS	
	E08	3	LONG SURFACE MOUNTED TUBE LIGHT [96"x41D]	
	E09	11	SINGLE POLE SWITCH	
	E10	2	SPOTLIGHT 2 MOTION SENSOR	
	E11	1	TRIPLE CLASSIC	

REVISION TABLE	
NUMBER	DATE

Electrical Plan View

DRAWINGS PROVIDED BY:
Bill Cullum

DATE:

4/25/2025

SCALE:

as shown

SHEET:

A-6

Sample



Kitchen View



Front Entry View



Master Bath View



3 Car Garage View

REVISION TABLE		REVISION BY		DESCRIPTION	
NUMBER	DATE				

Interior Details

DRAWINGS PROVIDED BY:
Bill Cullum

DATE:

4/25/2025

SCALE:

as shown

SHEET:

A-7

Sample